 
 
 

 
 
 
 
 













Drawing NO.	Title - phase1
Arc 1 - phase 1	proposed plan
Arc 2 - phase 1	Current Situation Plan
Arc 3 - phase 1	Walls to be moved
Arc 4 - phase 1	Emergency Stairs
Arc 5 - phase 1	Water Tanks Platform
Arc 6 - phase 1	Elevation
Arc 7 - phase 1	Details
Arc 8 - phase 1	Windows Details
Arc 9 - phase 1	Doors Details
Ele 1 - phase 1	CCTV CAMERAS
Ele 2 - phase 1	lighting plan
Ele 3 - phase 1	Power Plans
Ele 4 - phase 1	Points Location
Mec 1 phase 1	Alarm system
Mec 2 phase 1	Air Conditioning plan

Drawing Board - phase 1

LED down light 18 w	
LED down light 12 w	
Pole light 3m with LED light	
LED light 120cm with reflector	
LED Mirror light 12 w	
one way one gang switch	
one way two gang switch	
Two way one gang switch	
Push Button	
Single socket	
Double socket	
1 Ton A/c	
1.5 Ton A/c	
Pullet camera	
Dome camera	
Smoke detector	
Heat detector	
Sounder	
Automatic Fire extinguisher	
Fire extinguisher	
Break glass	
TV Outlet	
Telephone Outlet	
Data Outlet	

         

Eng. Khaled Al Jammal
project manager


E-mail: khjammal@hotmail.com
Damascus , Syria

Proposal : 1st floor plan
scale : to fit

Project Name
UNFPA new floor in Damascus

Sheet Size
A3

Date : 27/8/2018

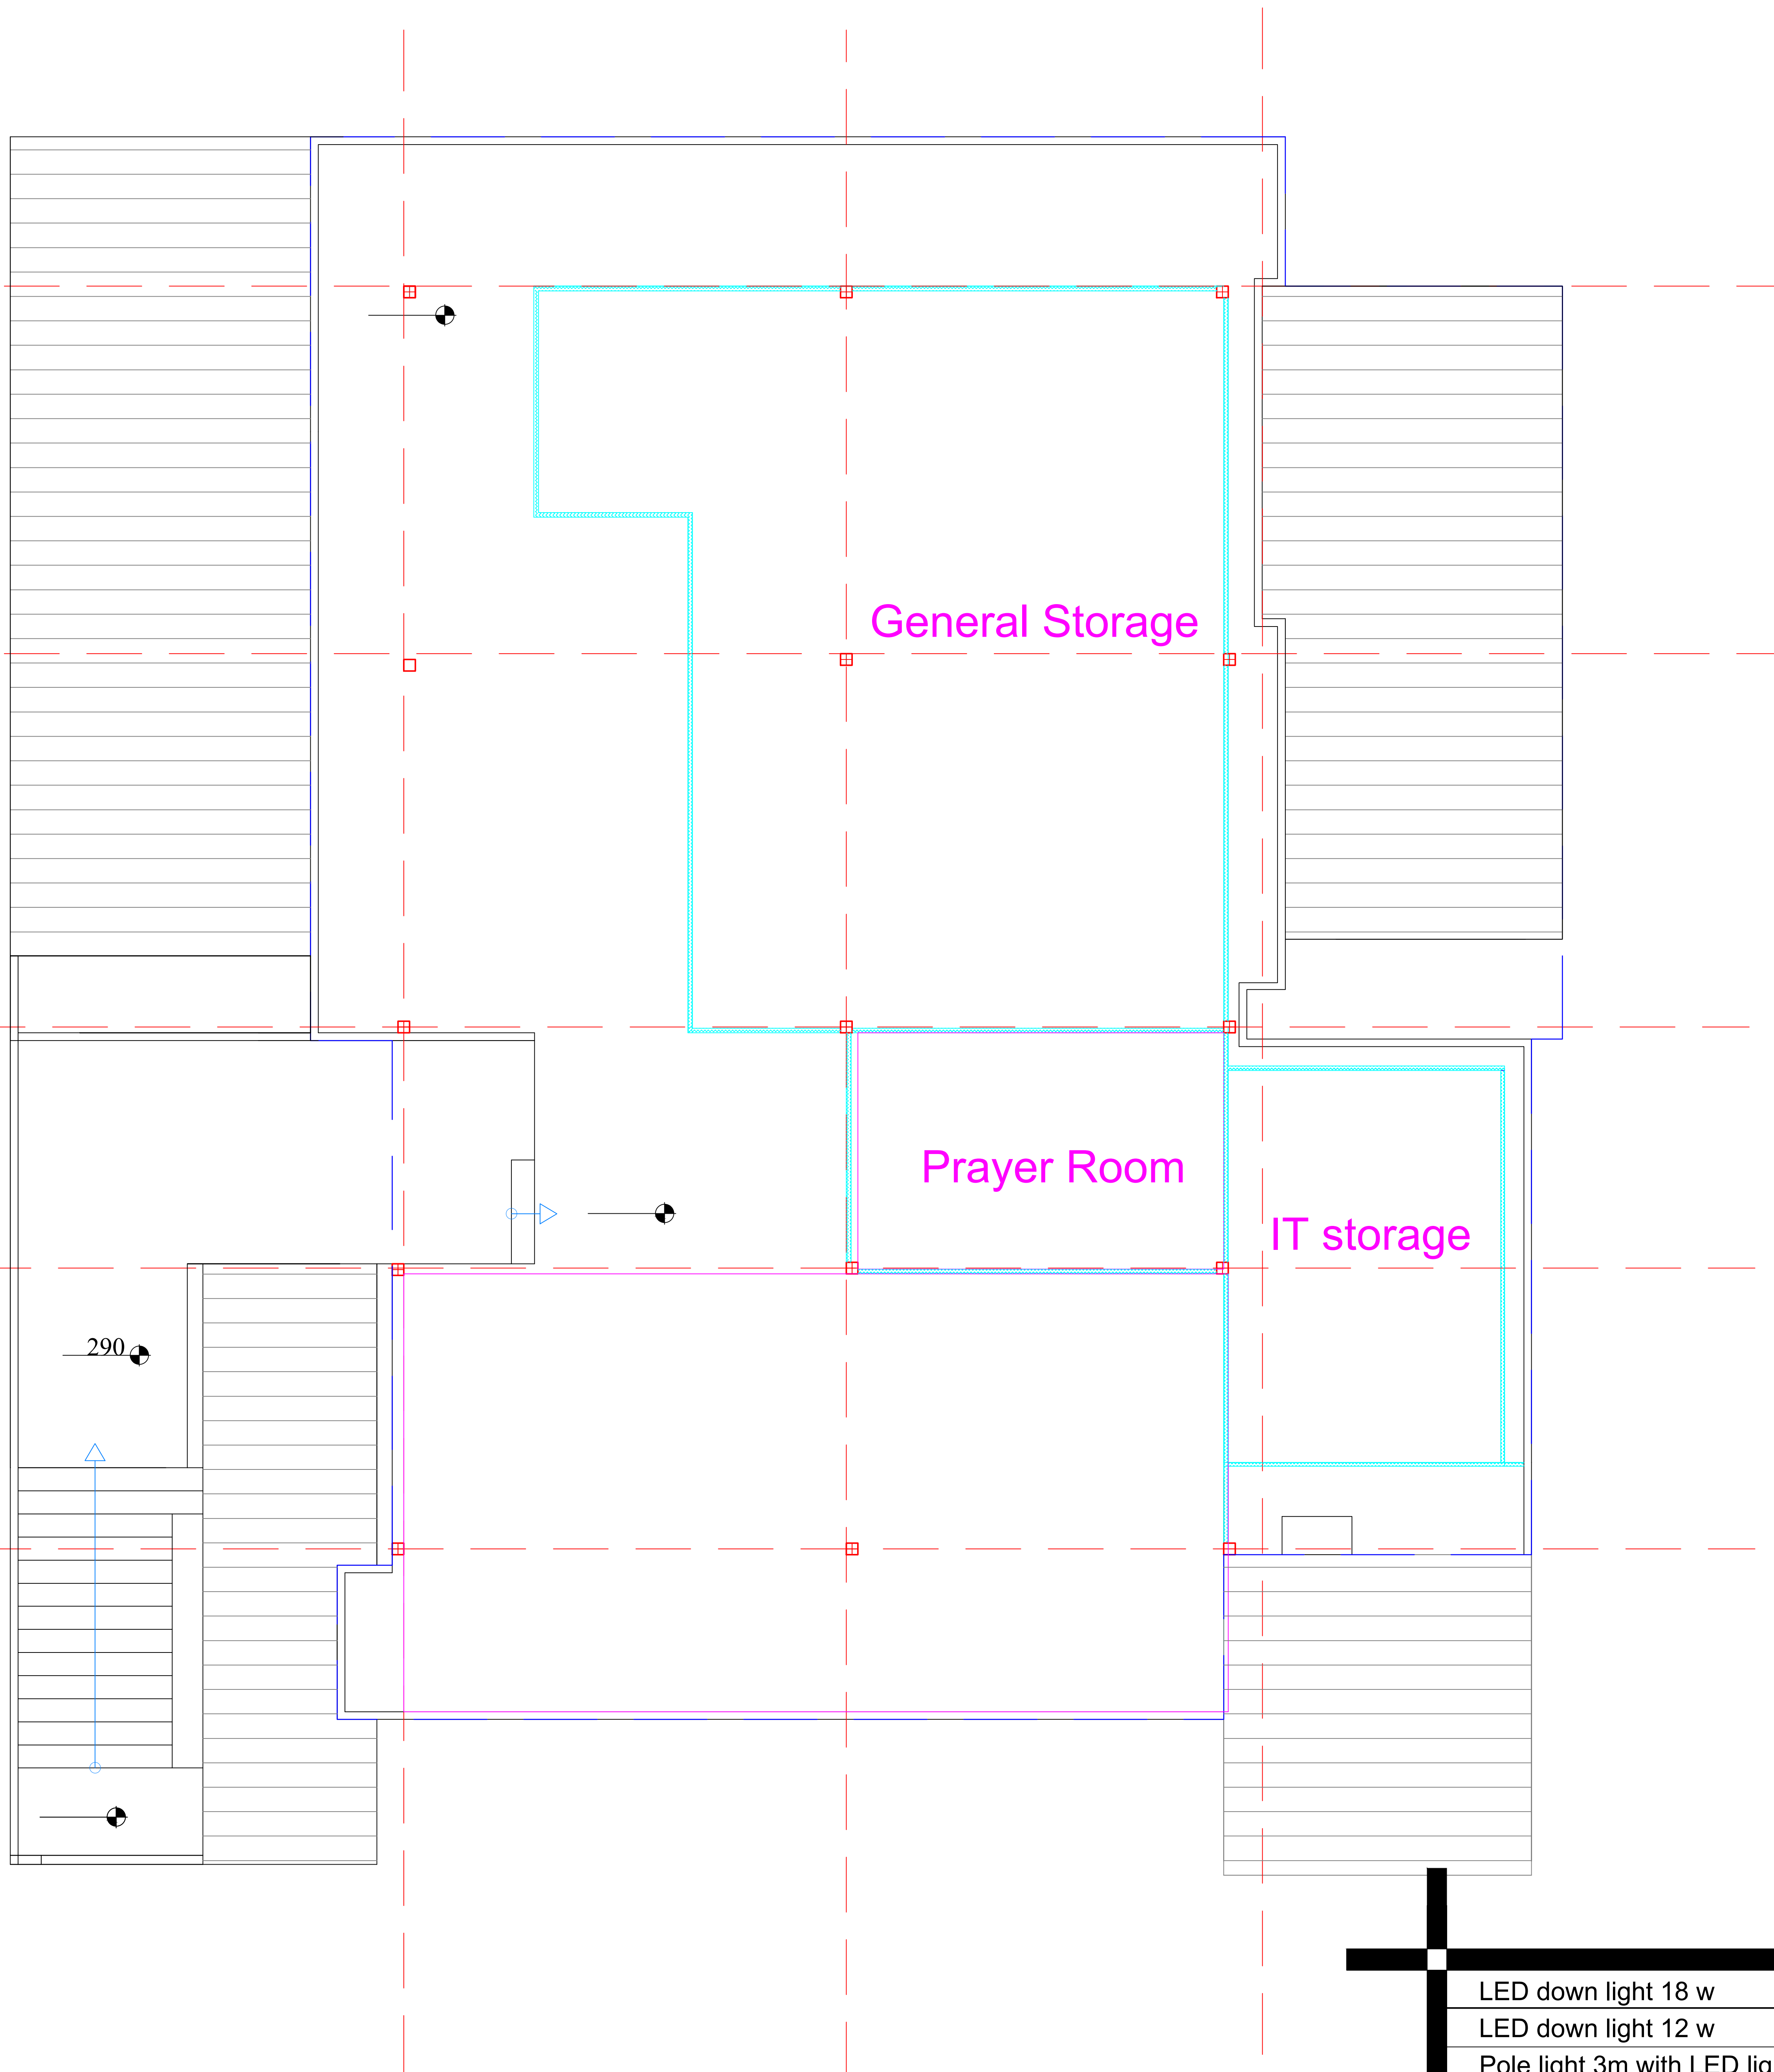

Current Situation Plan - phase 1

LED down light 18 w	
LED down light 12 w	
Pole light 3m with LED light	
LED light 120cm with reflector	
LED Mirror light 12 w	
one way one gang switch	
one way two gang switch	
Two way one gang switch	
Push Button	
Single socket	
Double socket	
1 Ton A/c	
1.5 Ton A/c	
Pullet camera	
Dome camera	
Smoke detector	
Heat detector	
Sounder	
Automatic Fire extinguisher	
Fire extinguisher	
Break glass	
TV Outlet	
Telephone Outlet	
Data Outlet	



Eng. Khaled Al Jammal
project manager


E-mail: khjammal@hotmail.com
Damascus , Syria

Proposal : 1st floor plan
scale : to fit

Project Name
UNFPA new floor in Damascus

Sheet Size
A3

Date : 27/8/2018

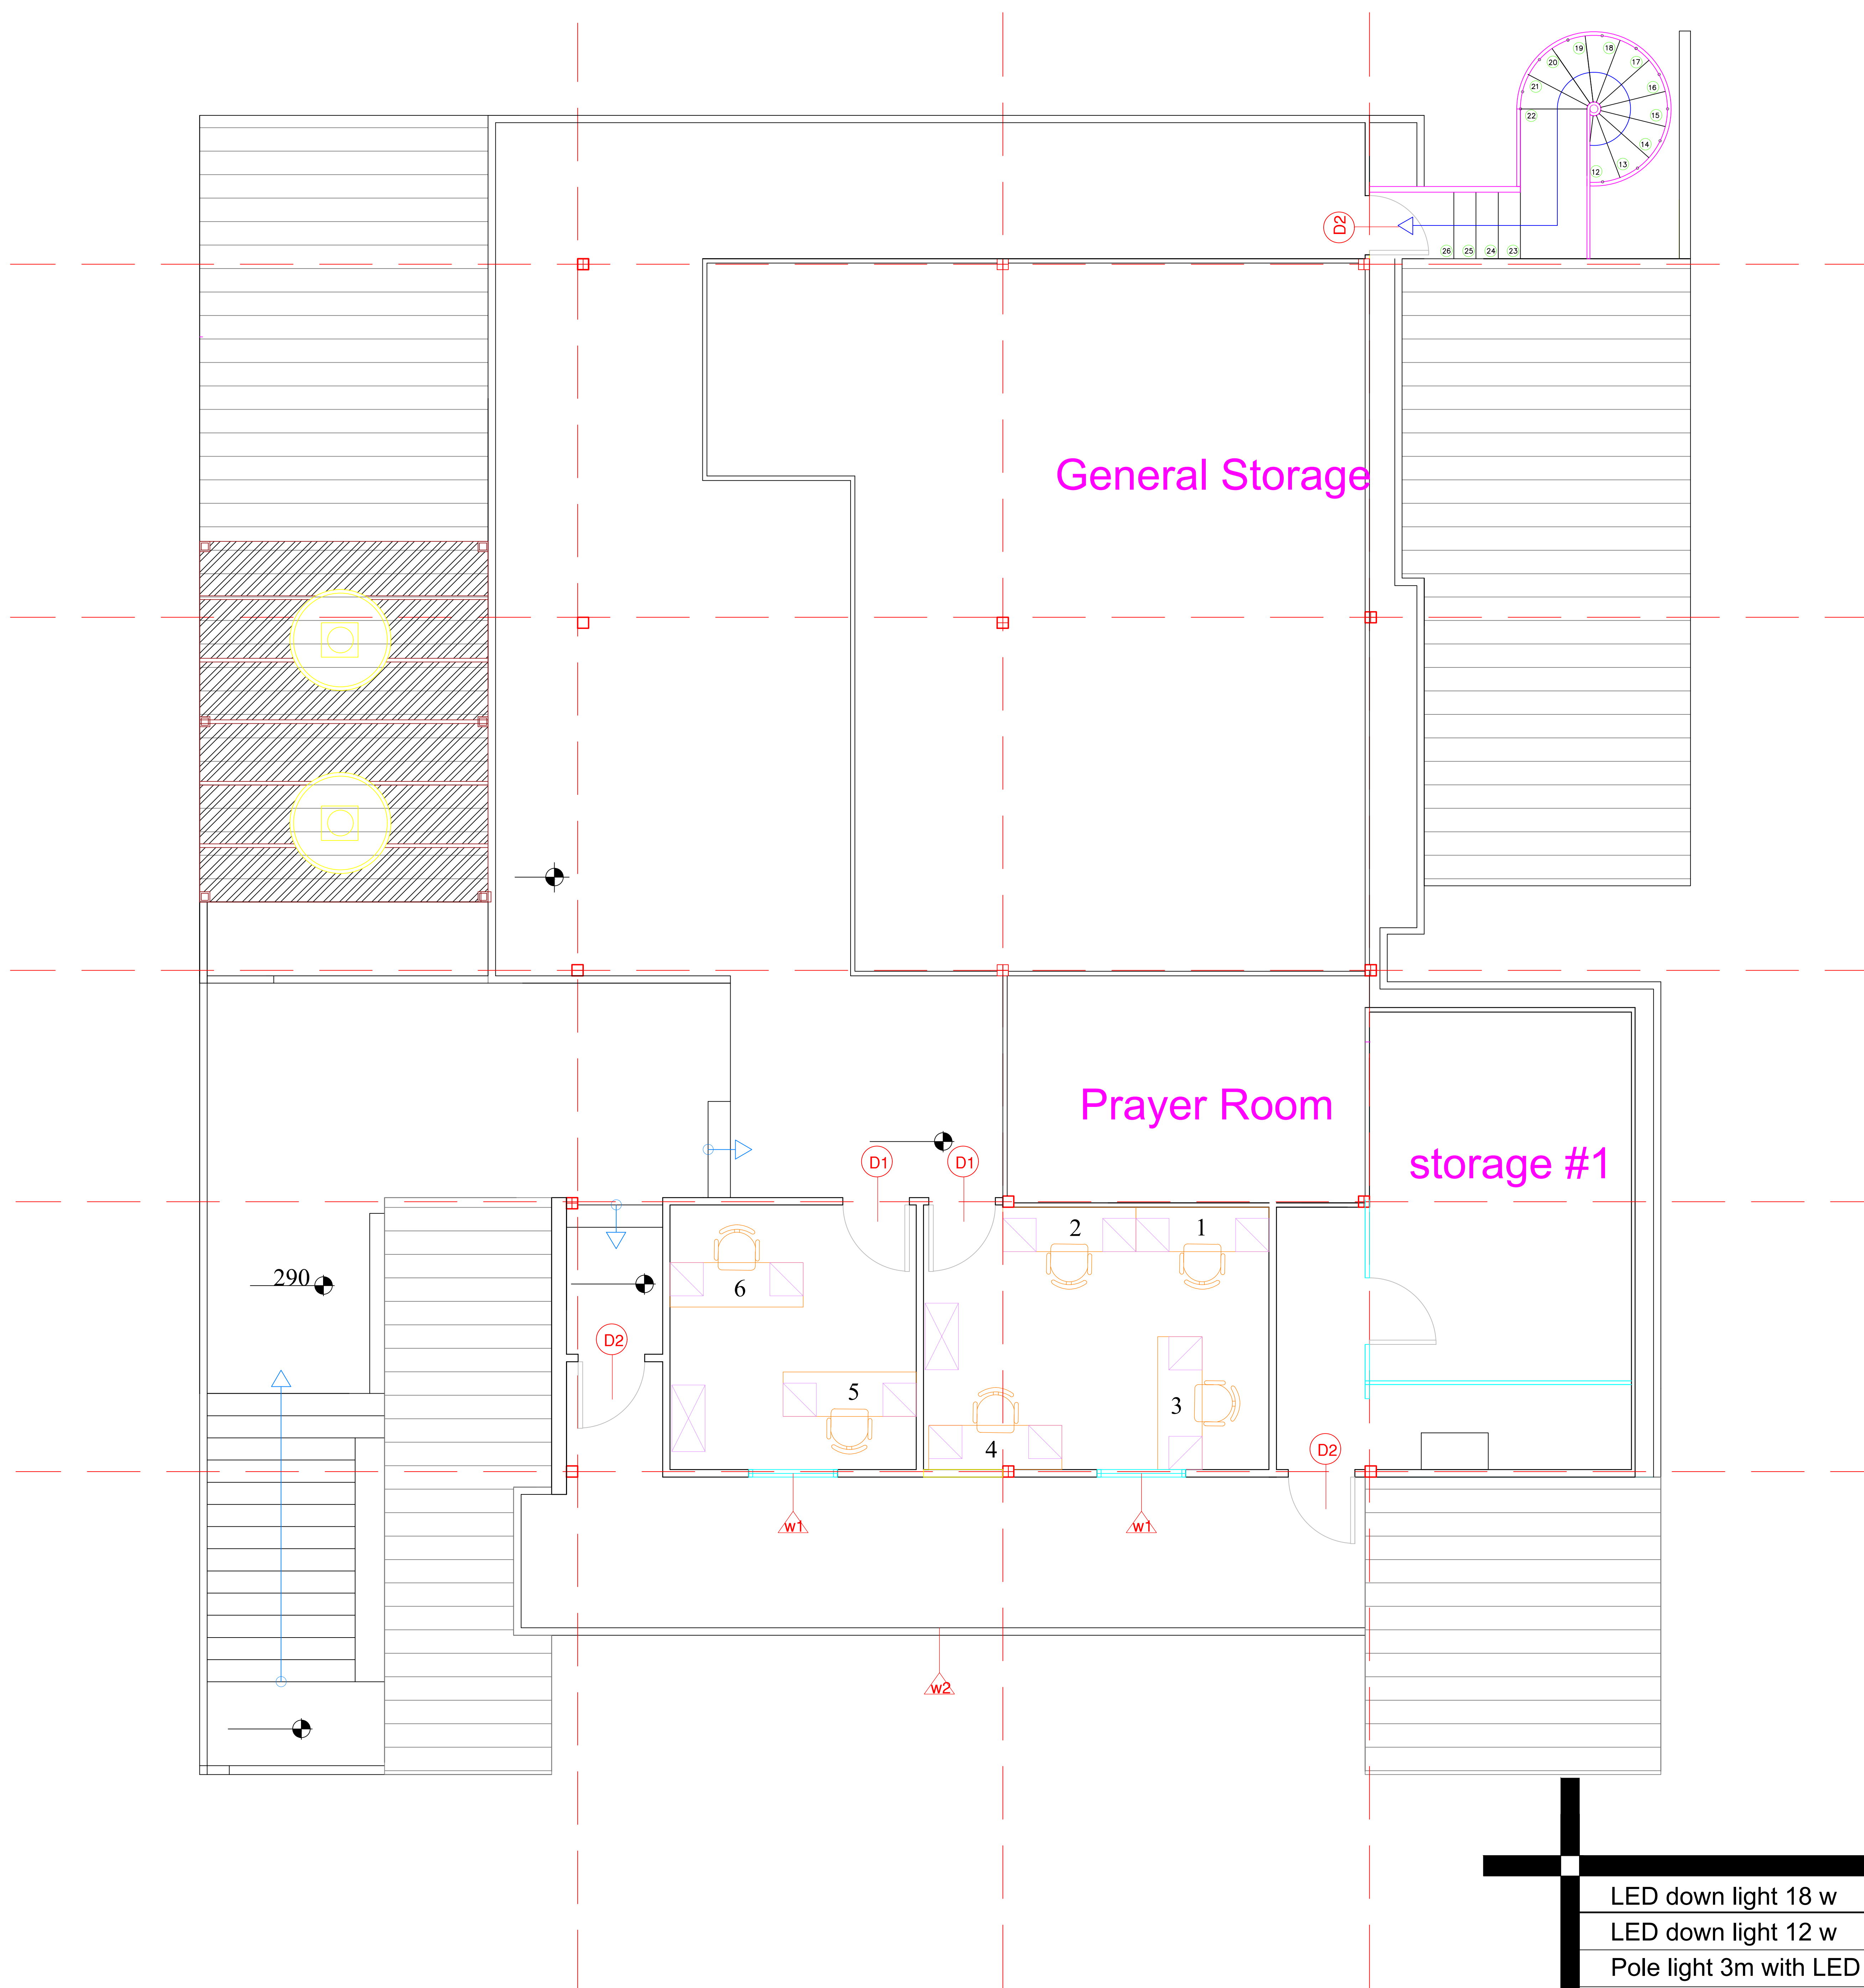

proposed plan - phase 1

LED down light 18 w	
LED down light 12 w	
Pole light 3m with LED light	
LED light 120cm with reflector	
LED Mirror light 12 w	
one way one gang switch	
one way two gang switch	
Two way one gang switch	
Push Button	
Single socket	
Double socket	
1 Ton A/c	
1.5 Ton A/c	
Pullet camera	
Dome camera	
Smoke detector	
Heat detector	
Sounder	
Automatic Fire extinguisher	
Fire extinguisher	
Break glass	
TV Outlet	
Telephone Outlet	
Data Outlet	



Eng. Khaled Al Jammal
project manager


E-mail: khjammal@hotmail.com
Damascus , Syria

Proposal : 1st floor plan
scale : to fit

 
 
 

 
 
 
 
 
 












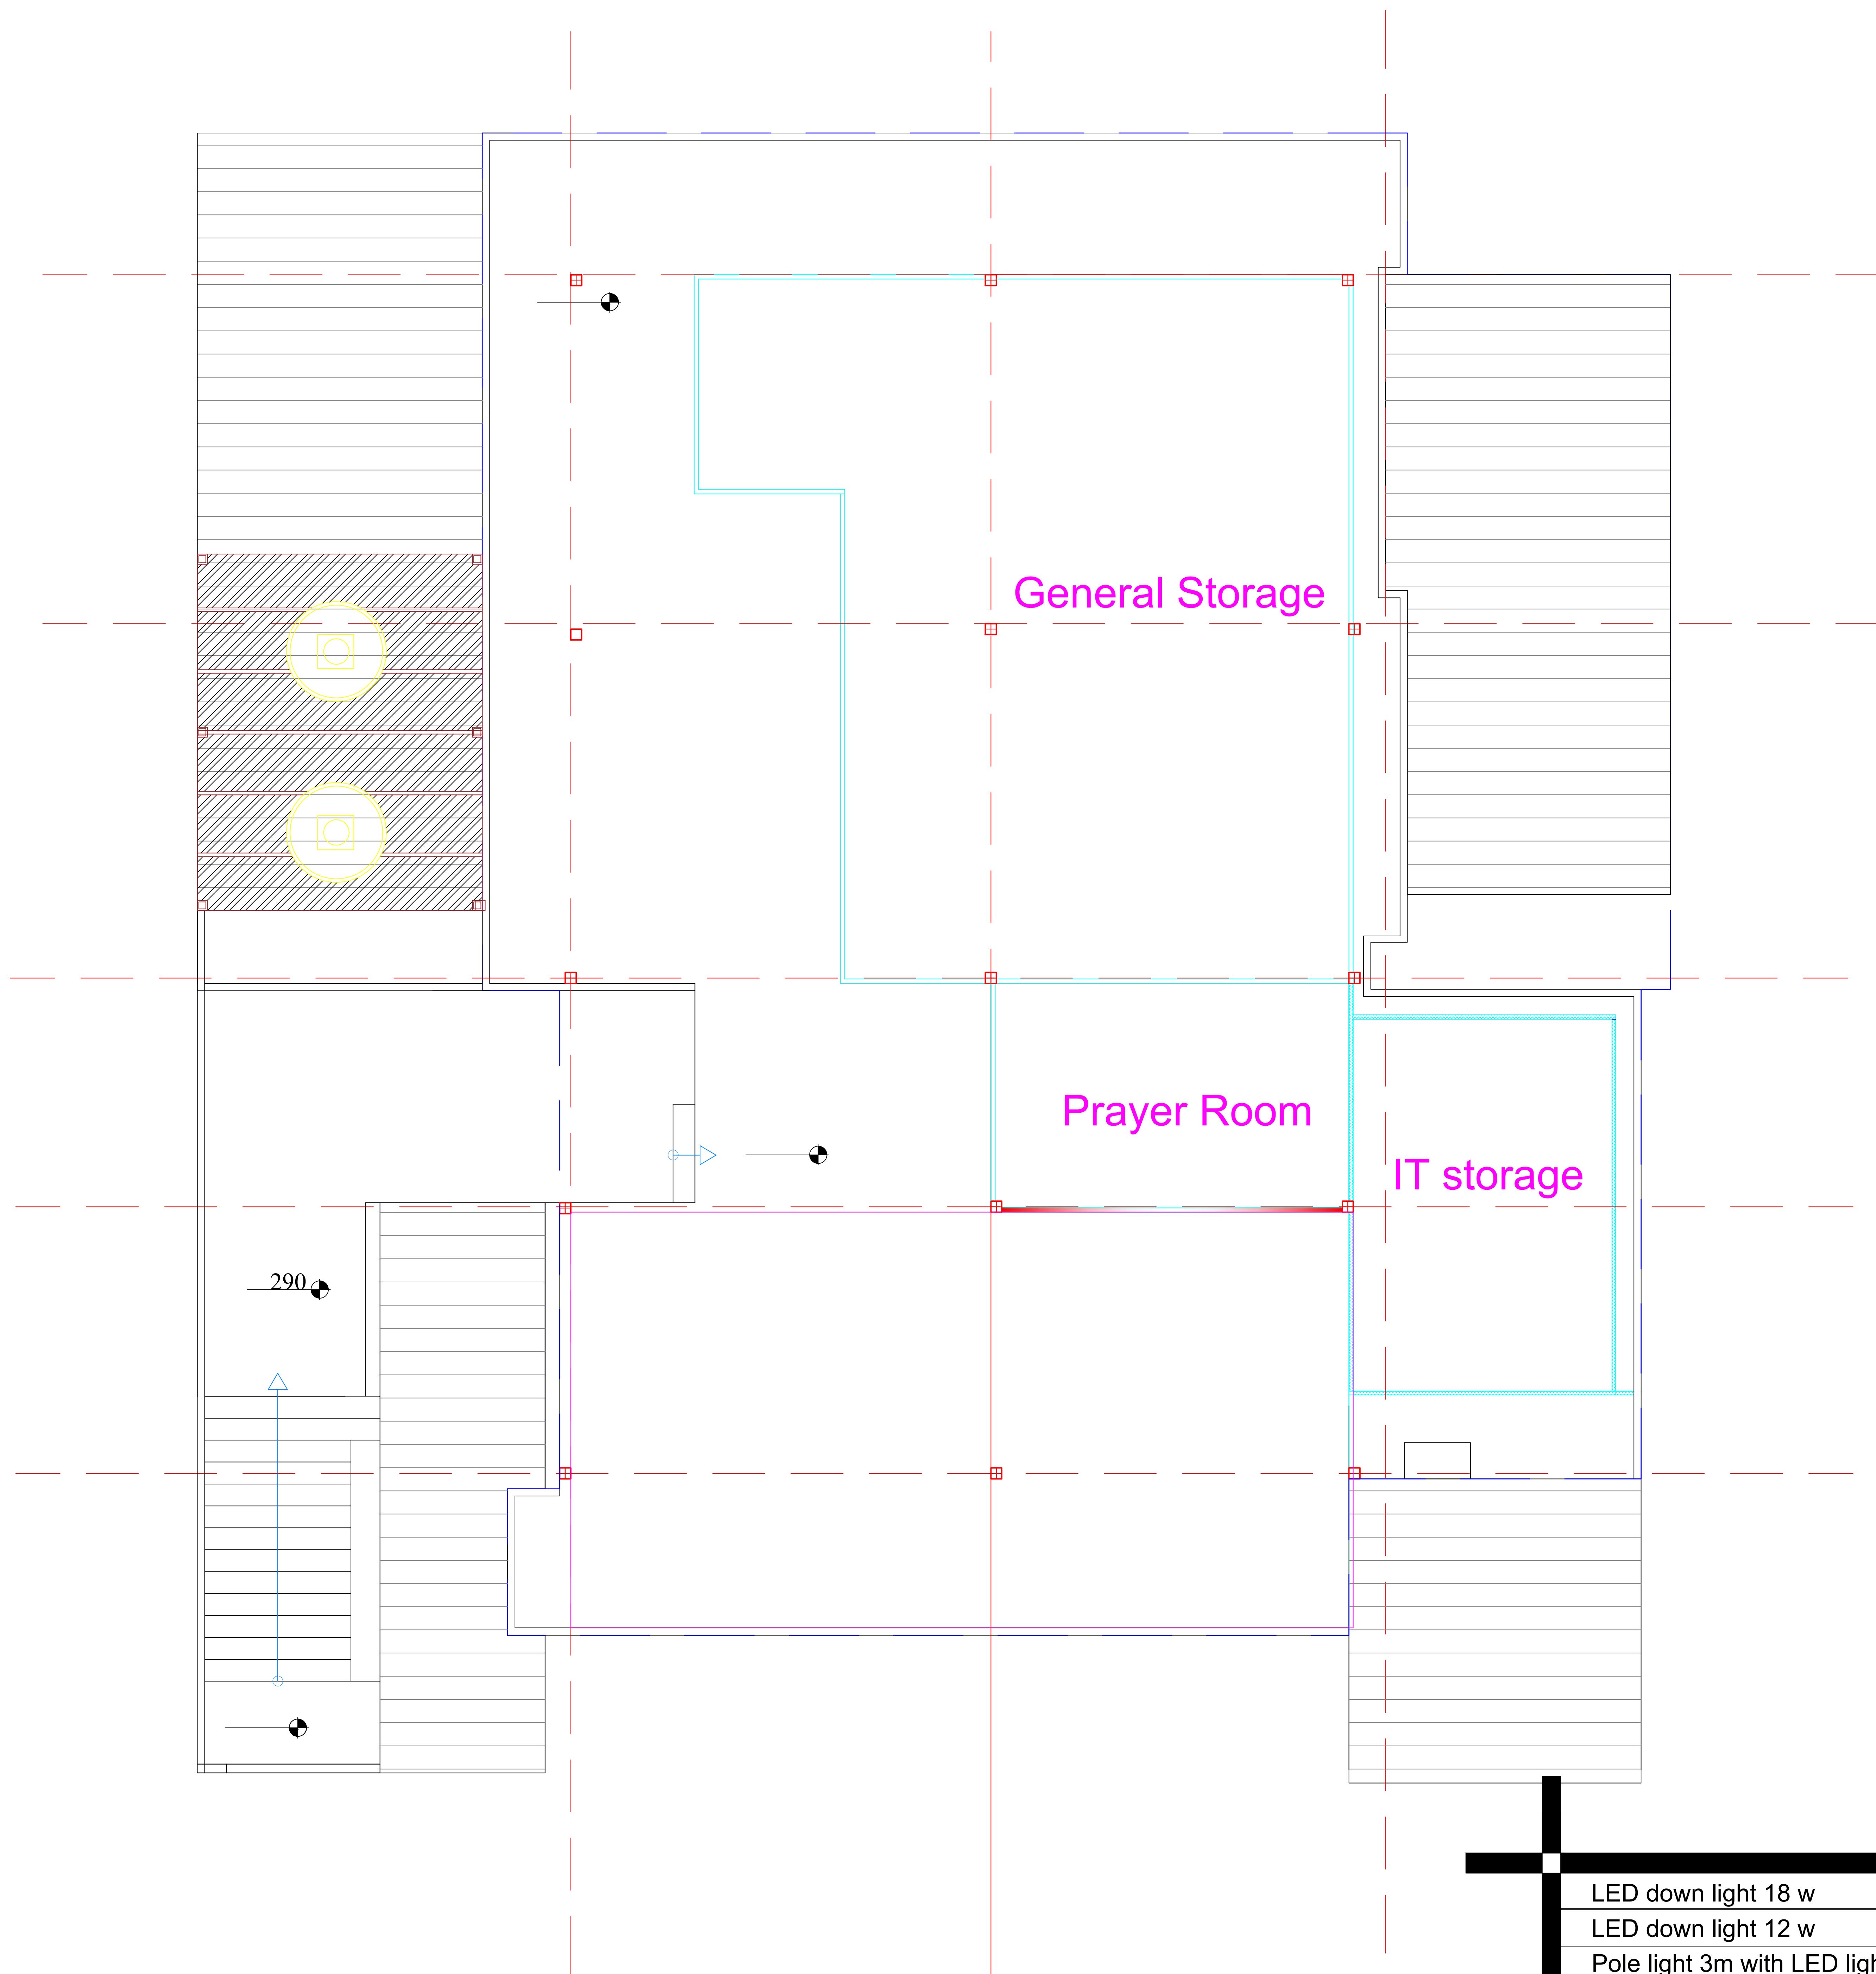

Project Name
UNFPA new floor in Damascus

Sheet Size
A3

        Date : 27/8/2018



Walls to be moved - phase 1 

LED down light 18 w	
LED down light 12 w	
Pole light 3m with LED light	
LED light 120cm with reflector	
LED Mirror light 12 w	
one way one gang switch	
one way two gang switch	
Two way one gang switch	
Push Button	
Single socket	
Double socket	
1 Ton A/c	
1.5 Ton A/c	
Pullet camera	
Dome camera	
Smoke detector	
Heat detector	
Sounder	
Automatic Fire extinguisher	
Fire extinguisher	
Break glass	
TV Outlet	
Telephone Outlet	
Data Outlet	








Eng. Khaled Al Jammal
project manager
E-mail: khjammal@hotmail.com
Damascus , Syria

Proposal : 1st floor plan
scale : to fit

Project Name
UNFPA new floor in Damascus

Sheet Size
A3

Date : 27/8/2018

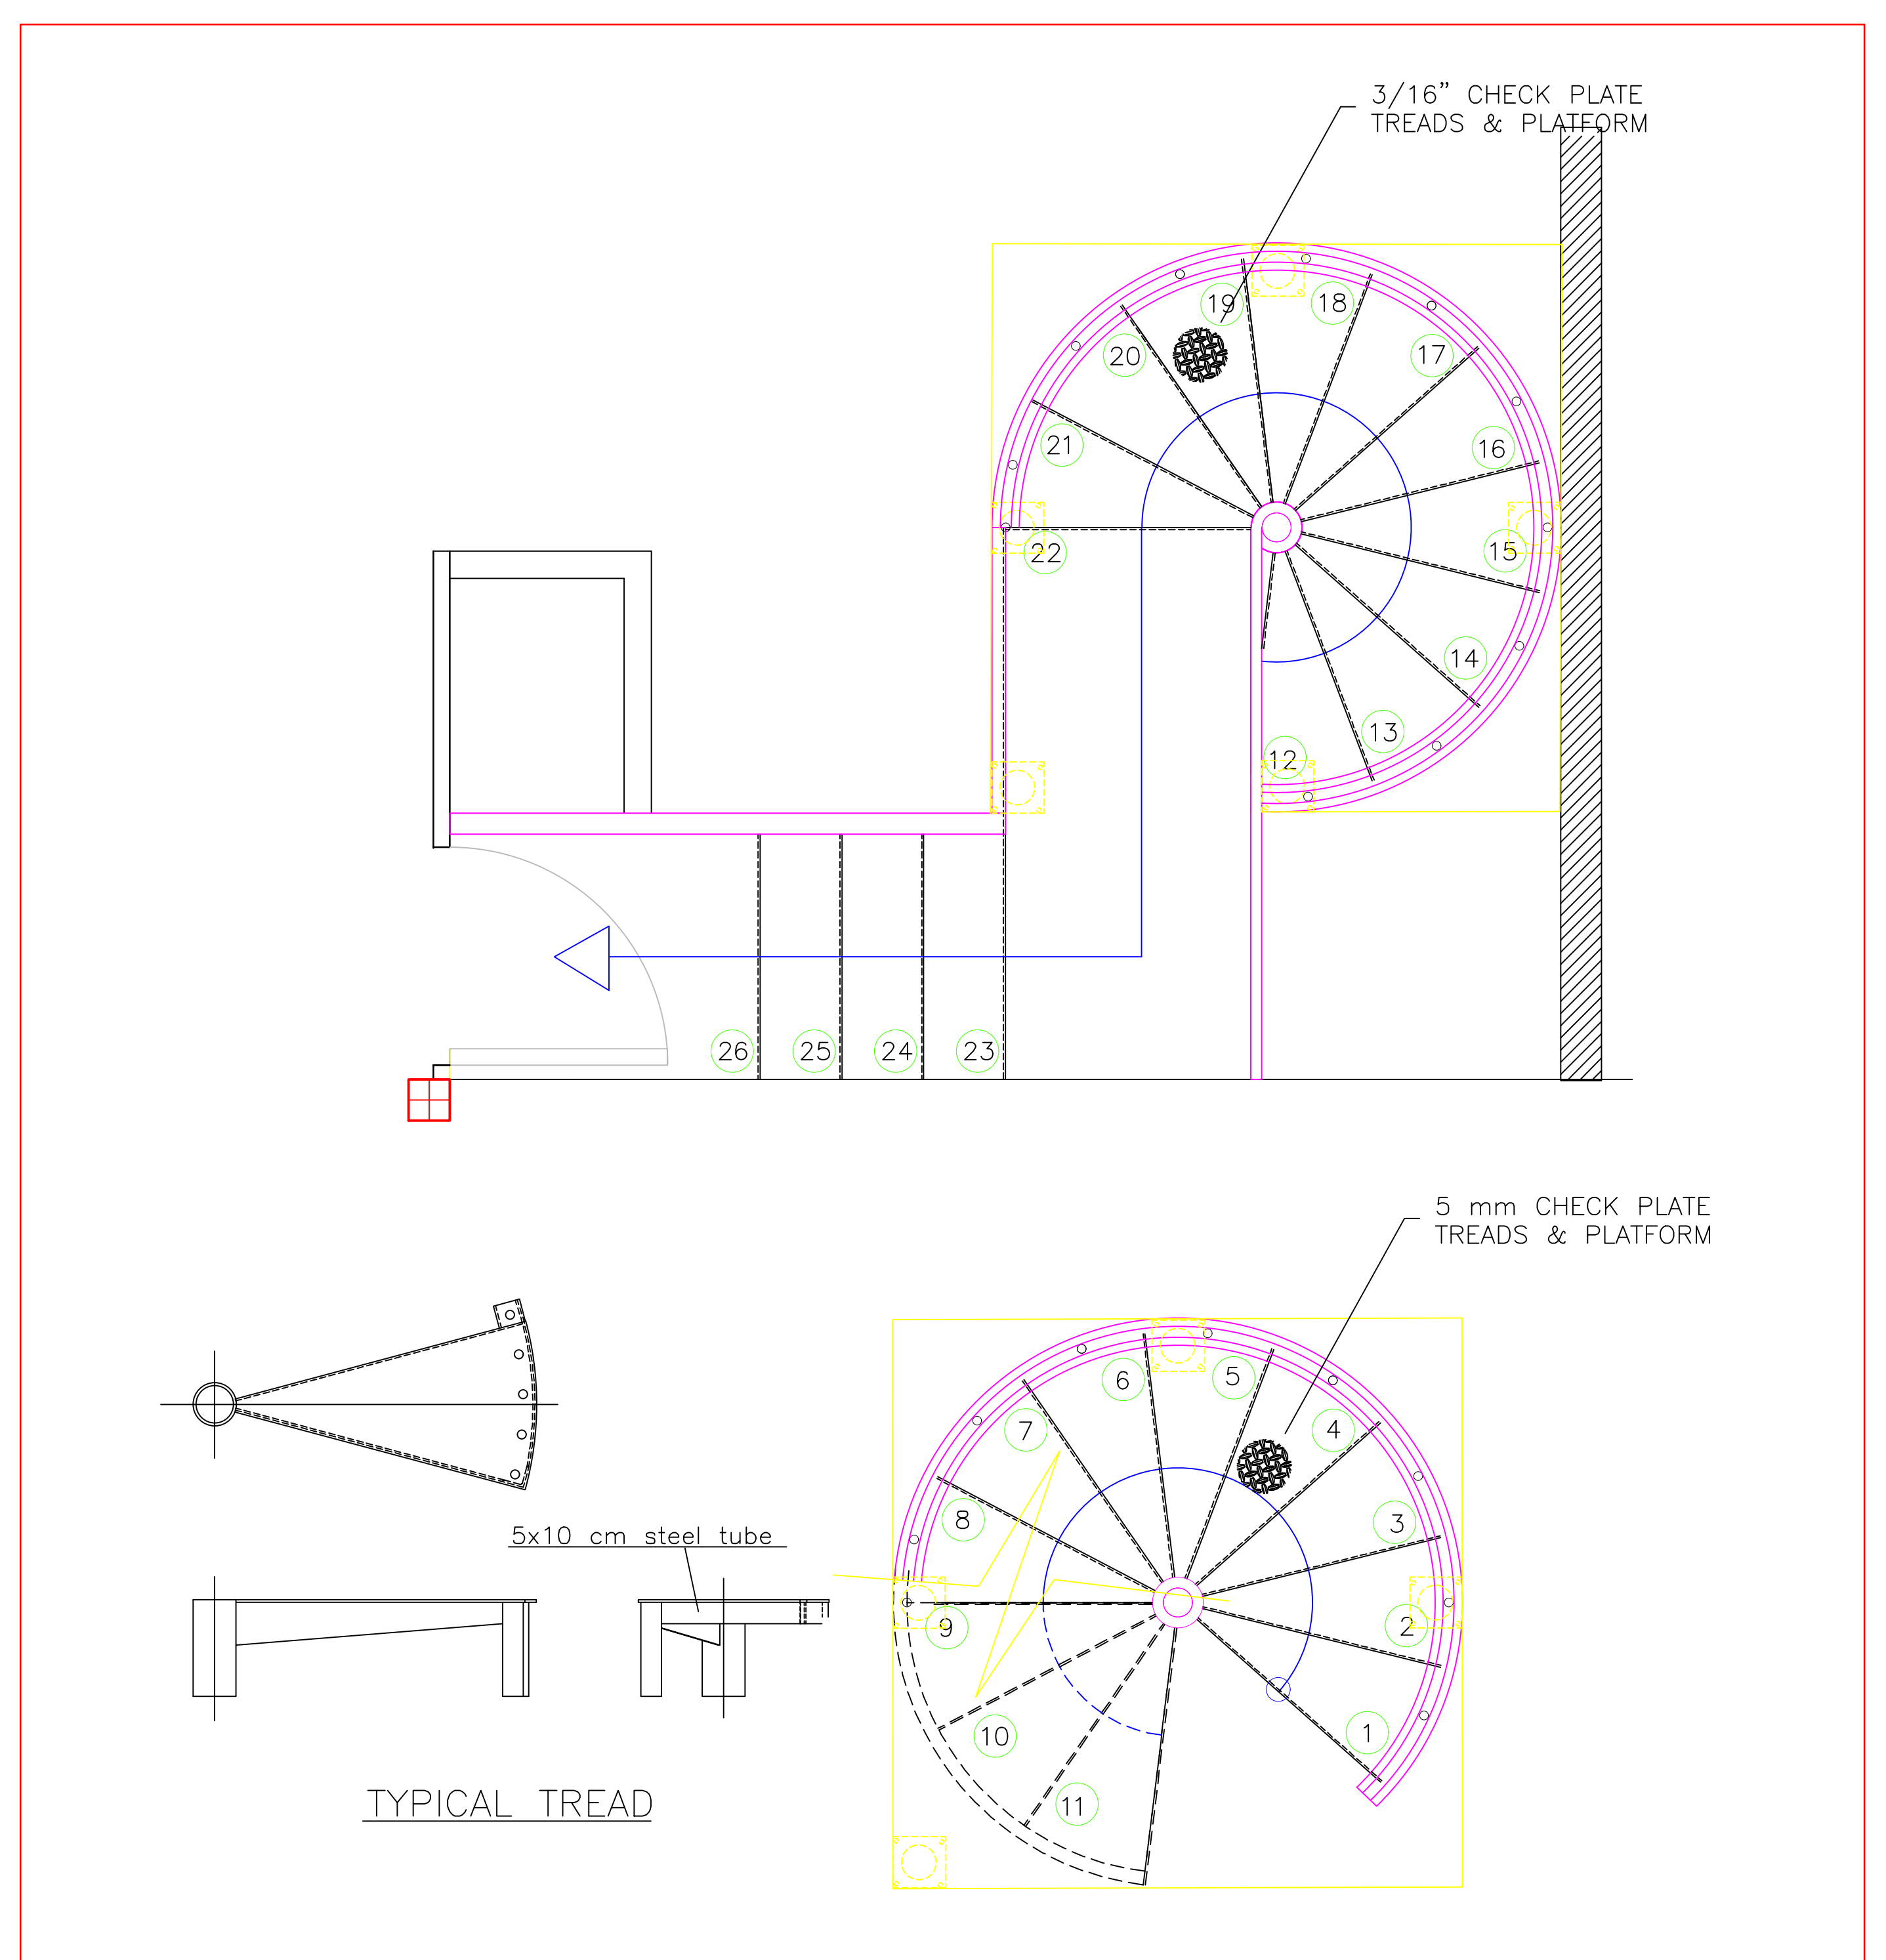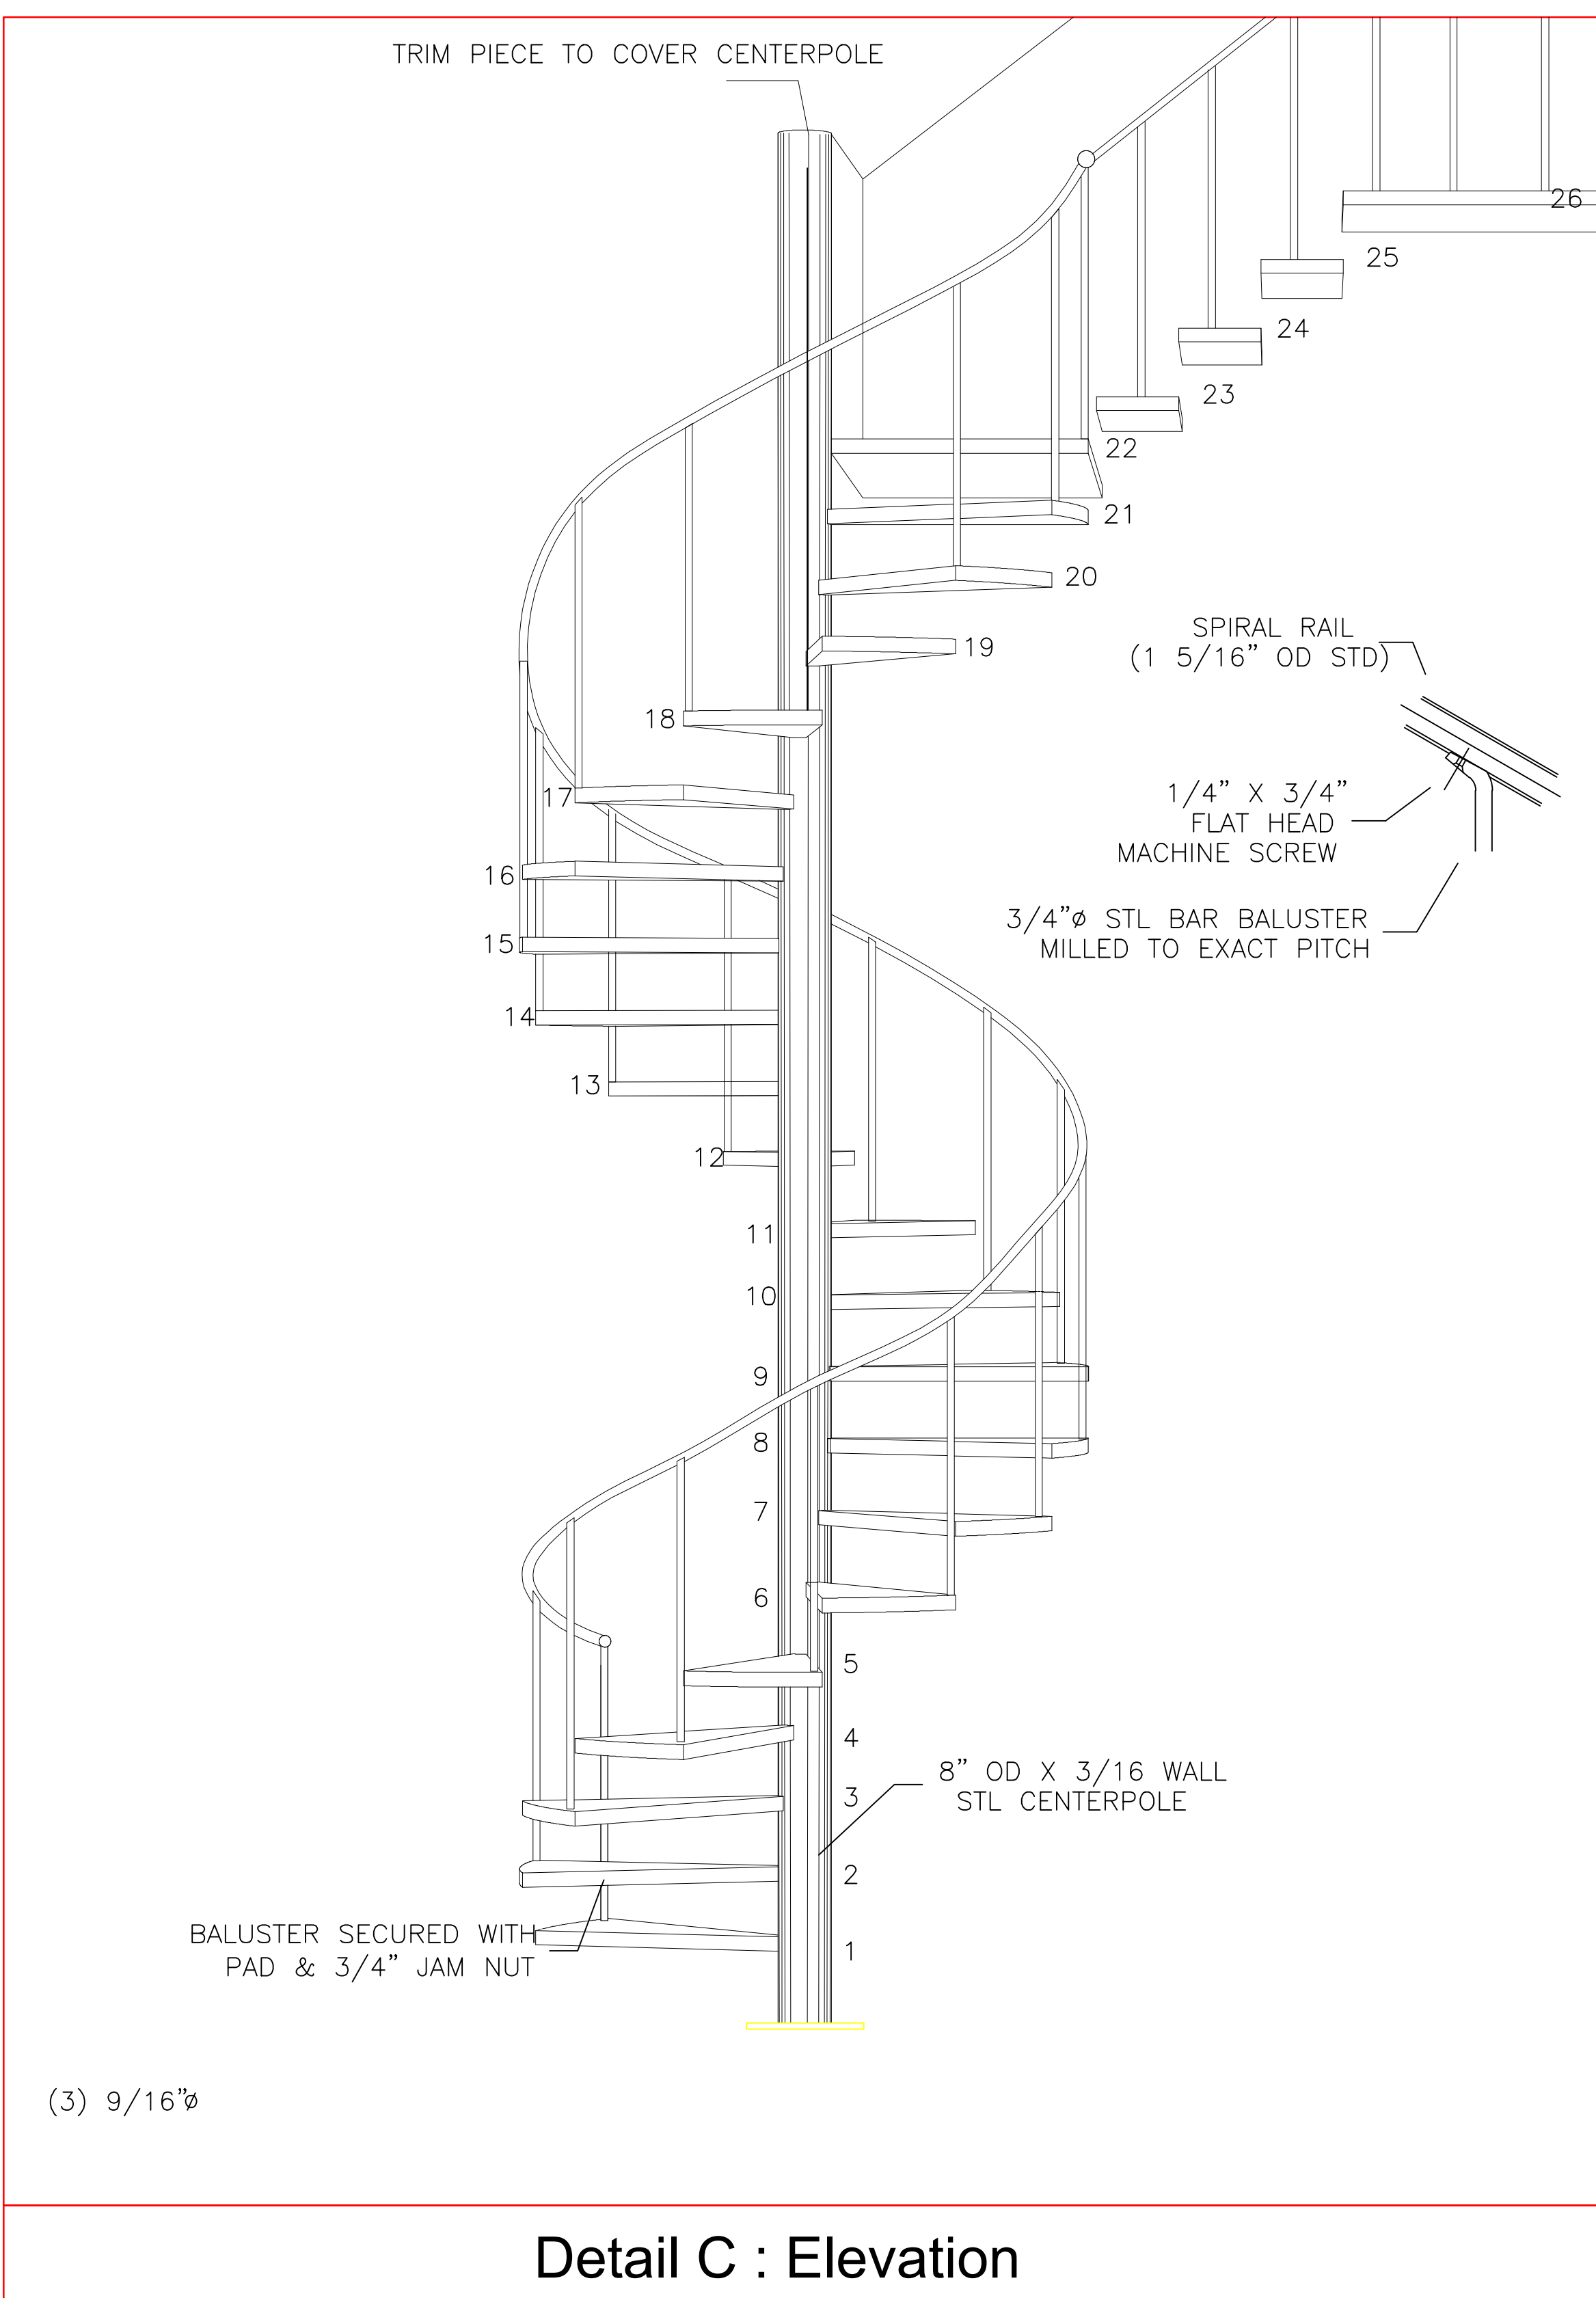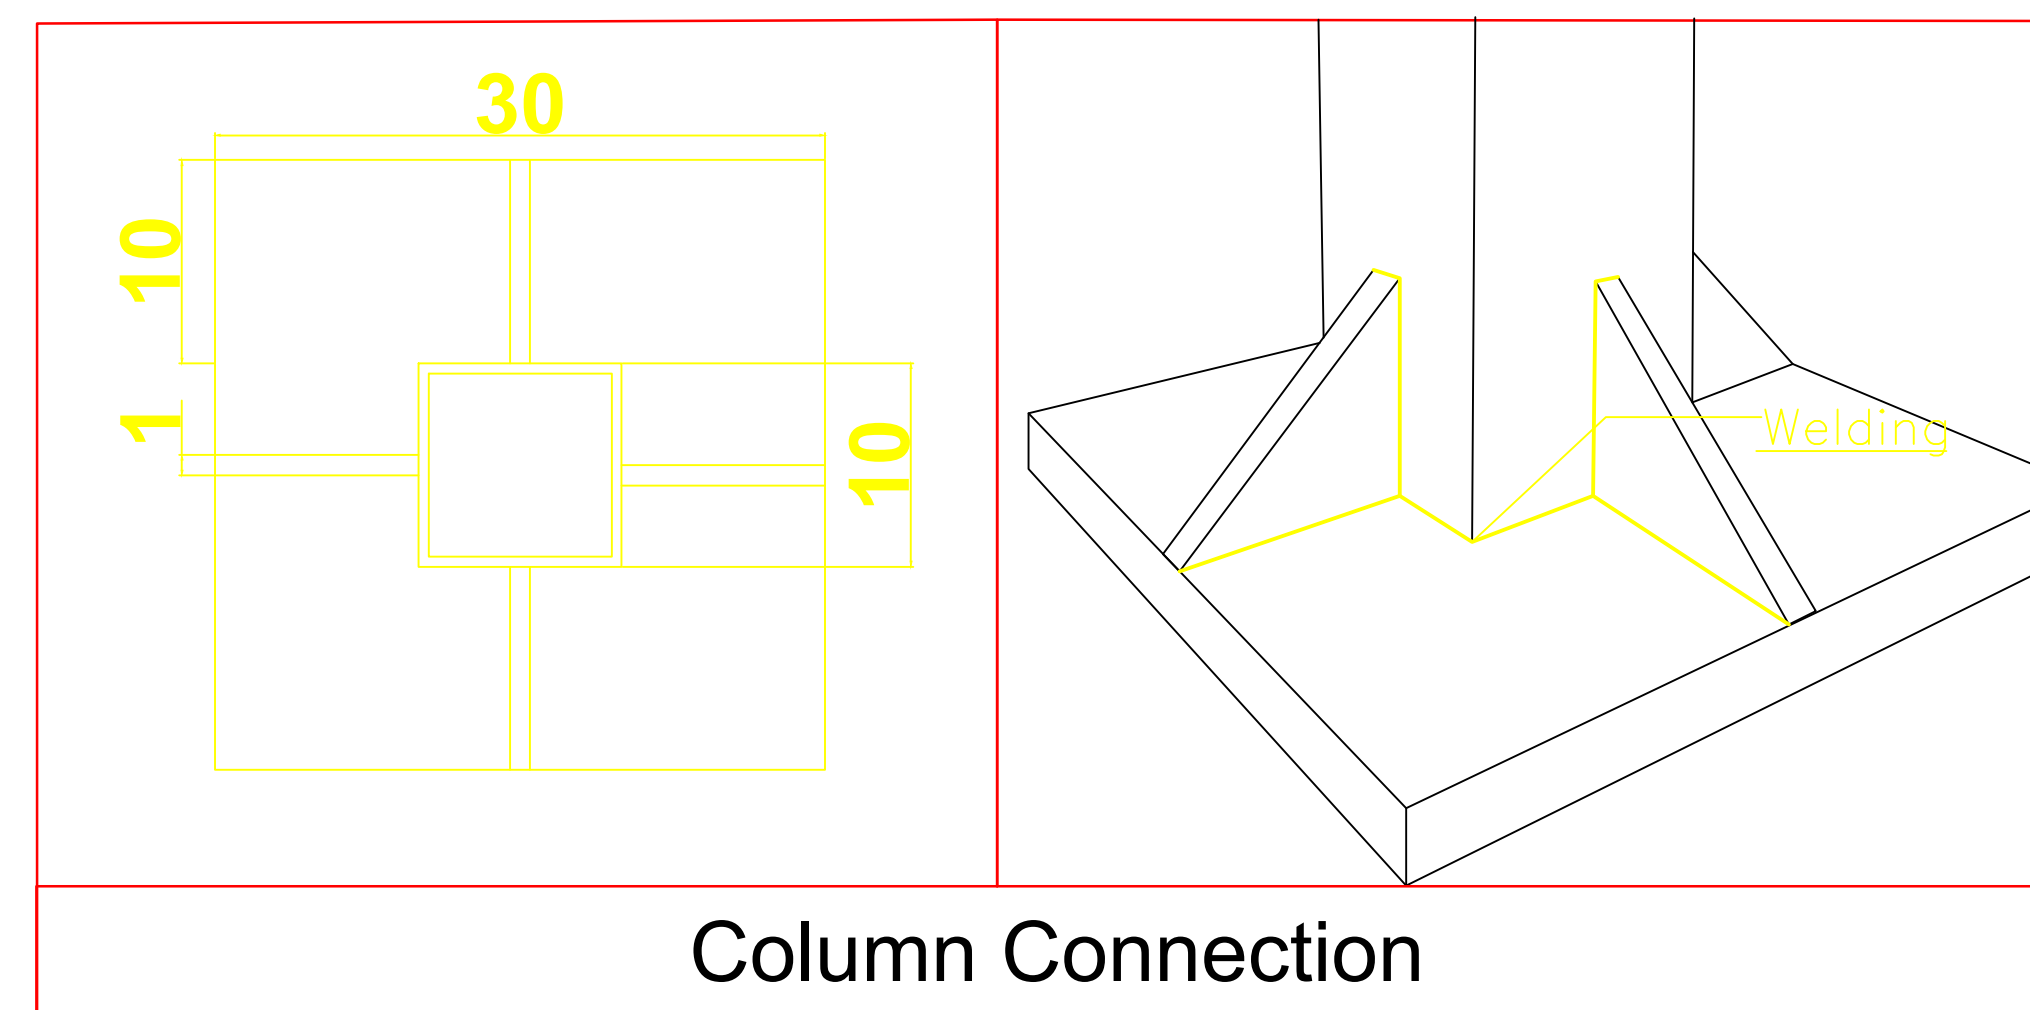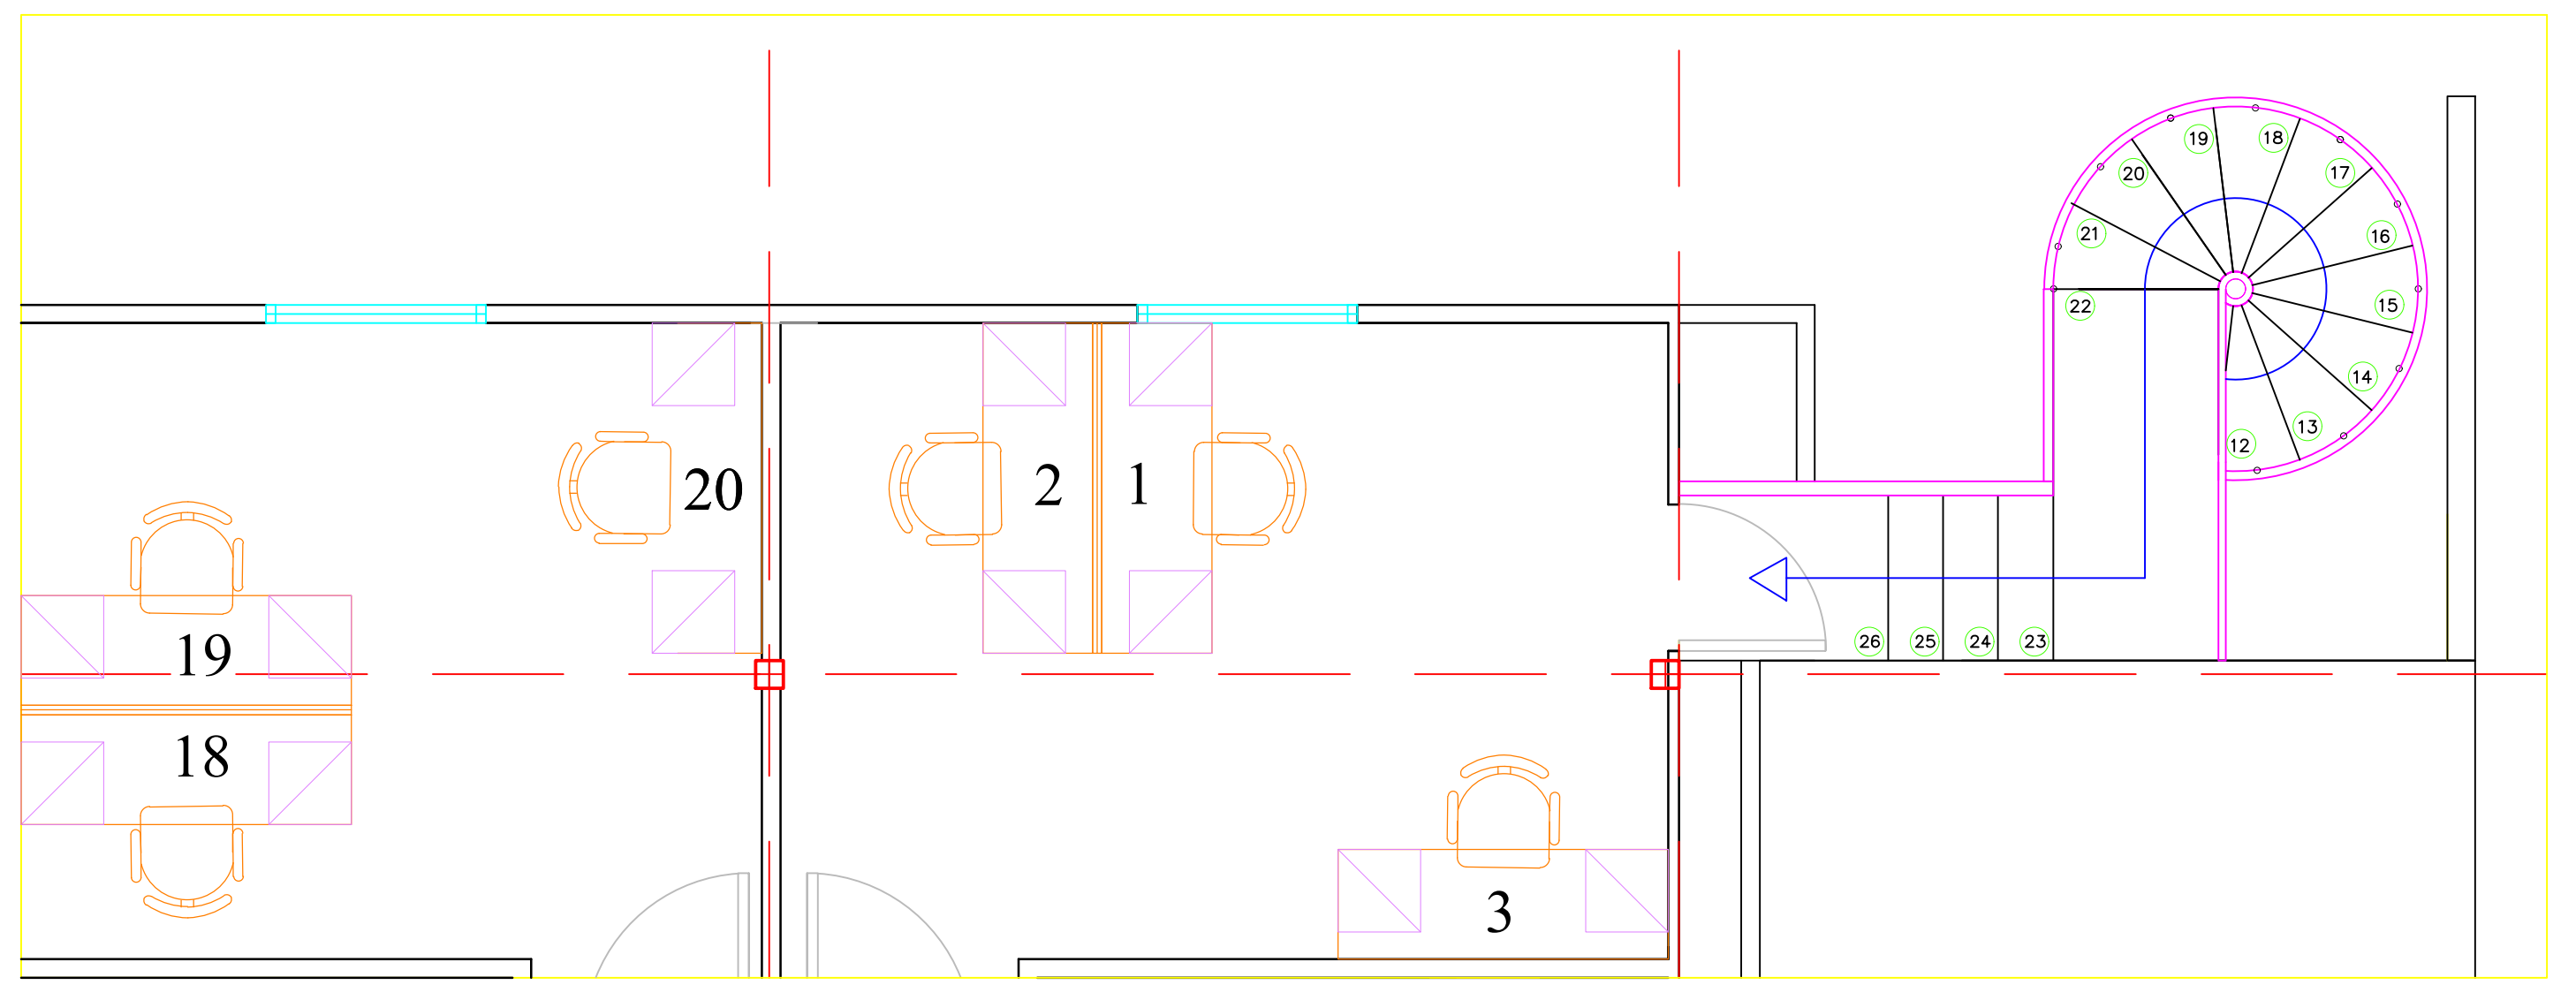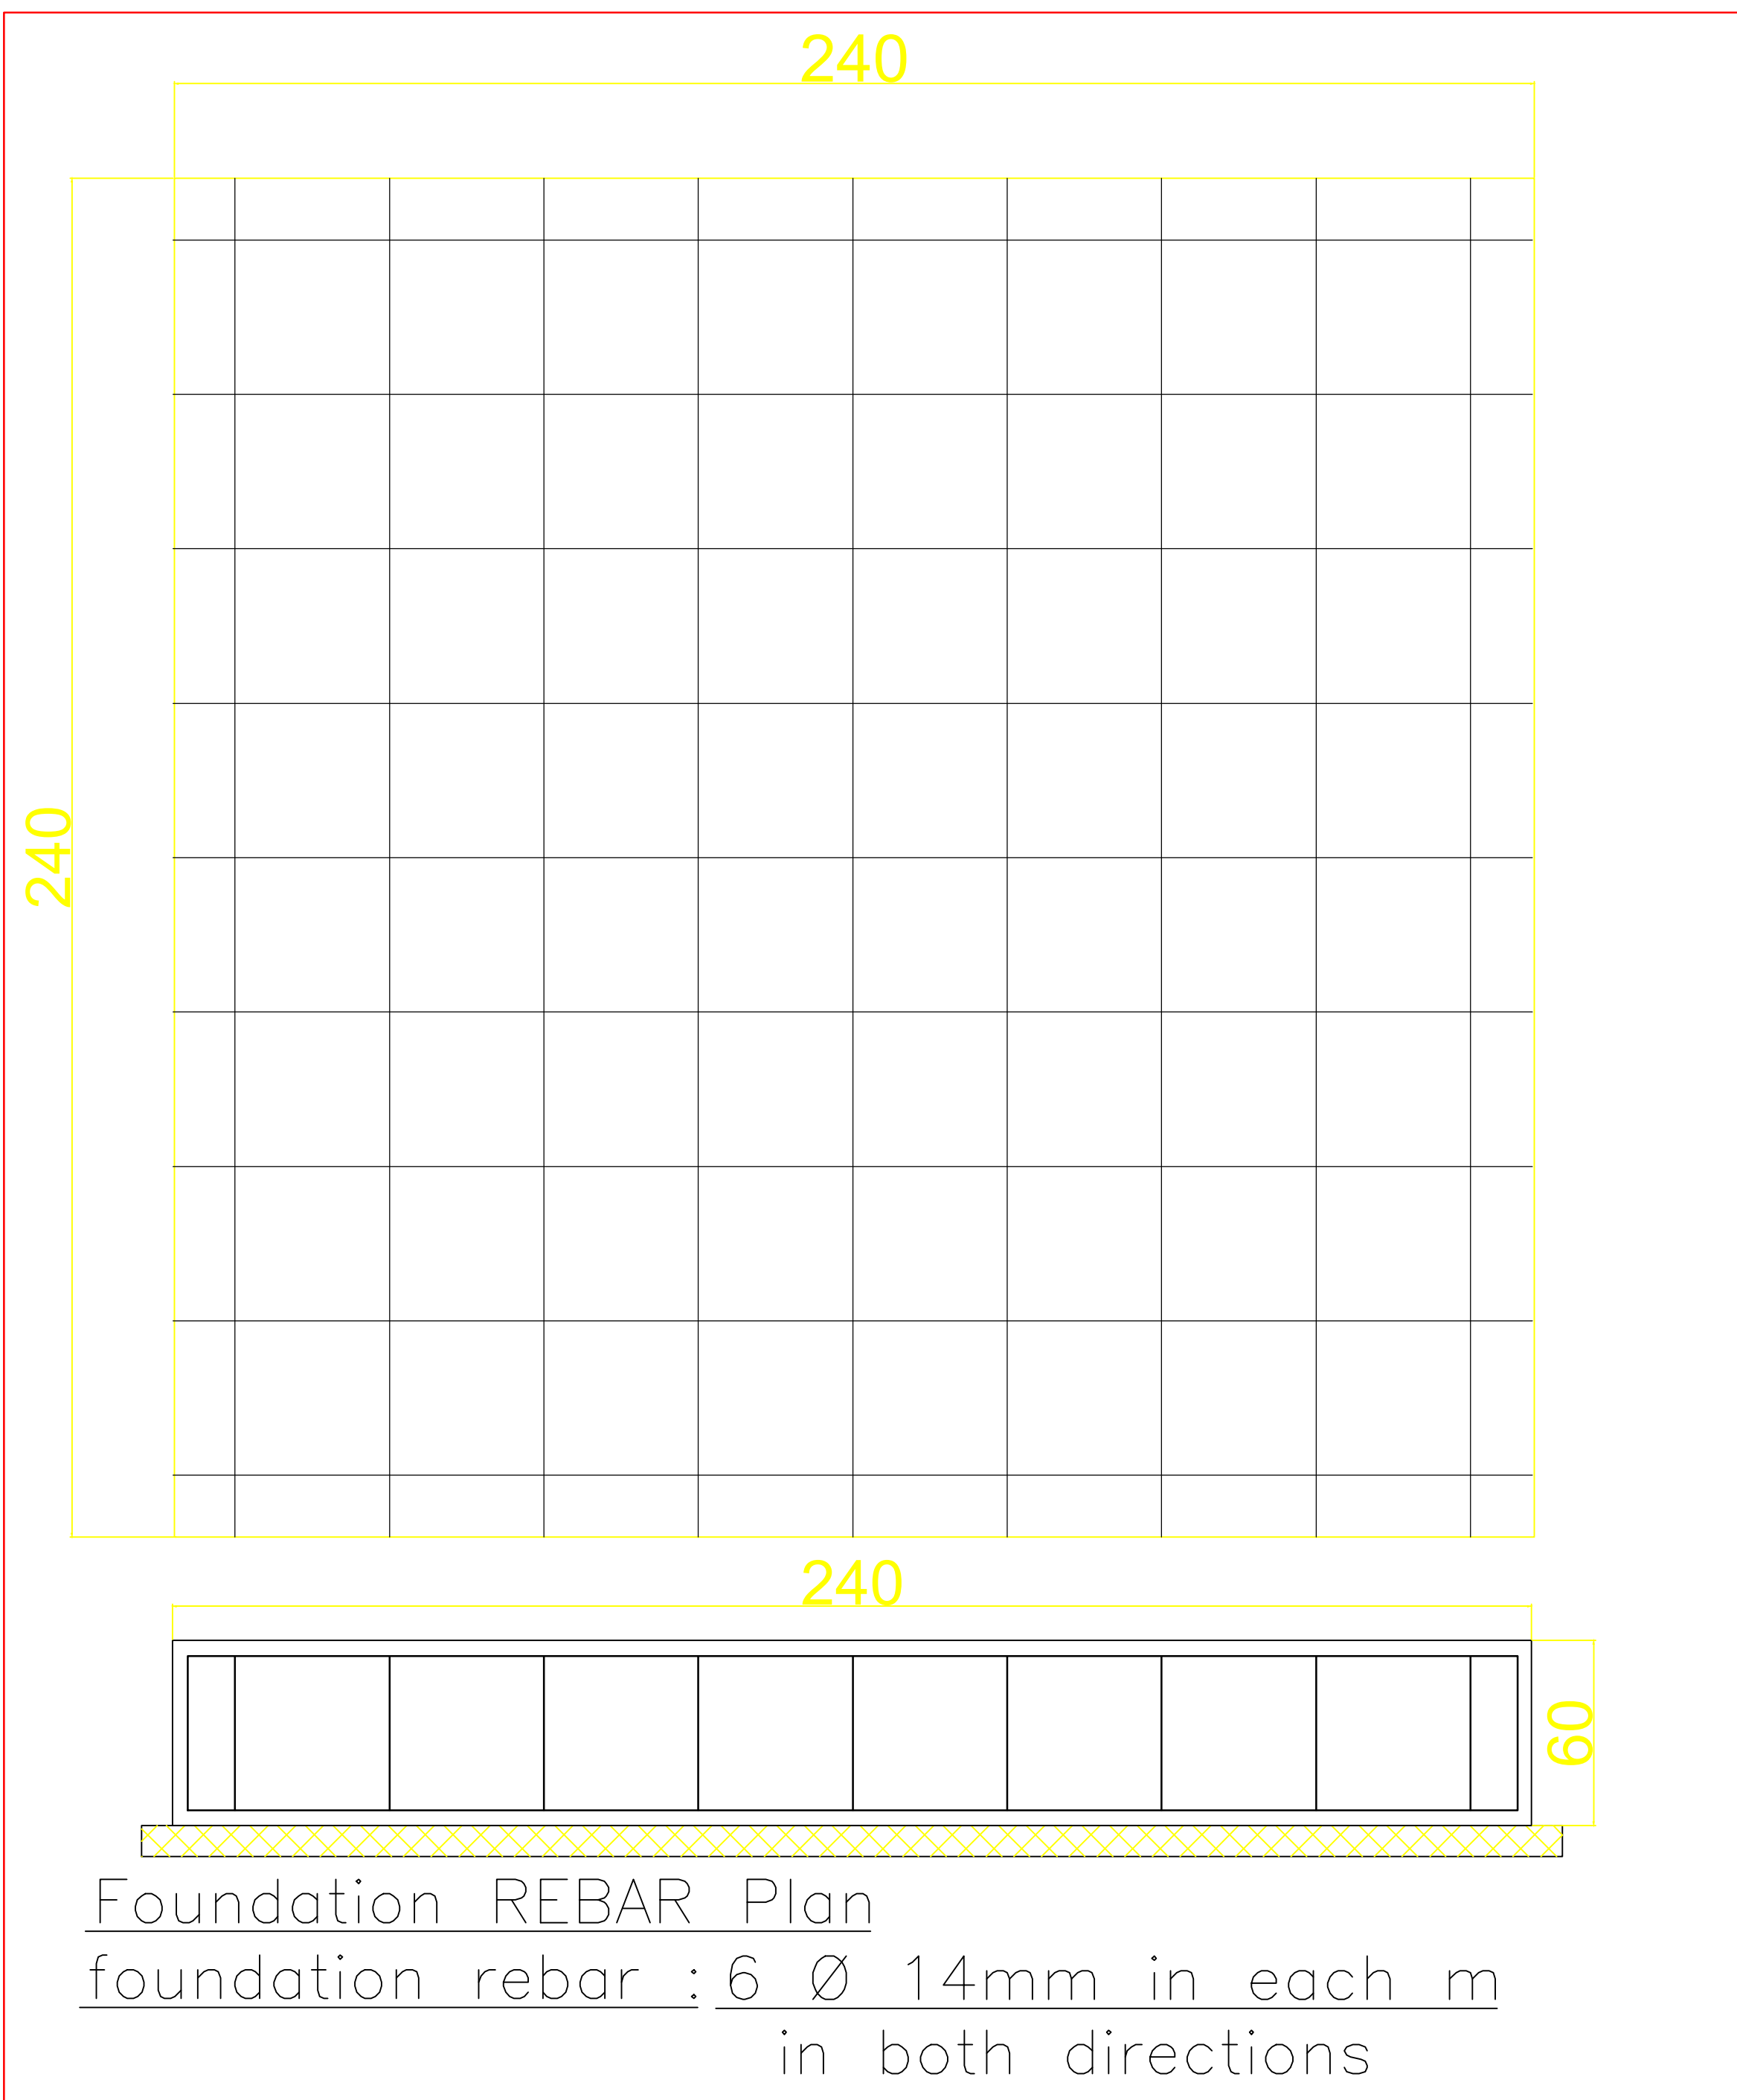

Emergency Stairs - phase 1

Detail A : Perspective

LED down light 18 w	
LED down light 12 w	
Pole light 3m with LED light	
LED light 120cm with reflector	
LED Mirror light 12 w	
one way one gang switch	
one way two gang switch	
Two way one gang switch	
Push Button	
Single socket	
Double socket	
1 Ton A/c	
1.5 Ton A/c	
Pullet camera	
Dome camera	
Smoke detector	
Heat detector	
Sounder	
Automatic Fire extinguisher	
Fire extinguisher	
Break glass	
TV Outlet	
Telephone Outlet	
Data Outlet	






Eng. Khaled Al Jammal
 project manager
 E-mail: khjammal@hotmail.com
 Damascus , Syria

Proposal : 1st floor plan
 scale : to fit
 Project Name
 UNFPA new floor in Damascus

Sheet Size
 A3

Date : 27/8/2018

4mm Steel Plate

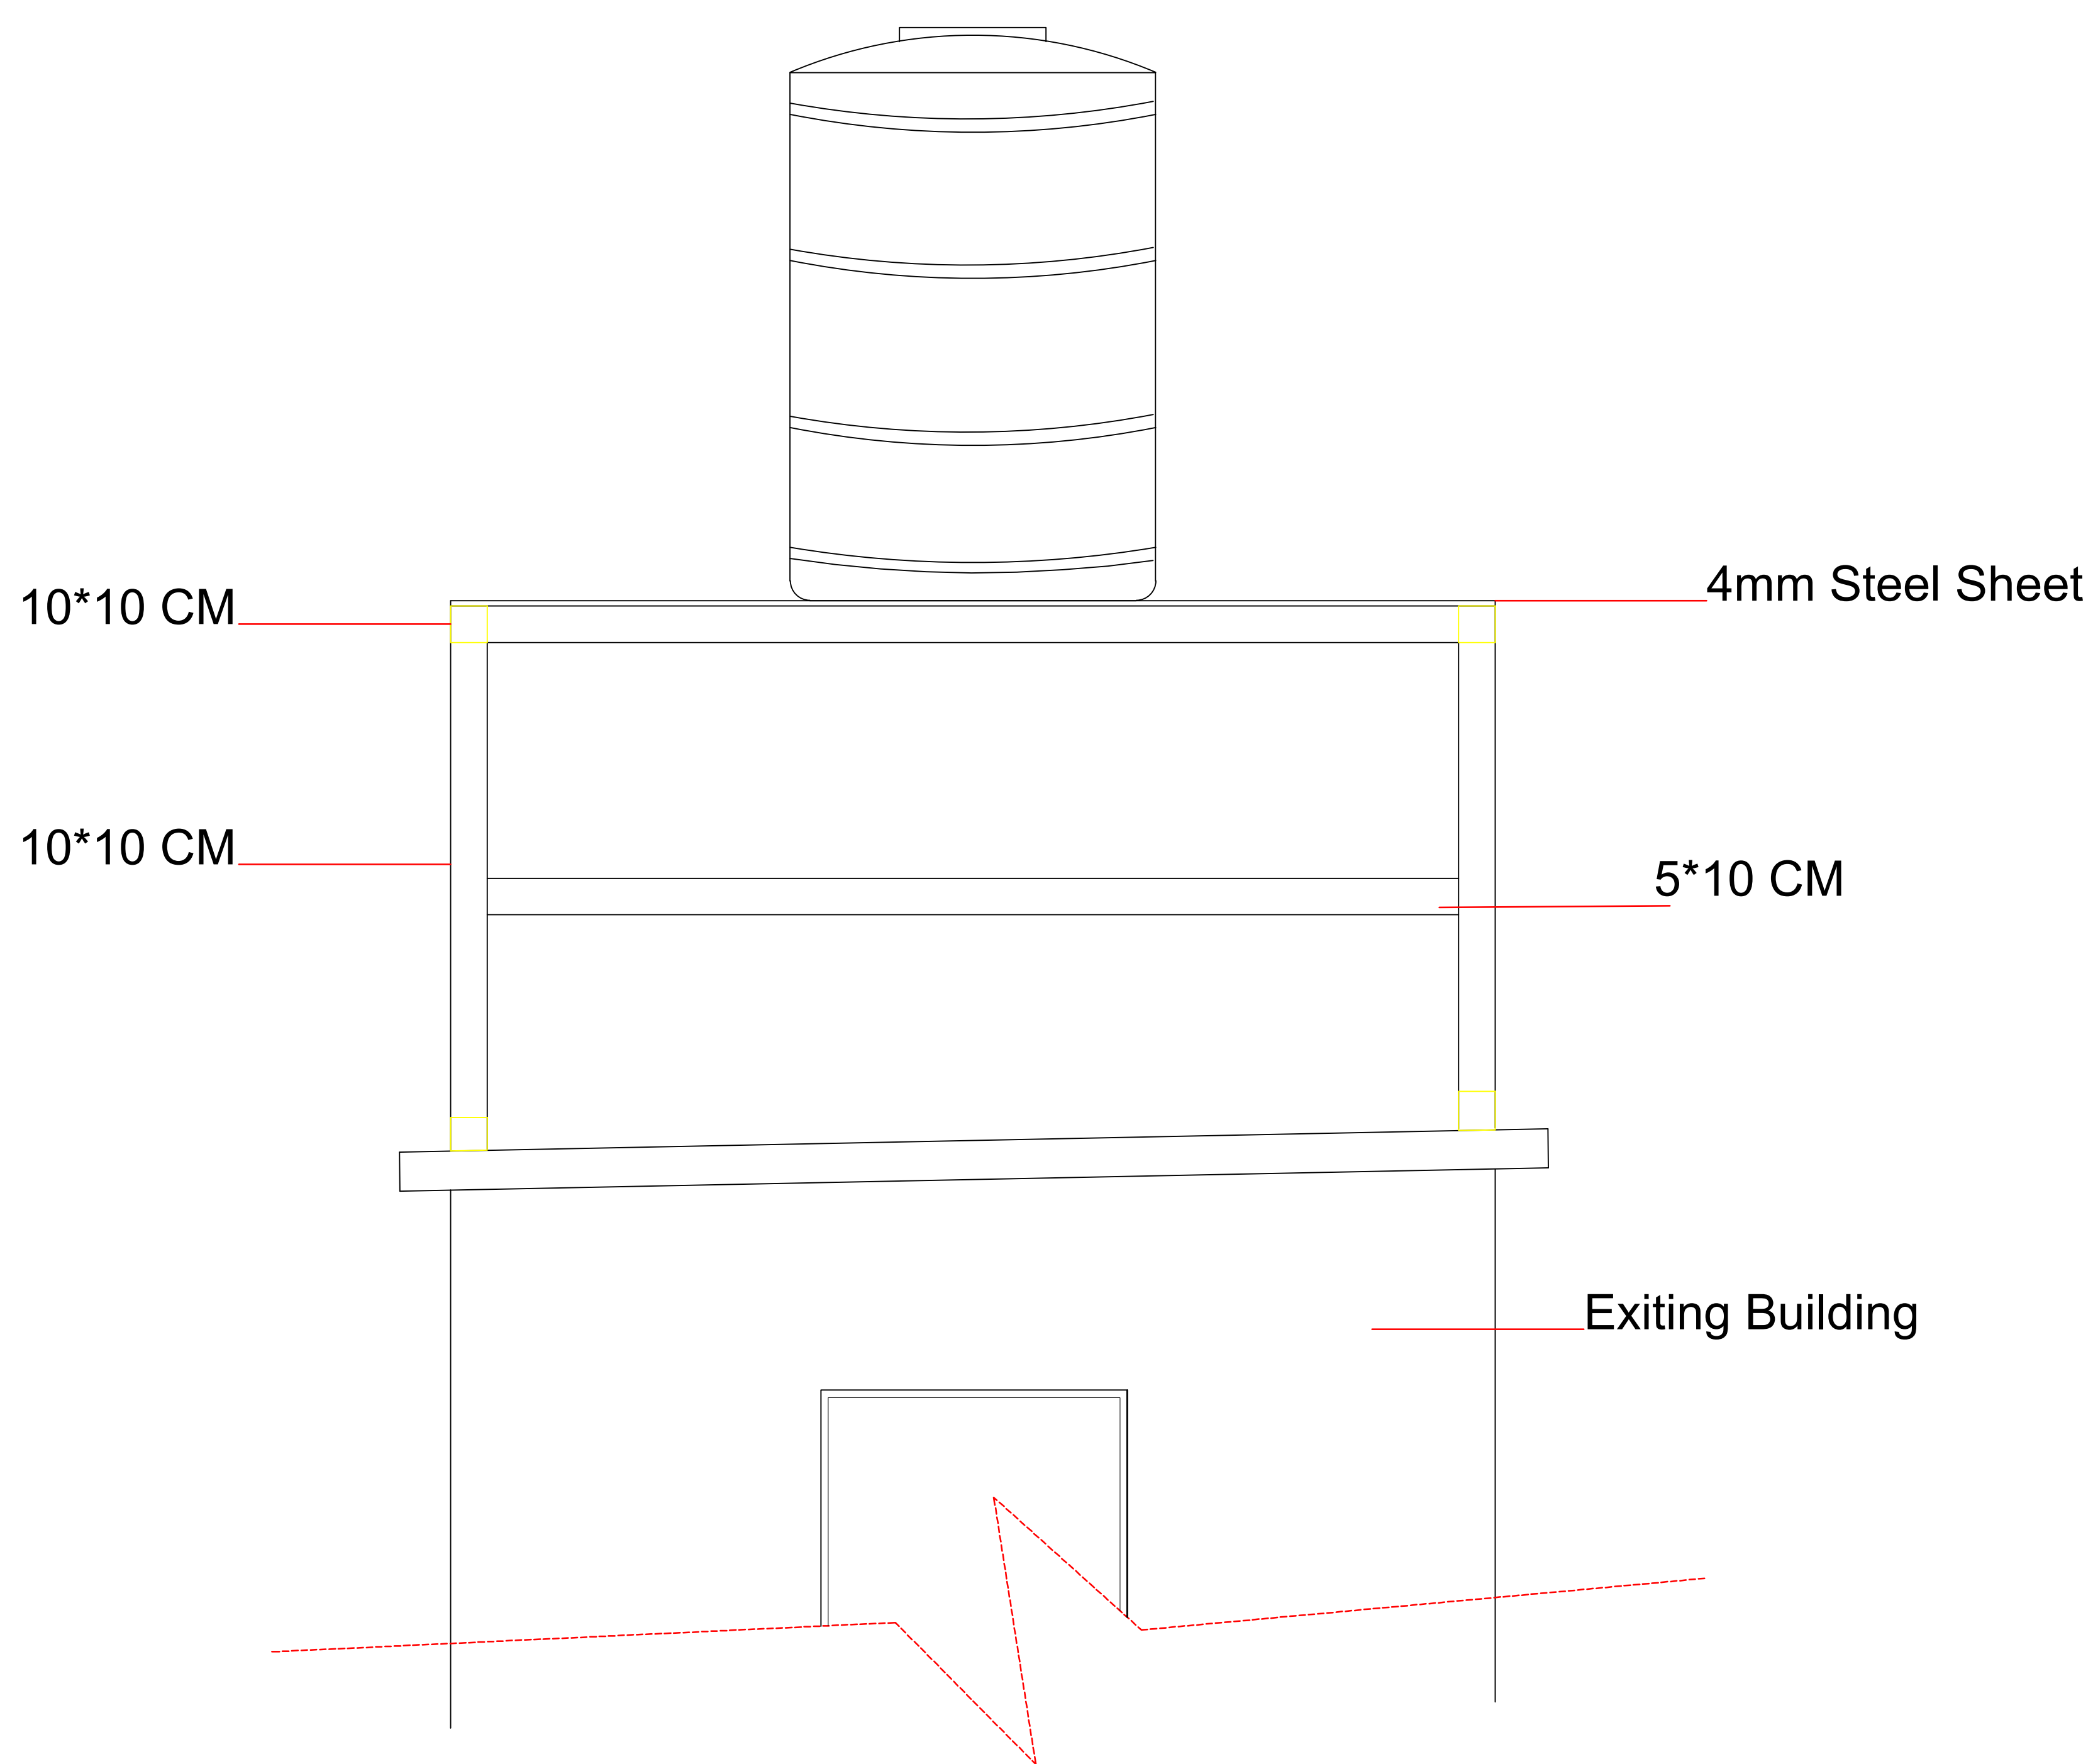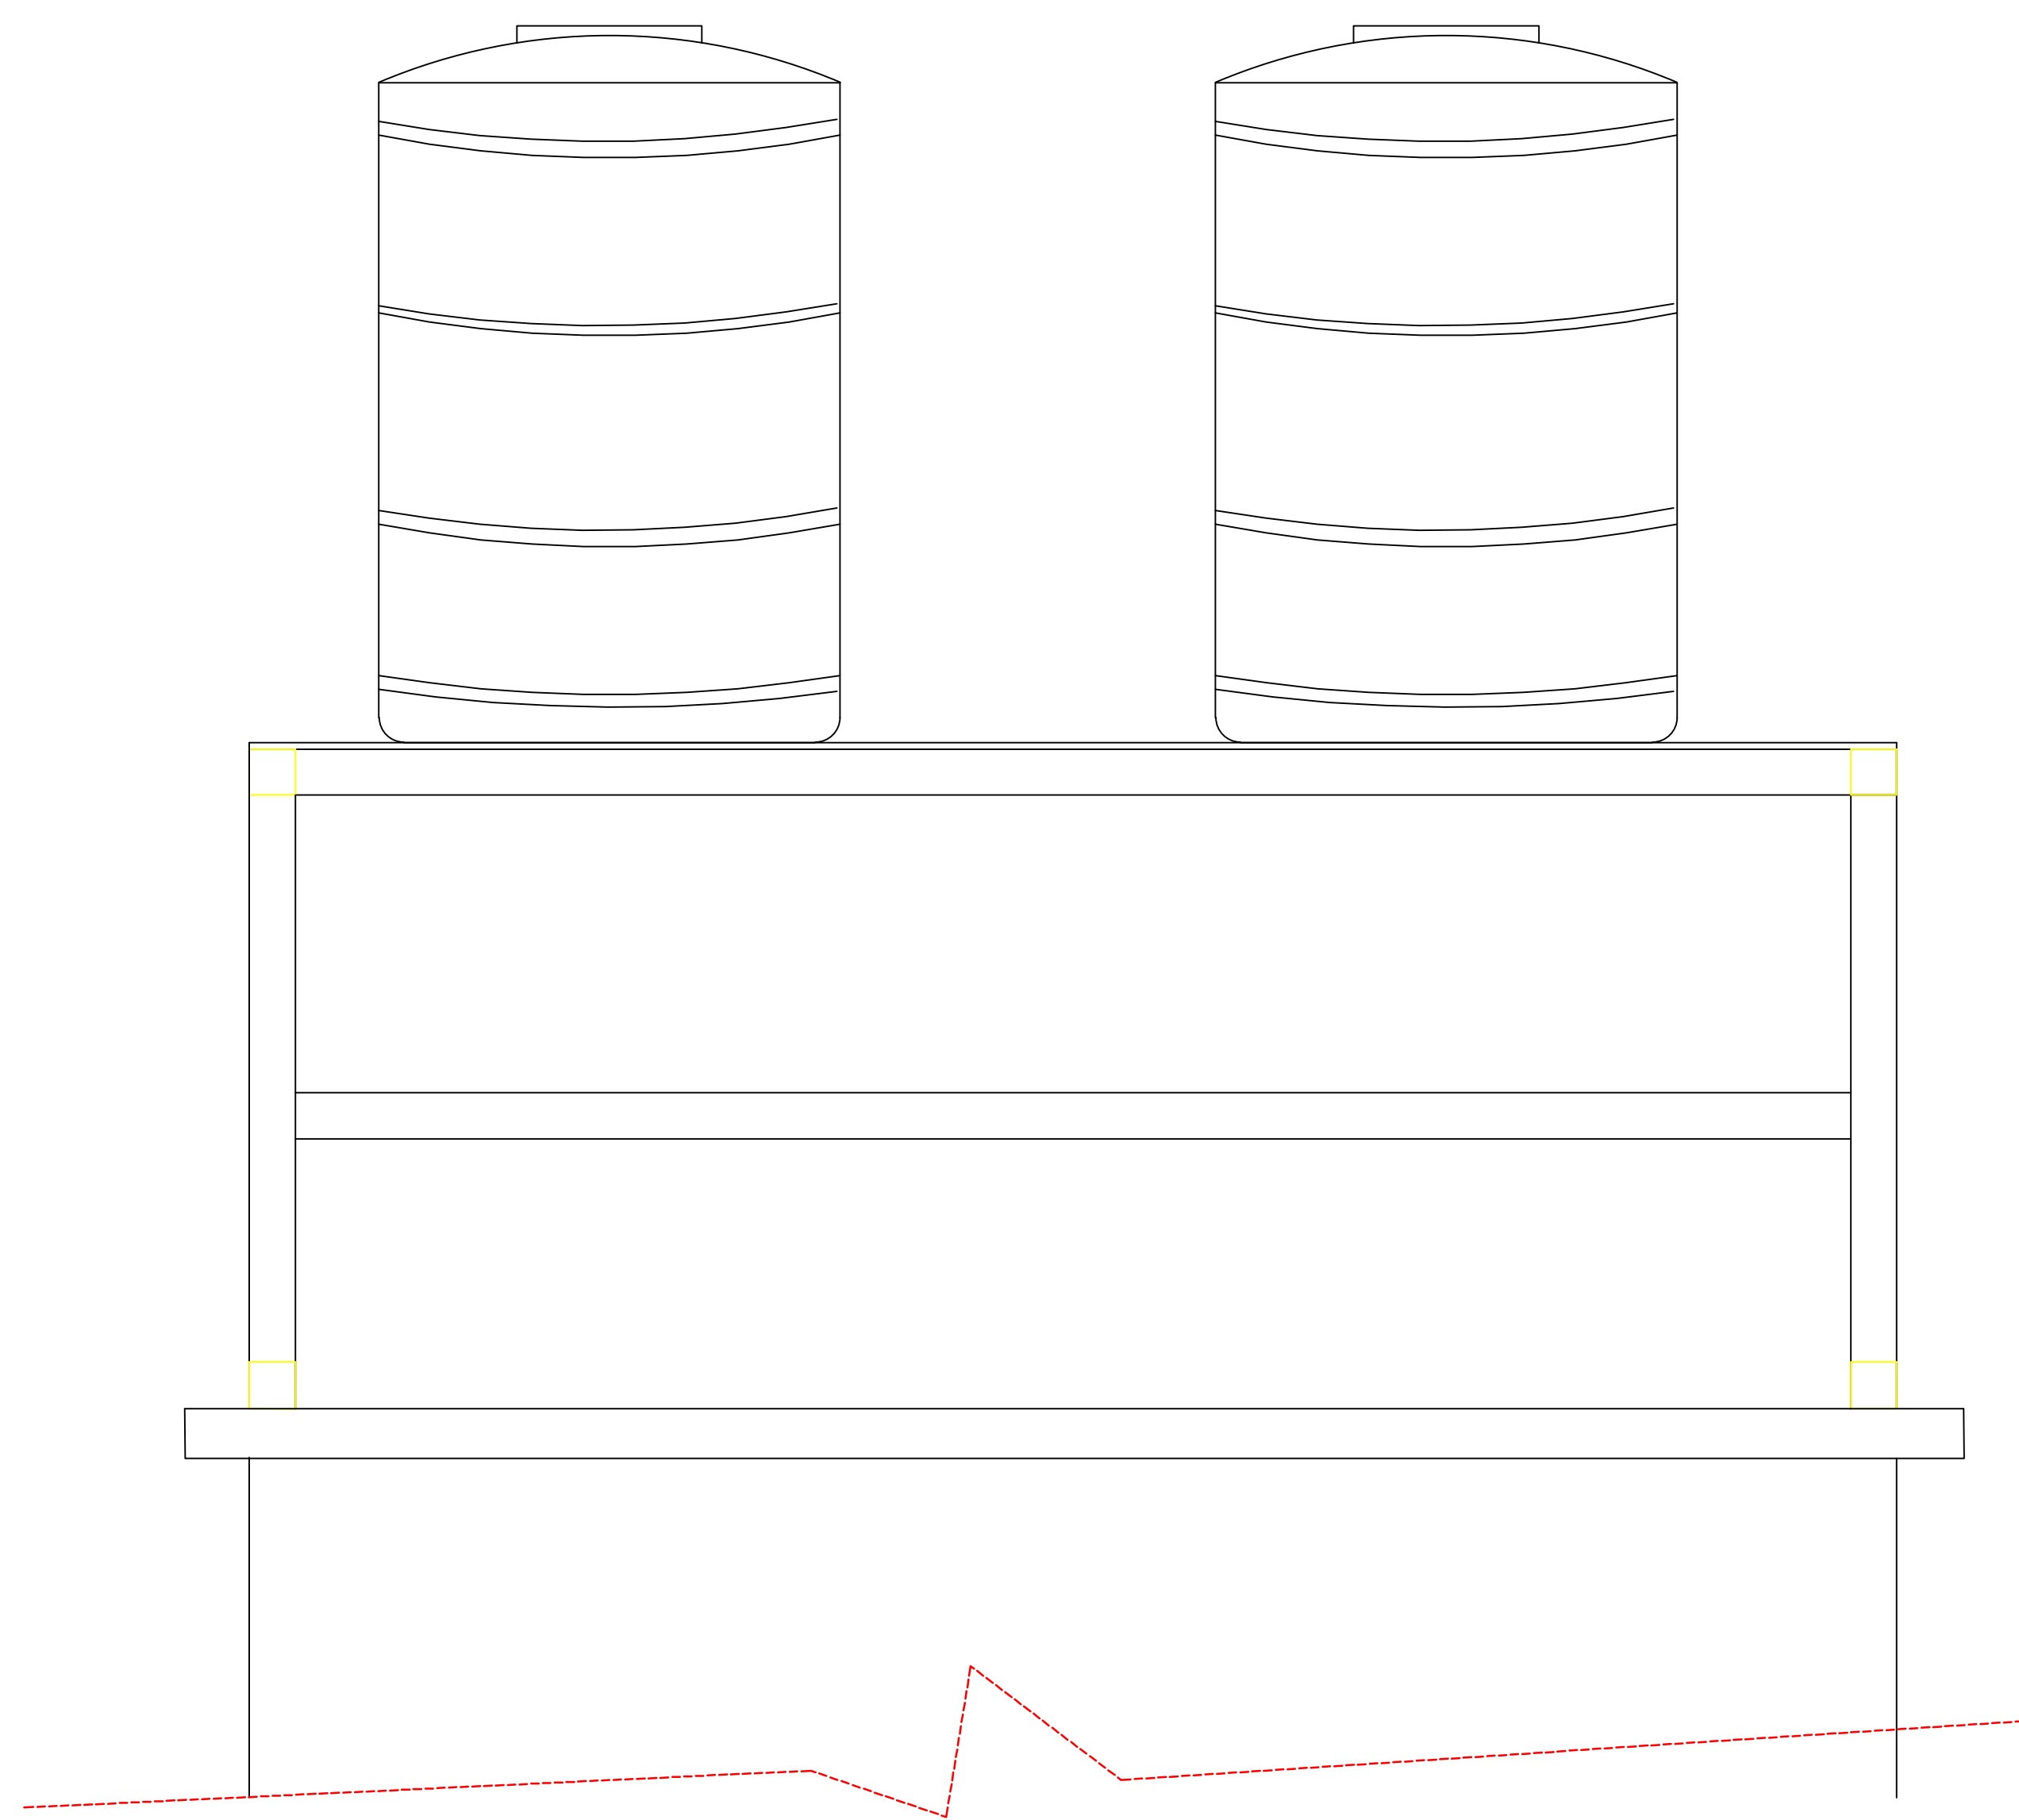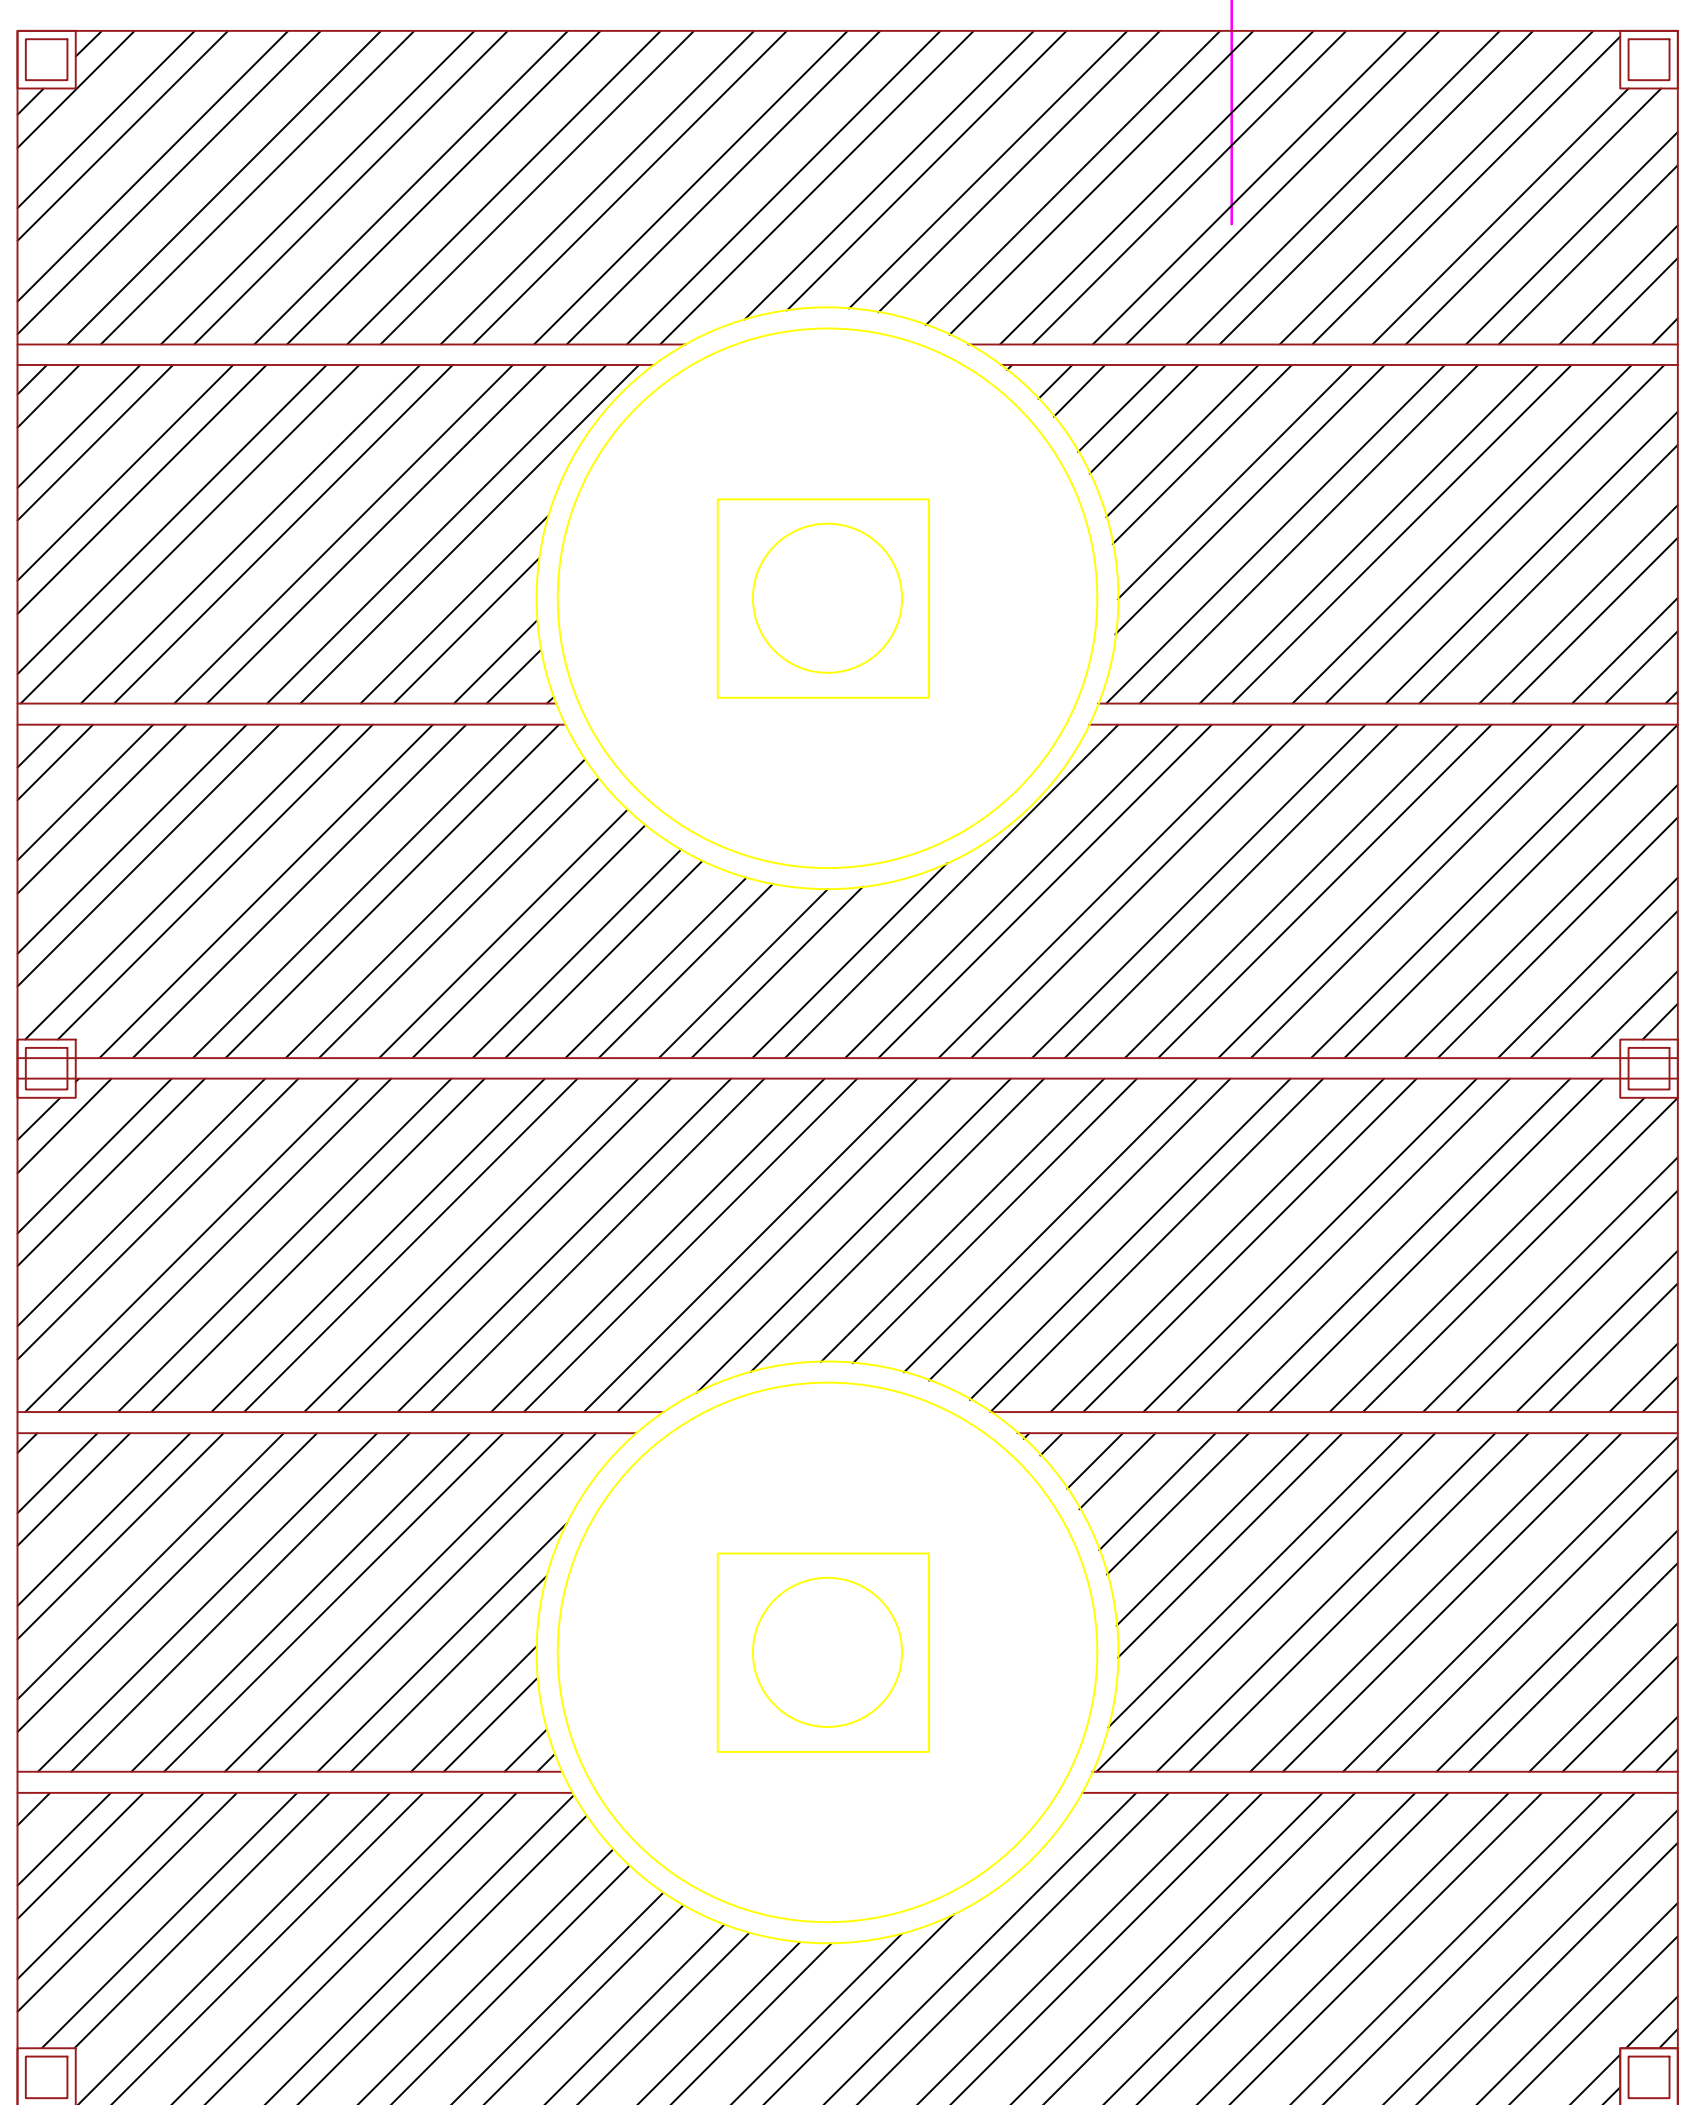

Water Tanks Platform- phase1

LED down light 18 w	
LED down light 12 w	
Pole light 3m with LED light	
LED light 120cm with reflector	
LED Mirror light 12 w	
one way one gang switch	
one way two gang switch	
Two way one gang switch	
Push Button	
Single socket	
Double socket	
1 Ton A/c	
1.5 Ton A/c	
Pullet camera	
Dome camera	
Smoke detector	
Heat detector	
Sounder	
Automatic Fire extinguisher	
Fire extinguisher	
Break glass	
TV Outlet	
Telephone Outlet	
Data Outlet	



Eng. Khaled Al Jammal
project manager




E-mail: khjammal@hotmail.com
Damascus , Syria

Proposal : 1st floor plan
scale : to fit

Project Name
UNFPA new floor in Damascus

Sheet Size
A3

Date : 27/8/2018

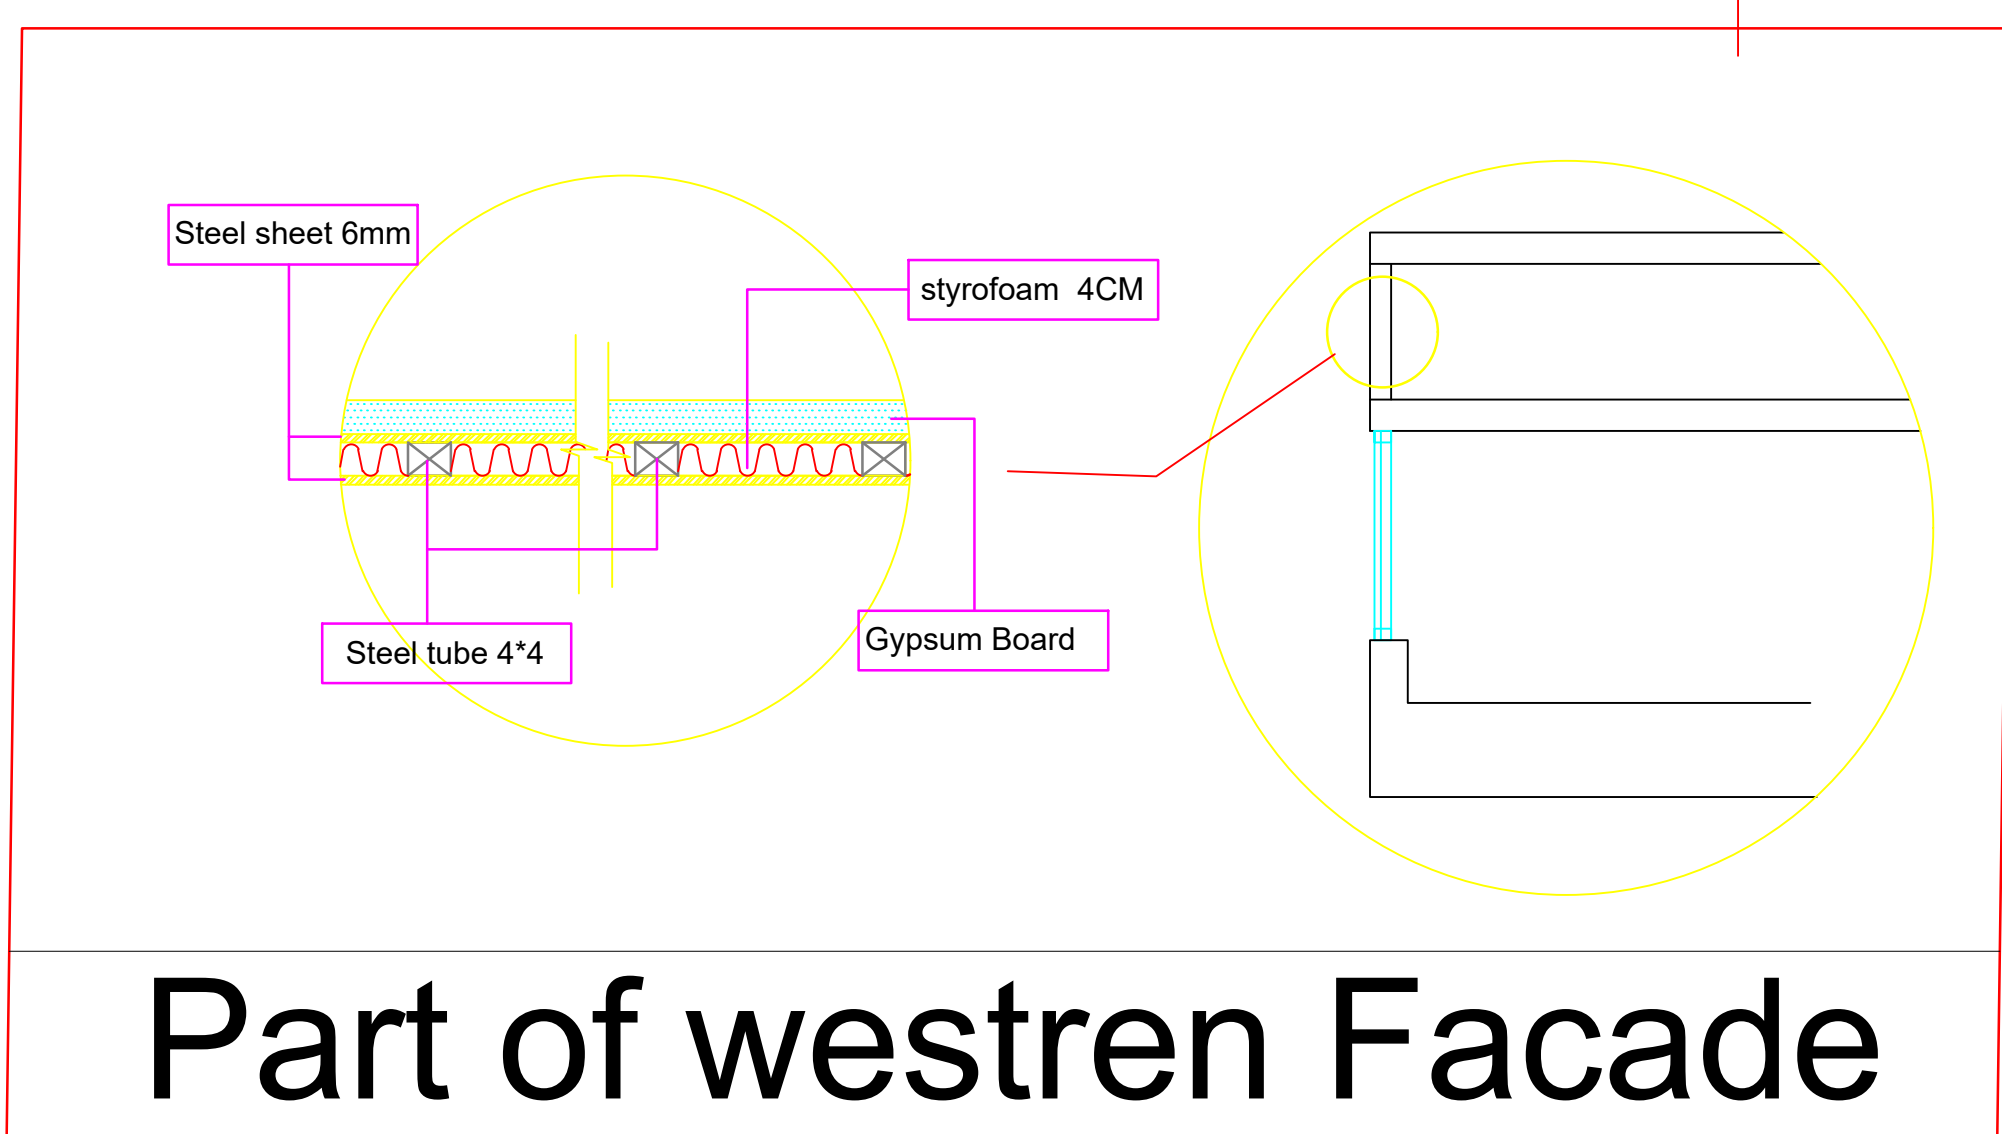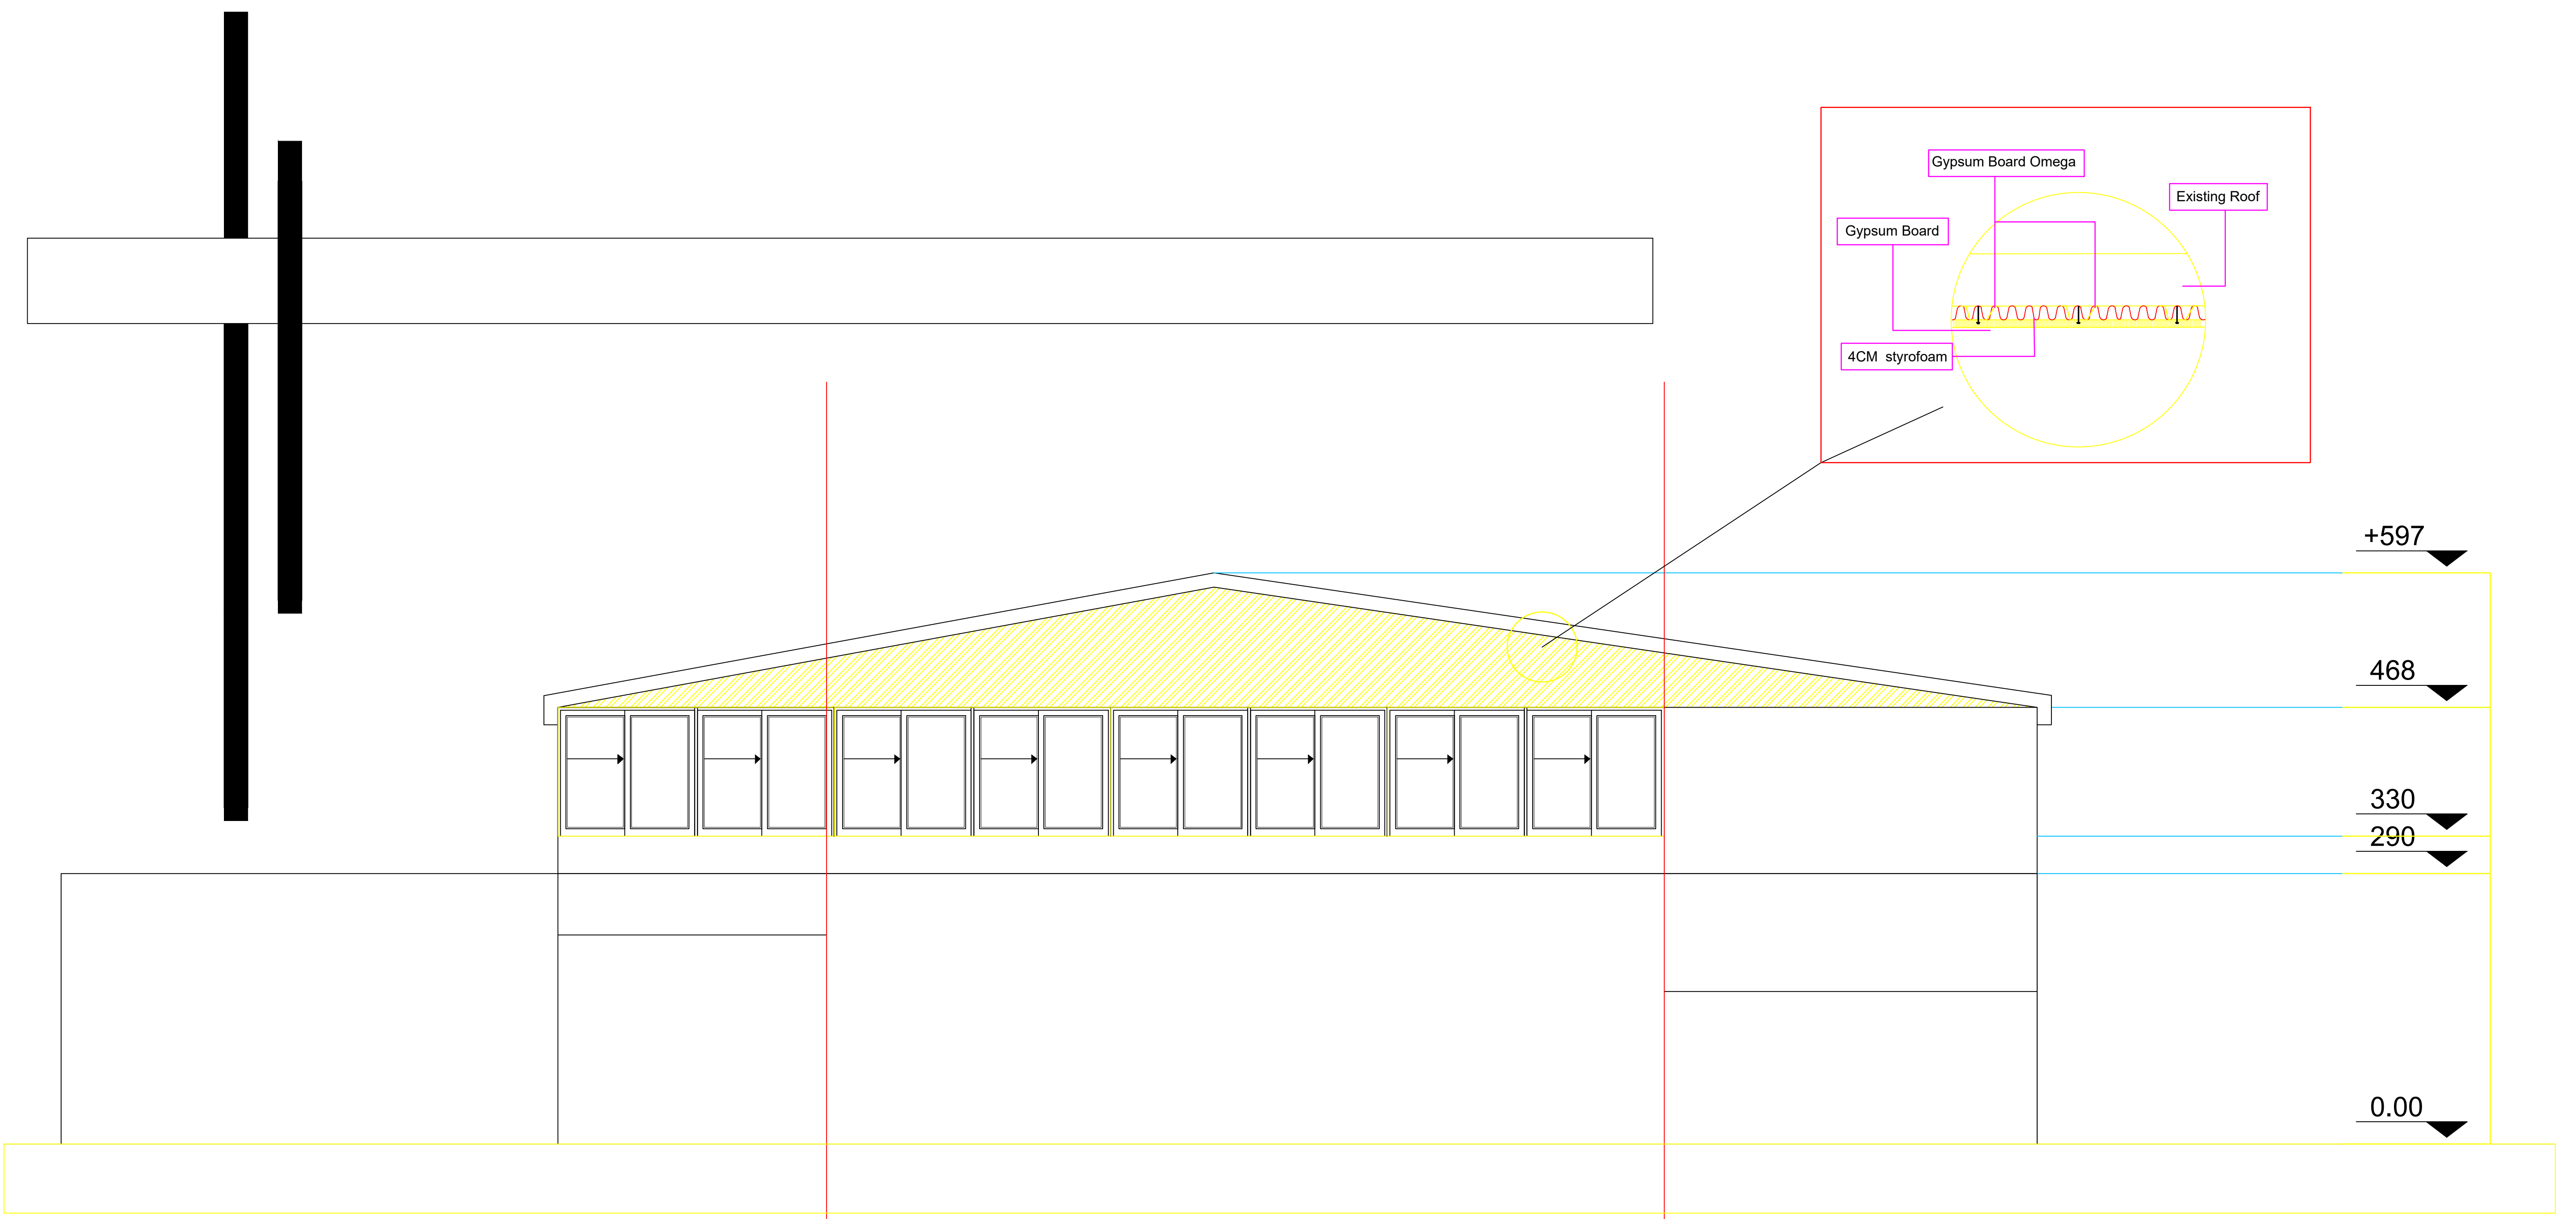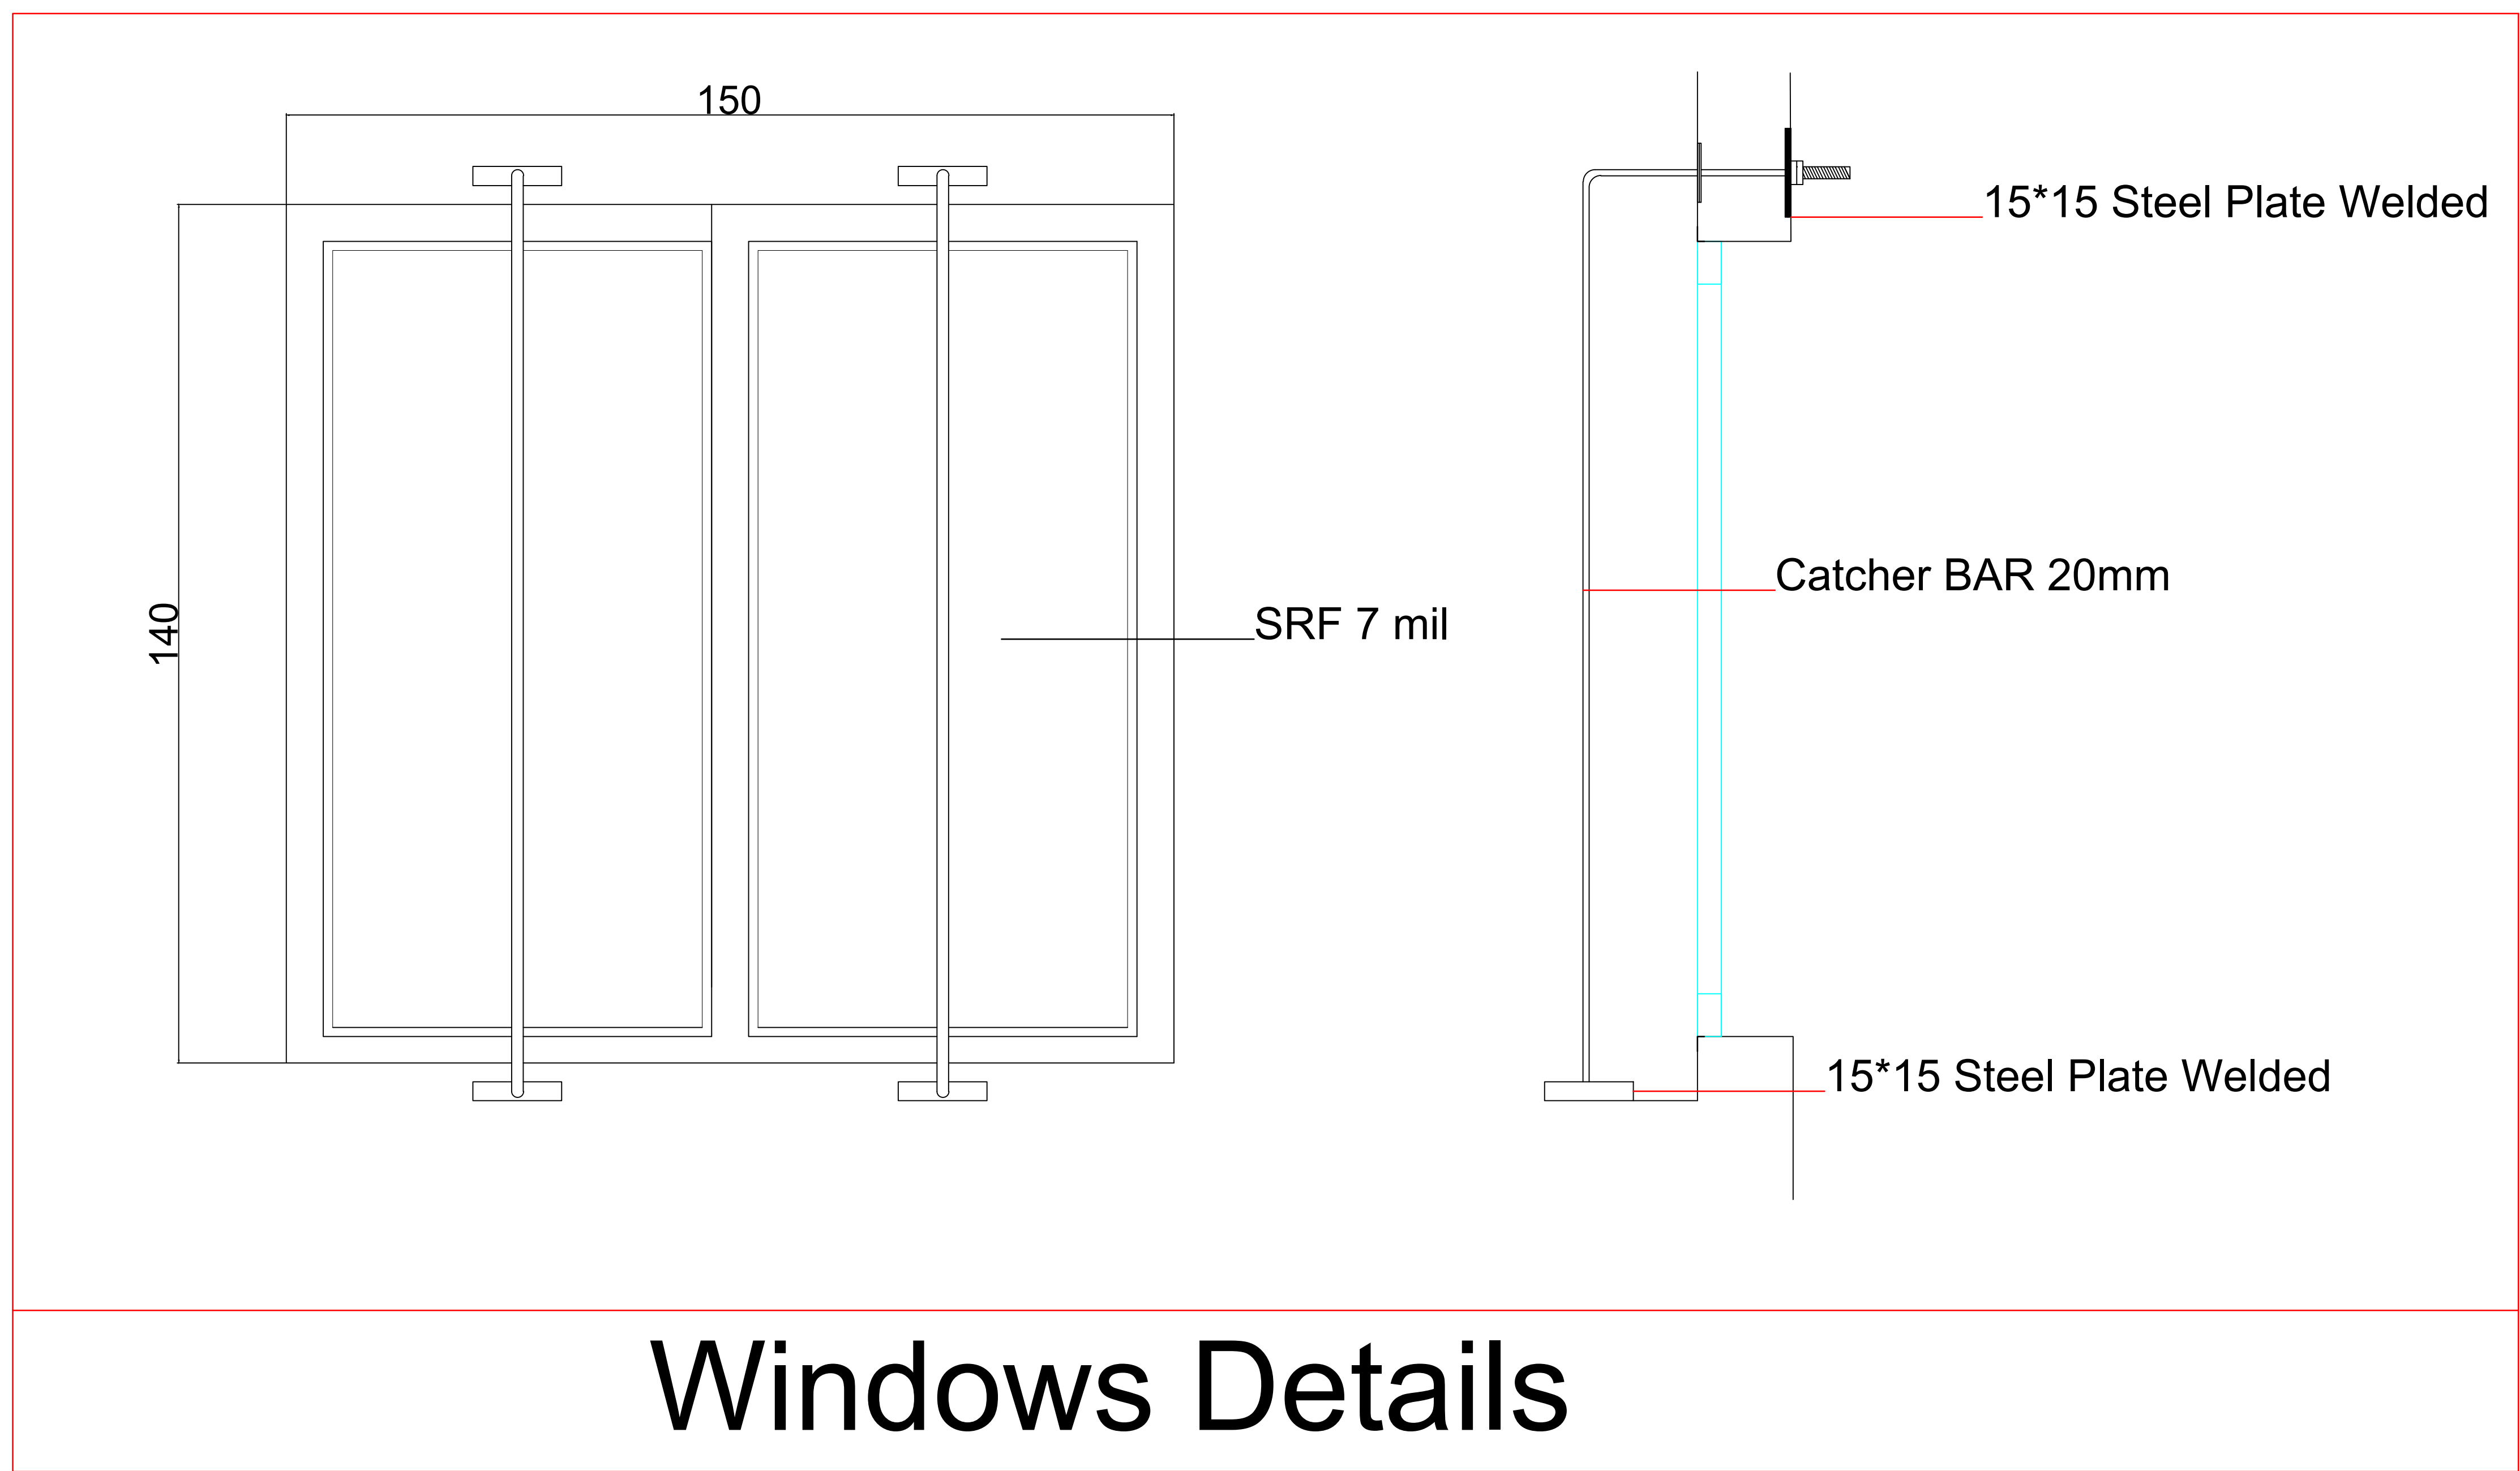

Elevation - phase 1

LED down light 18 w	
LED down light 12 w	
Pole light 3m with LED light	
LED light 120cm with reflector	
LED Mirror light 12 w	
one way one gang switch	
one way two gang switch	
Two way one gang switch	
Push Button	
Single socket	
Double socket	
1 Ton A/c	
1.5 Ton A/c	
Pullet camera	
Dome camera	
Smoke detector	
Heat detector	
Sounder	
Automatic Fire extinguisher	
Fire extinguisher	
Break glass	
TV Outlet	
Telephone Outlet	
Data Outlet	



Eng. Khaled Al Jammal
project manager



E-mail: khjammal@hotmail.com
Damascus , Syria

Proposal : 1st floor plan
scale : to fit


Project Name
UNFPA new floor in Damascus

Sheet Size
A3


Date : 27/8/2018

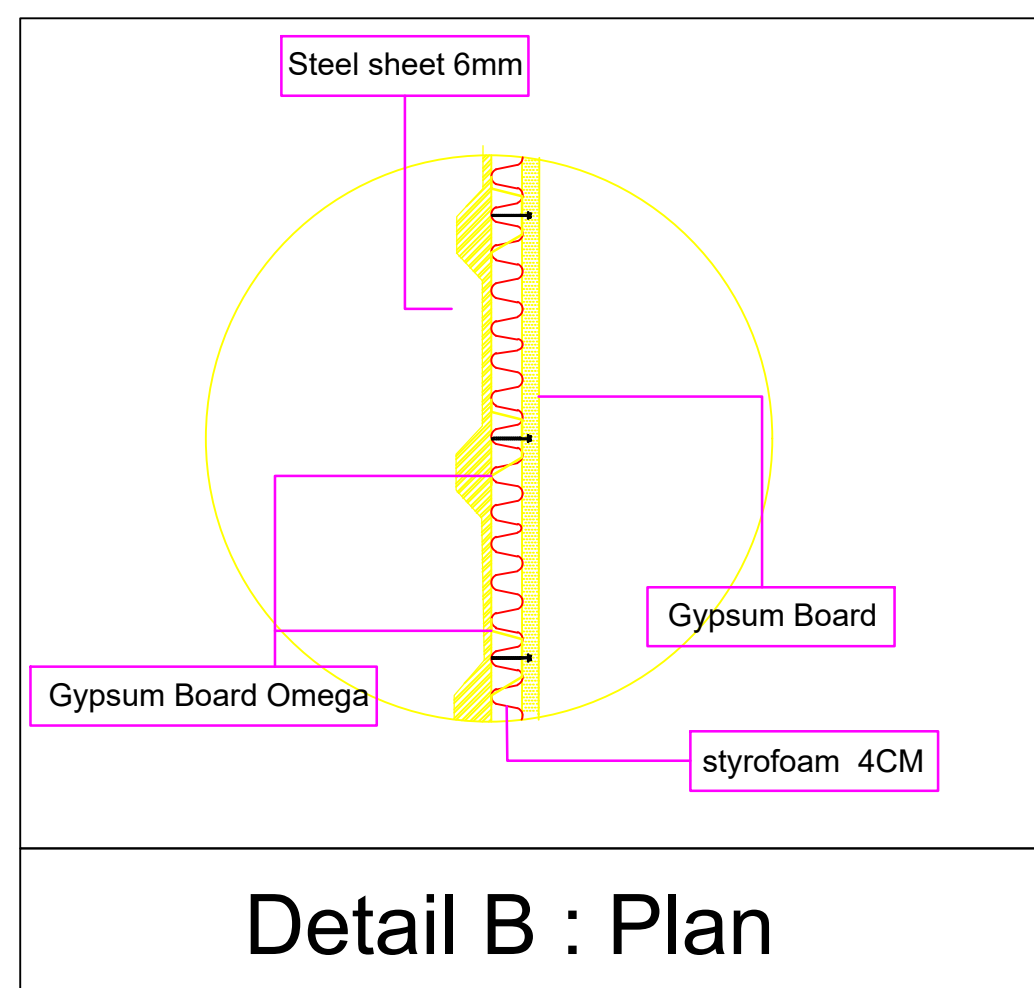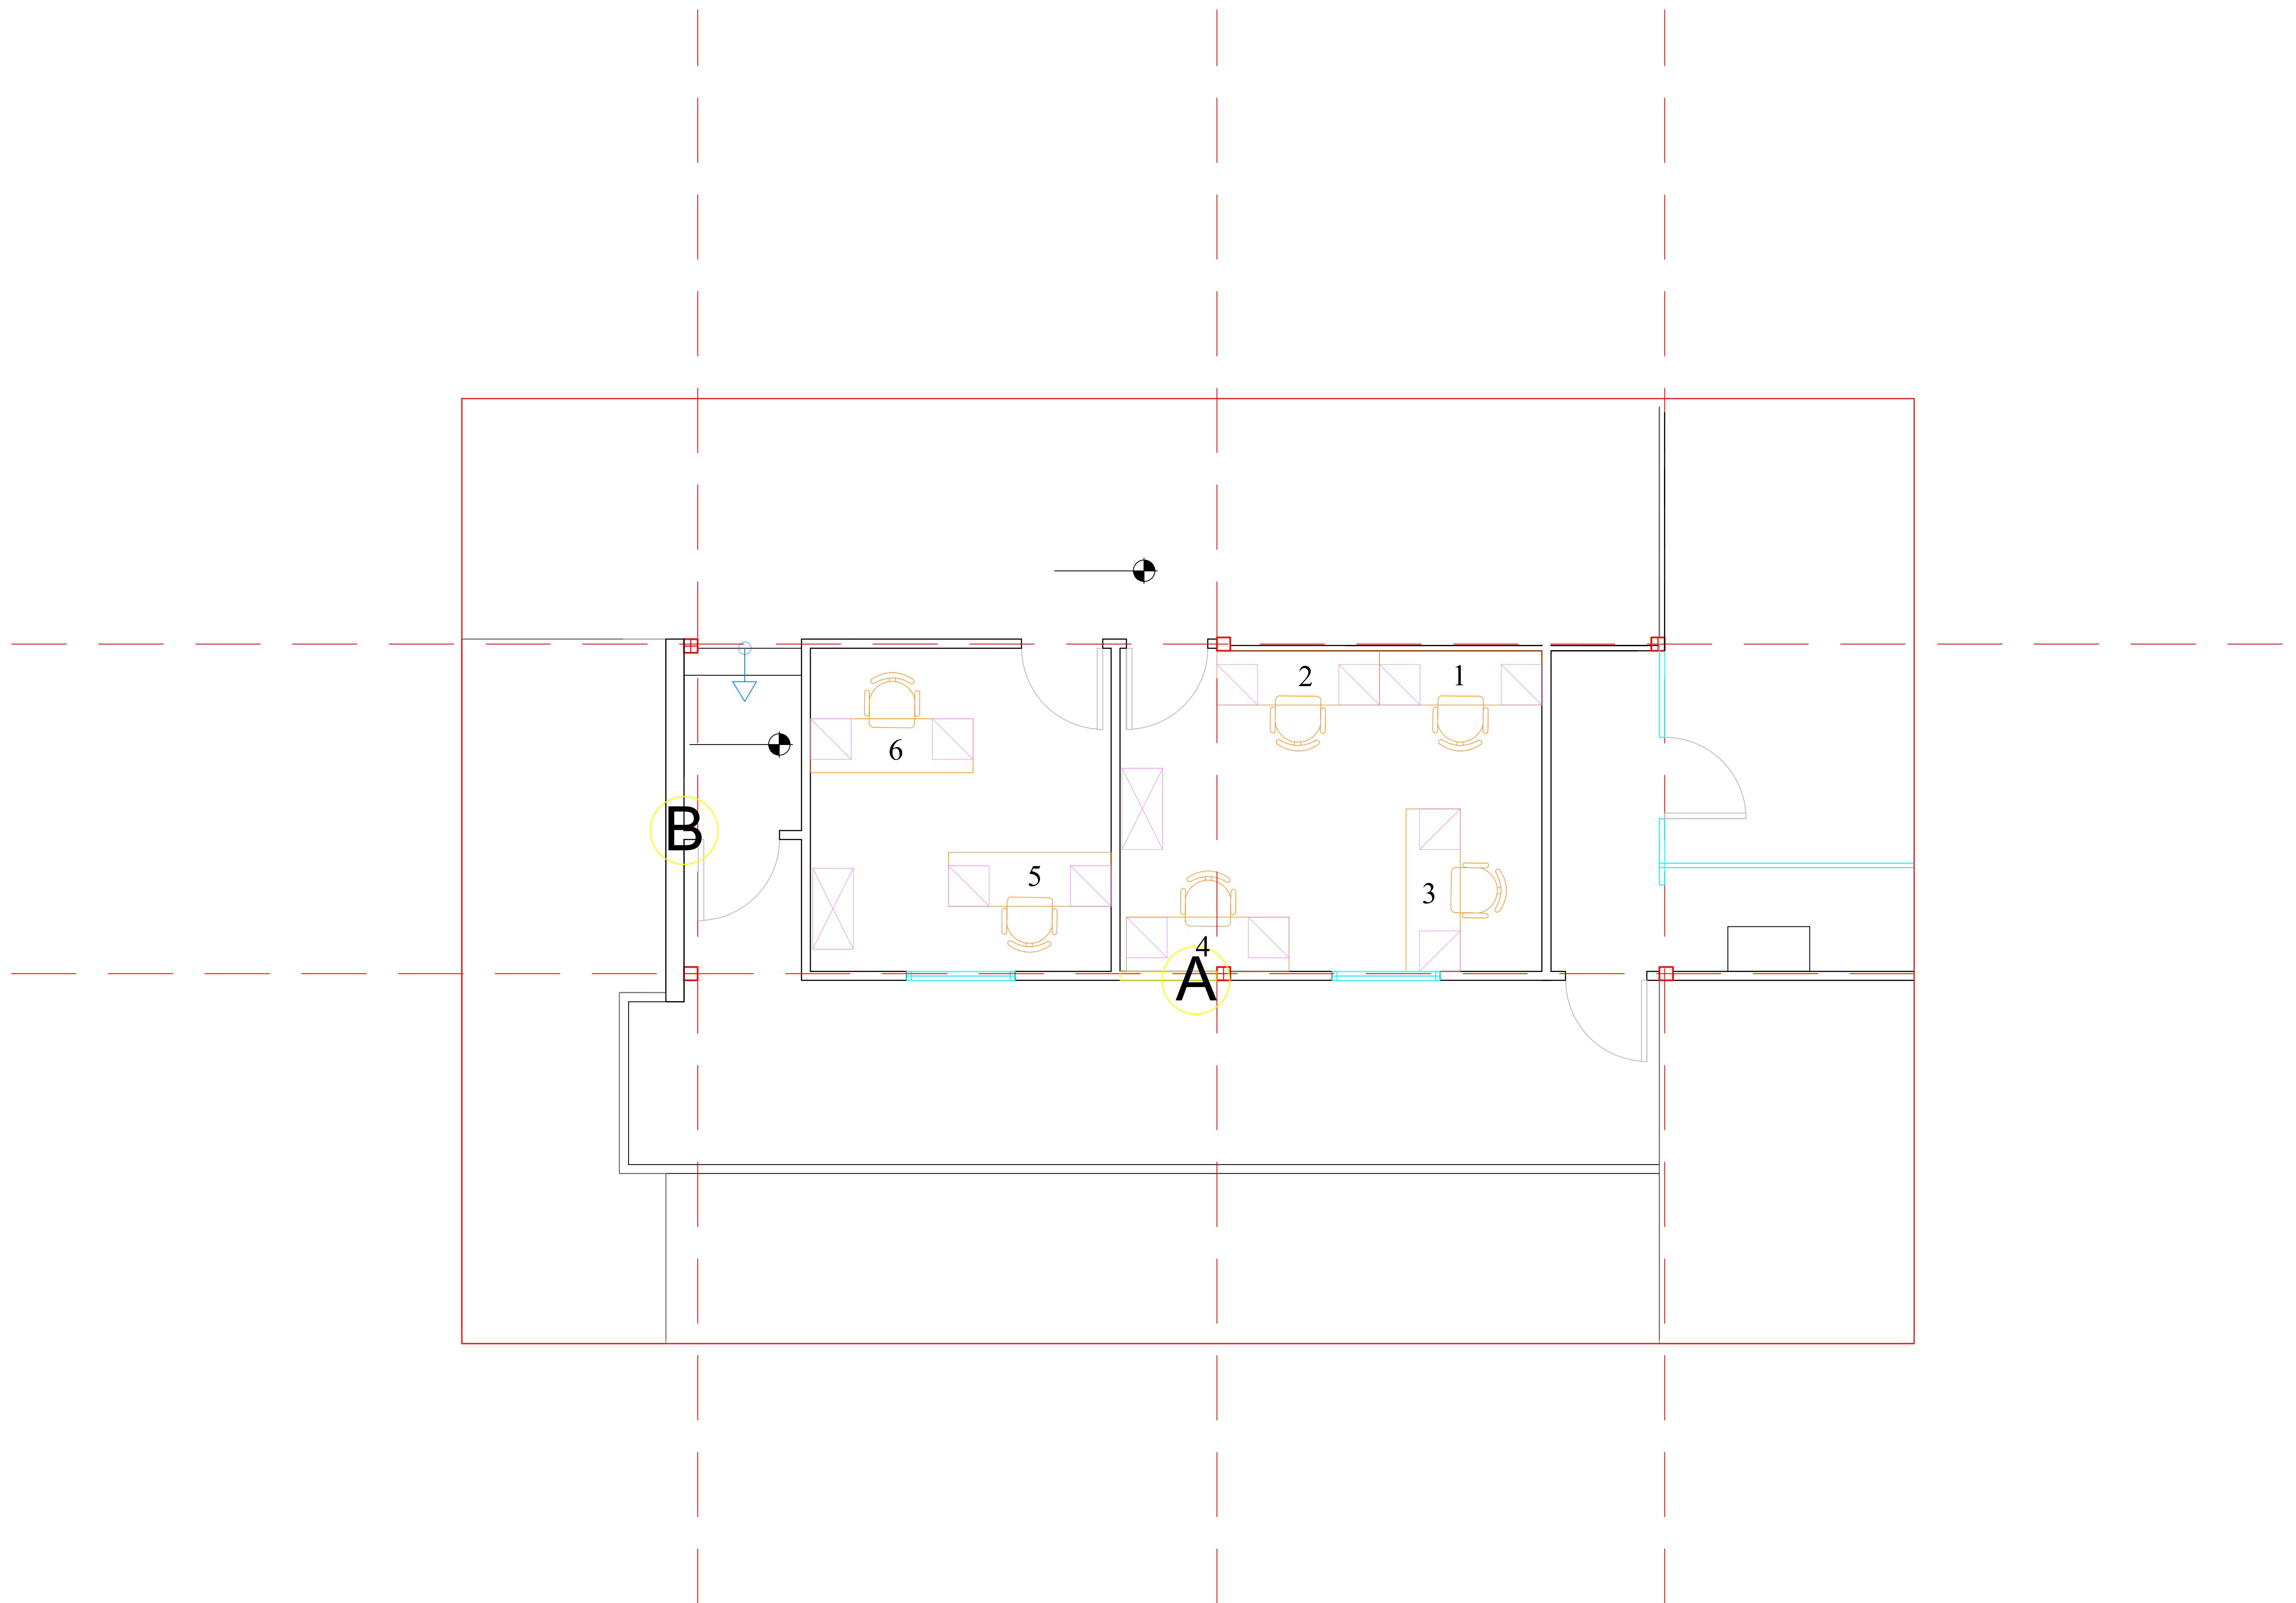

Detail B : Plan

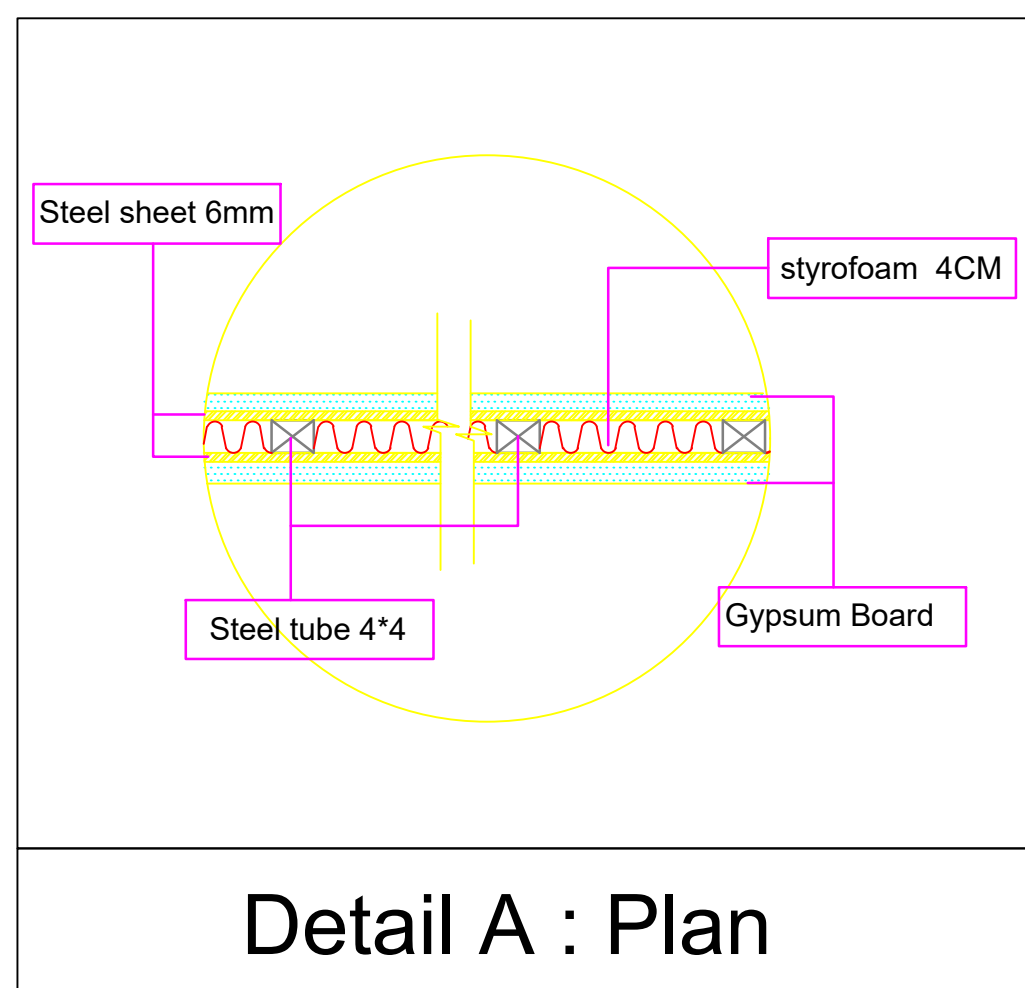

Detail A : Plan

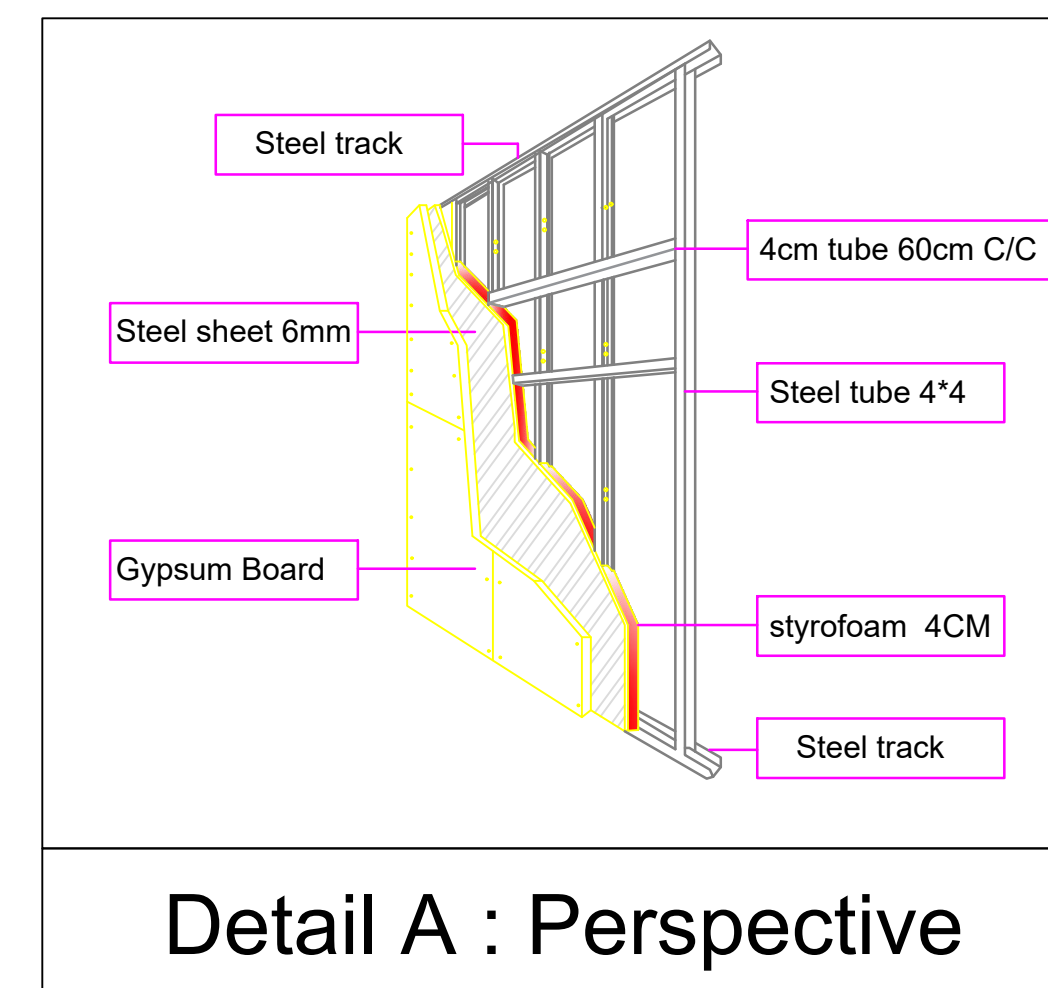

Detail A : Perspective

Details - phase1

LED down light 18 w	
LED down light 12 w	
Pole light 3m with LED light	
LED light 120cm with reflector	
LED Mirror light 12 w	
one way one gang switch	
one way two gang switch	
Two way one gang switch	
Push Button	
Single socket	
Double socket	
1 Ton A/c	
1.5 Ton A/c	
Pullet camera	
Dome camera	
Smoke detector	
Heat detector	
Sounder	
Automatic Fire extinguisher	
Fire extinguisher	
Break glass	
TV Outlet	
Telephone Outlet	
Data Outlet	



Eng. Khaled Al Jammal
project manager



E-mail: khjammal@hotmail.com
Damascus , Syria

Proposal : 1st floor plan
scale : to fit

Project Name
UNFPA new floor in Damascus

Sheet Size
A3

Date : 27/8/2018

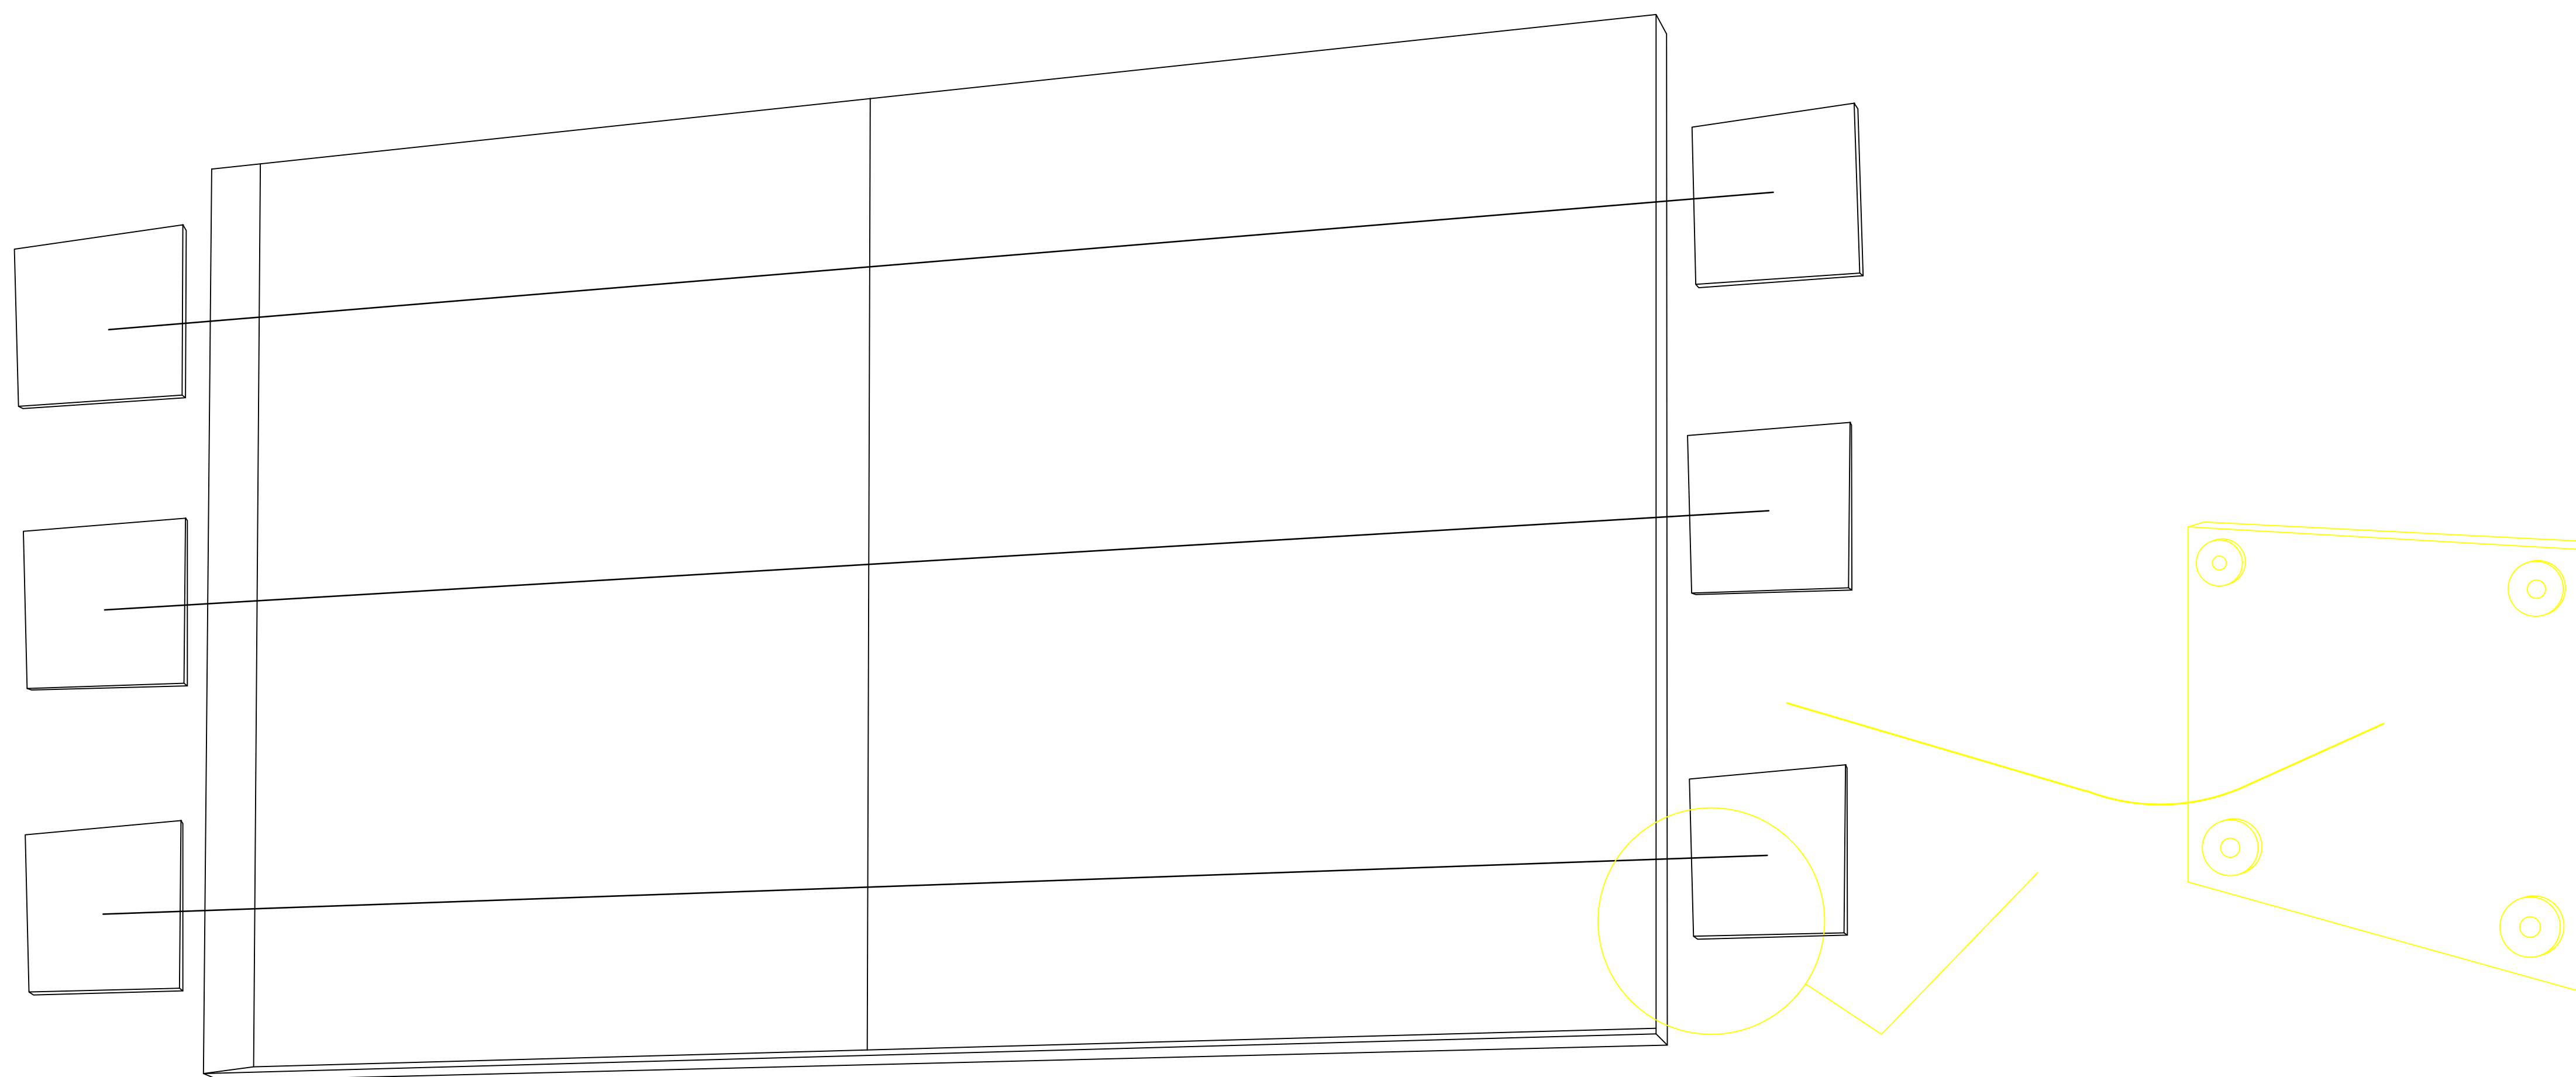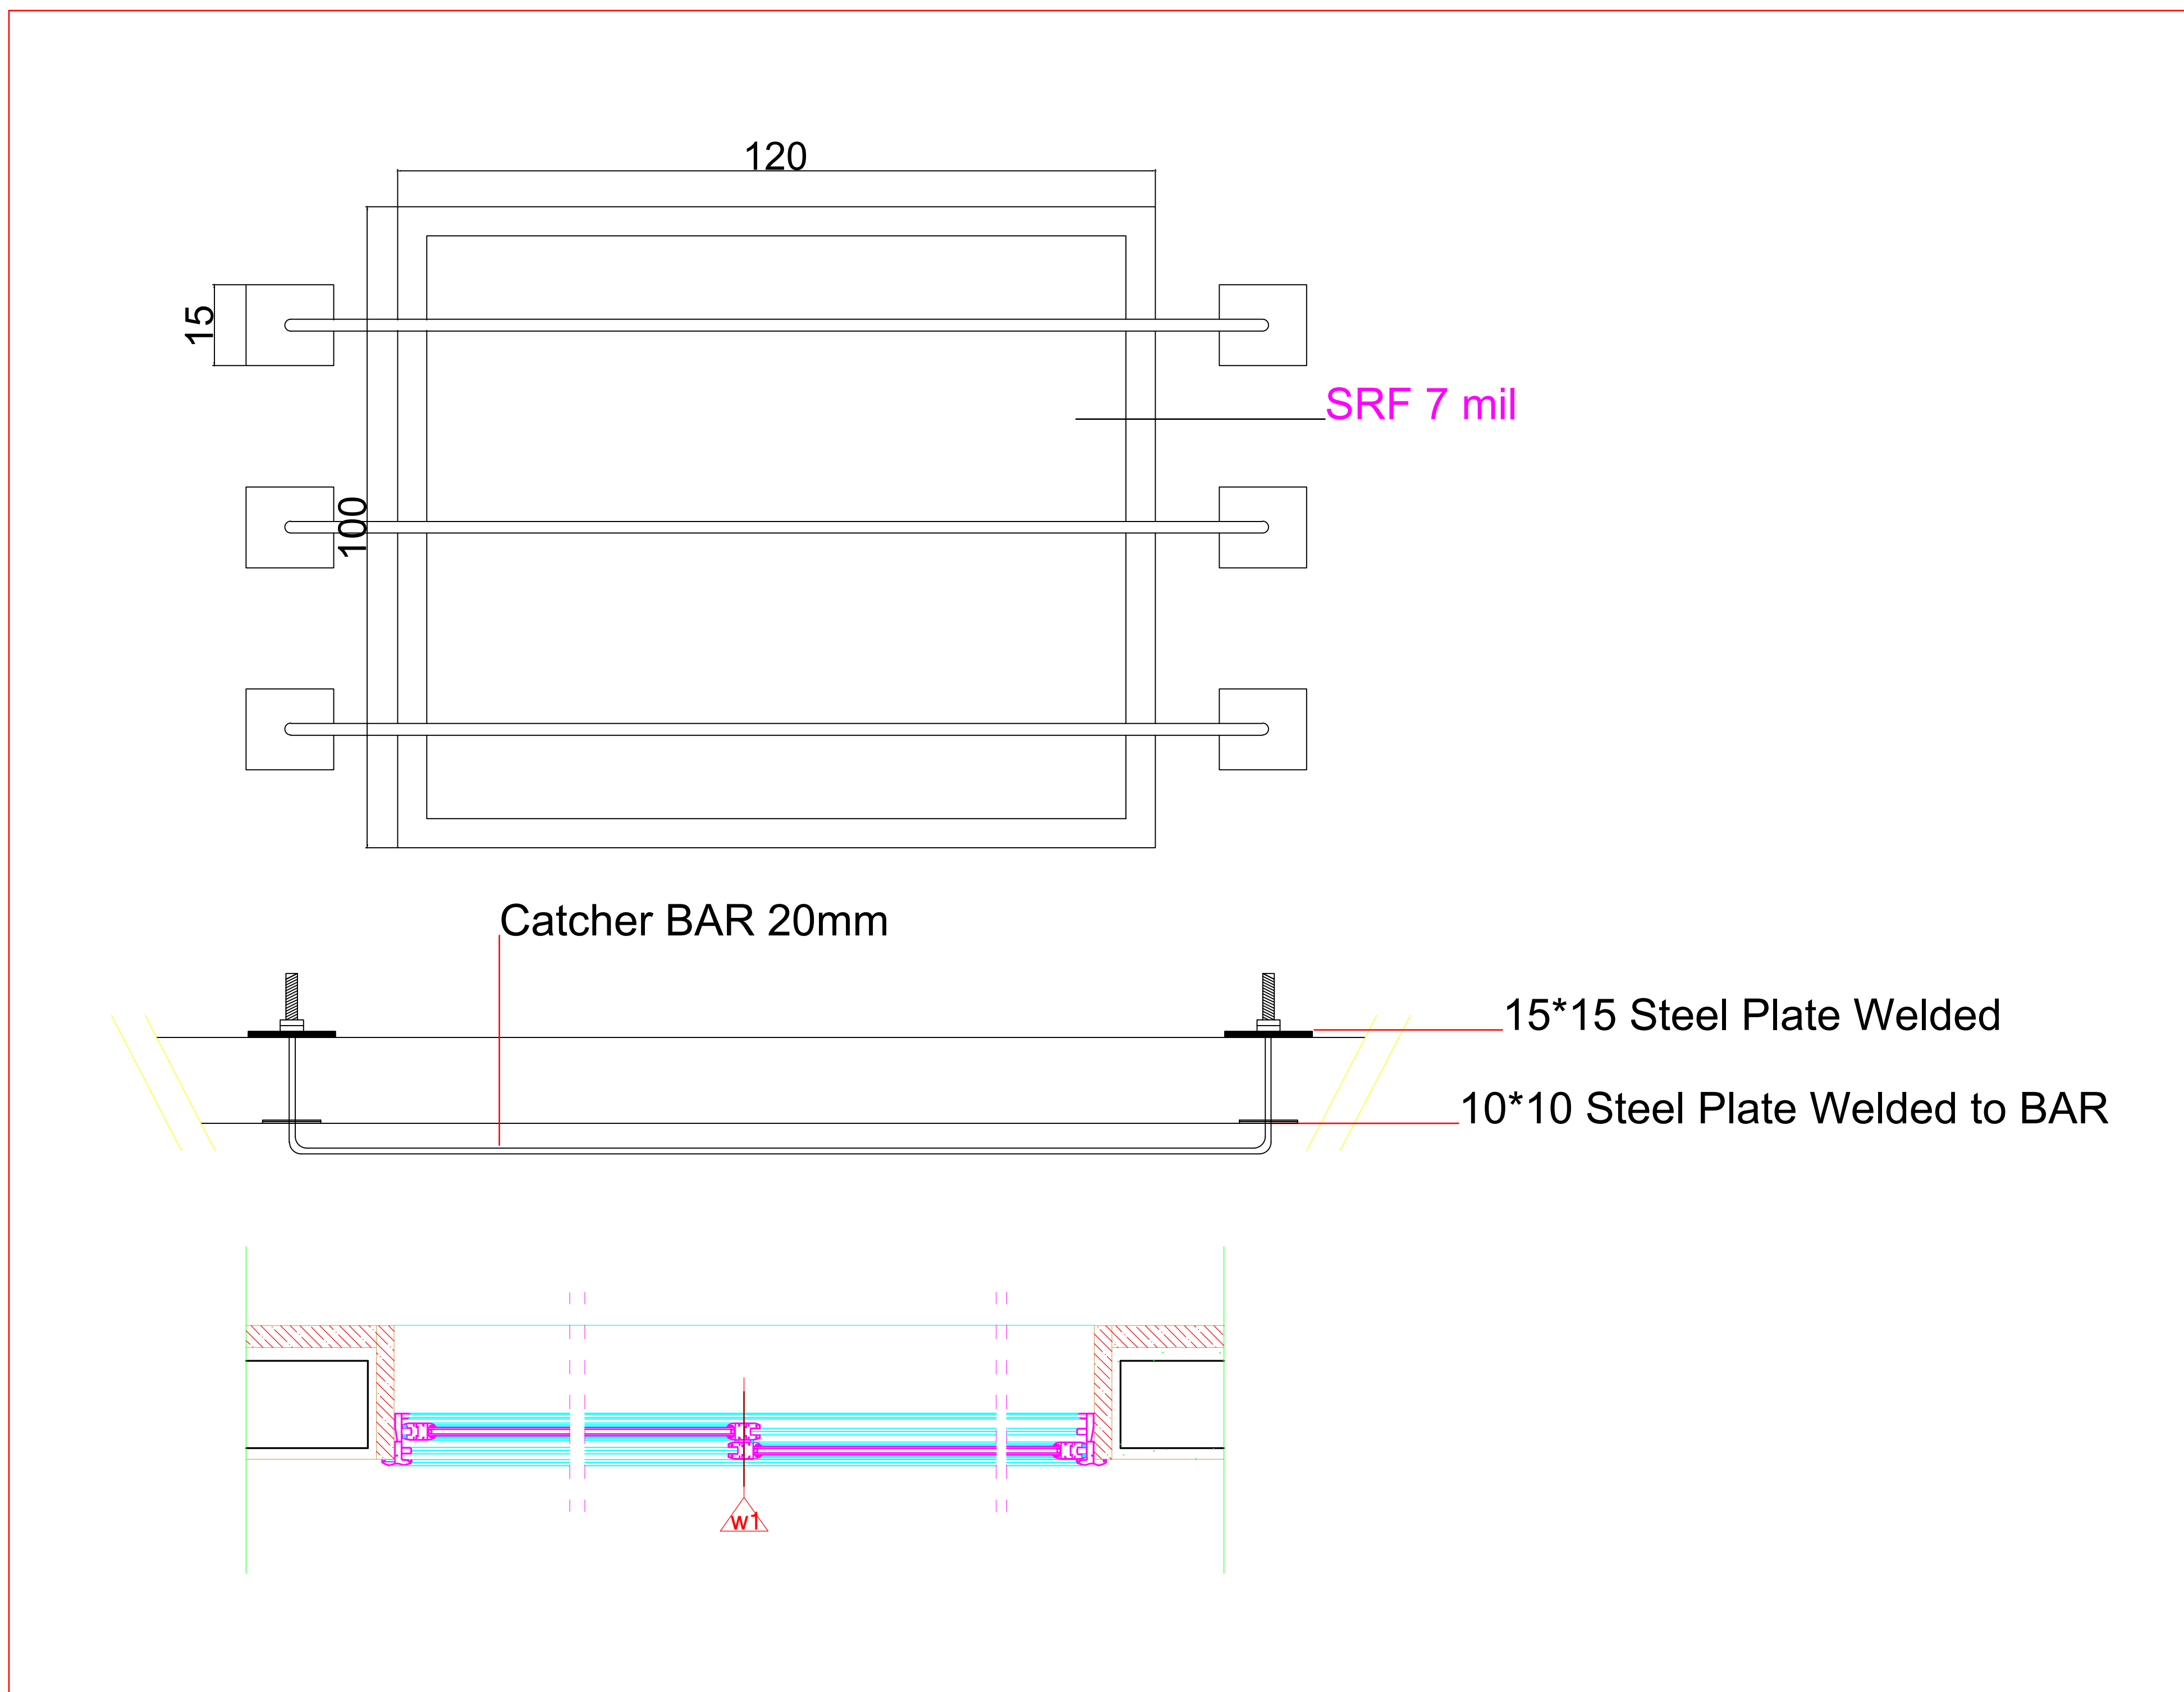

Window	Qty	W (CM)	H (CM)
W1	2	120	100
W2	8	145	135

Windows Details - phase 1

LED down light 18 w	
LED down light 12 w	
Pole light 3m with LED light	
LED light 120cm with reflector	
LED Mirror light 12 w	
one way one gang switch	
one way two gang switch	
Two way one gang switch	
Push Button	
Single socket	
Double socket	
1 Ton A/c	
1.5 Ton A/c	
Pullet camera	
Dome camera	
Smoke detector	
Heat detector	
Sounder	
Automatic Fire extinguisher	
Fire extinguisher	
Break glass	
TV Outlet	
Telephone Outlet	
Data Outlet	



Eng. Khaled Al Jammal
project manager



E-mail: khjammal@hotmail.com
Damascus , Syria

Proposal : 1st floor plan
scale : to fit

Project Name
UNFPA new floor in Damascus

Sheet Size
A3

Date : 27/8/2018

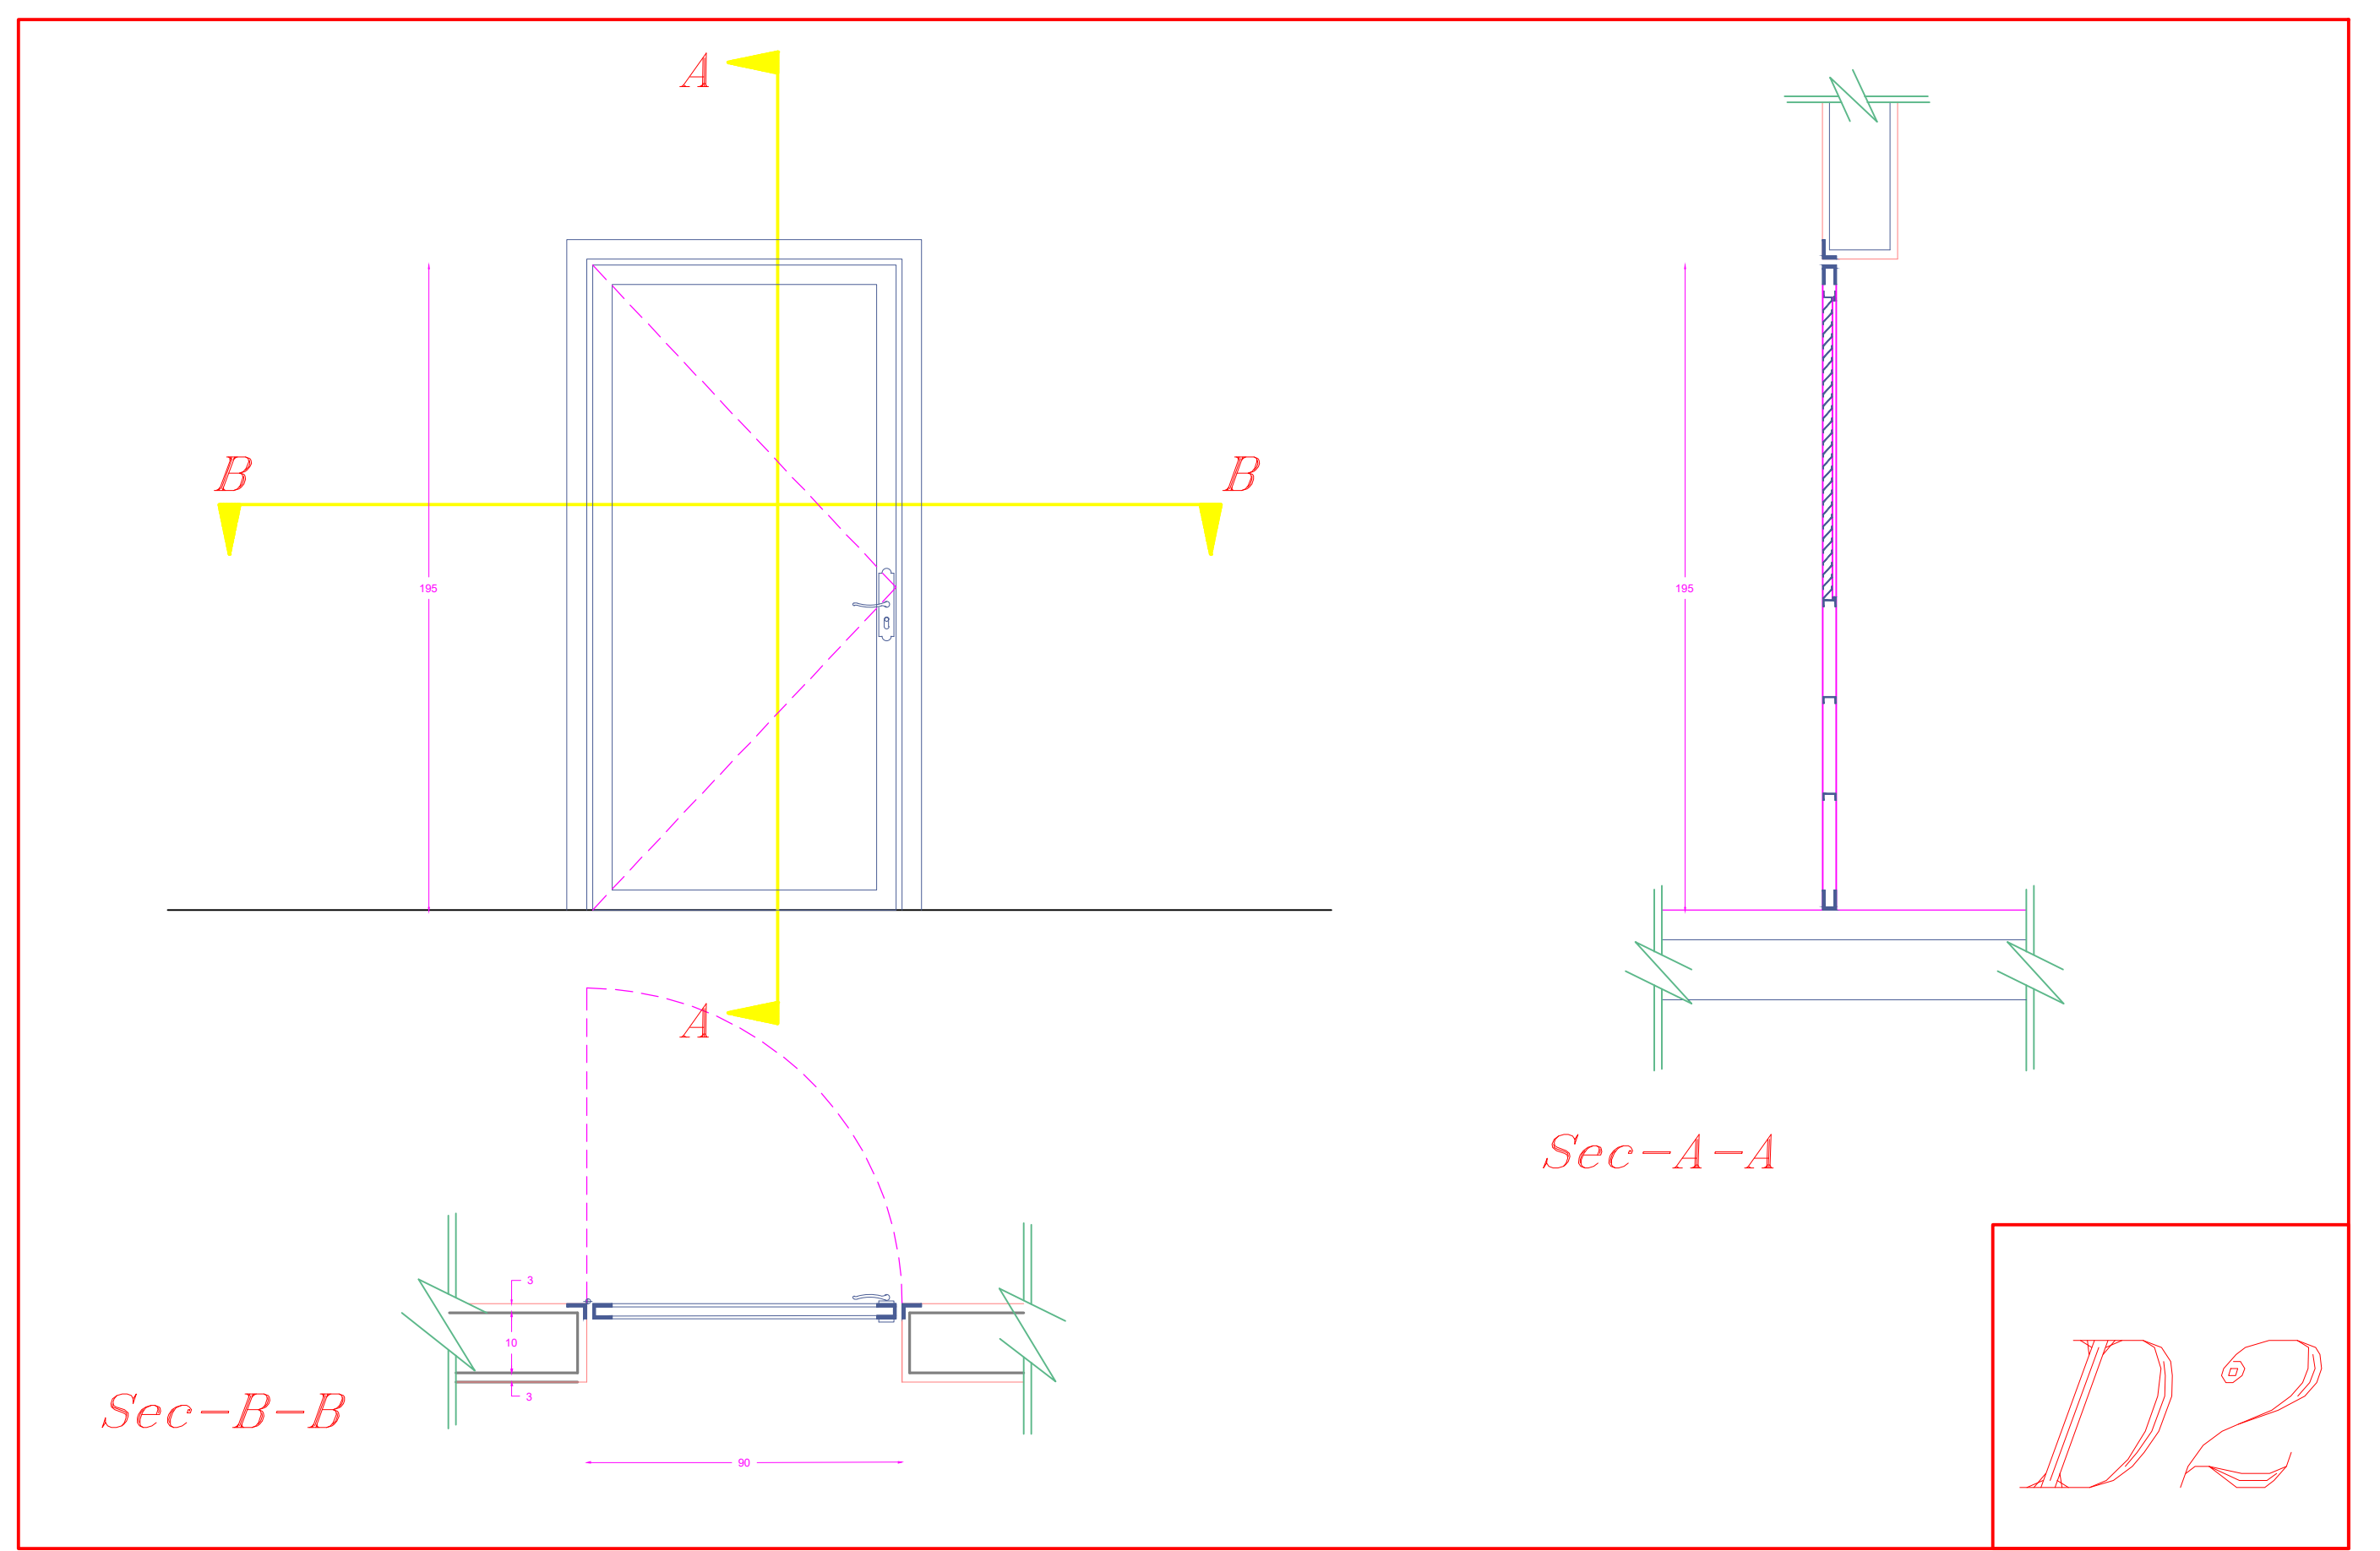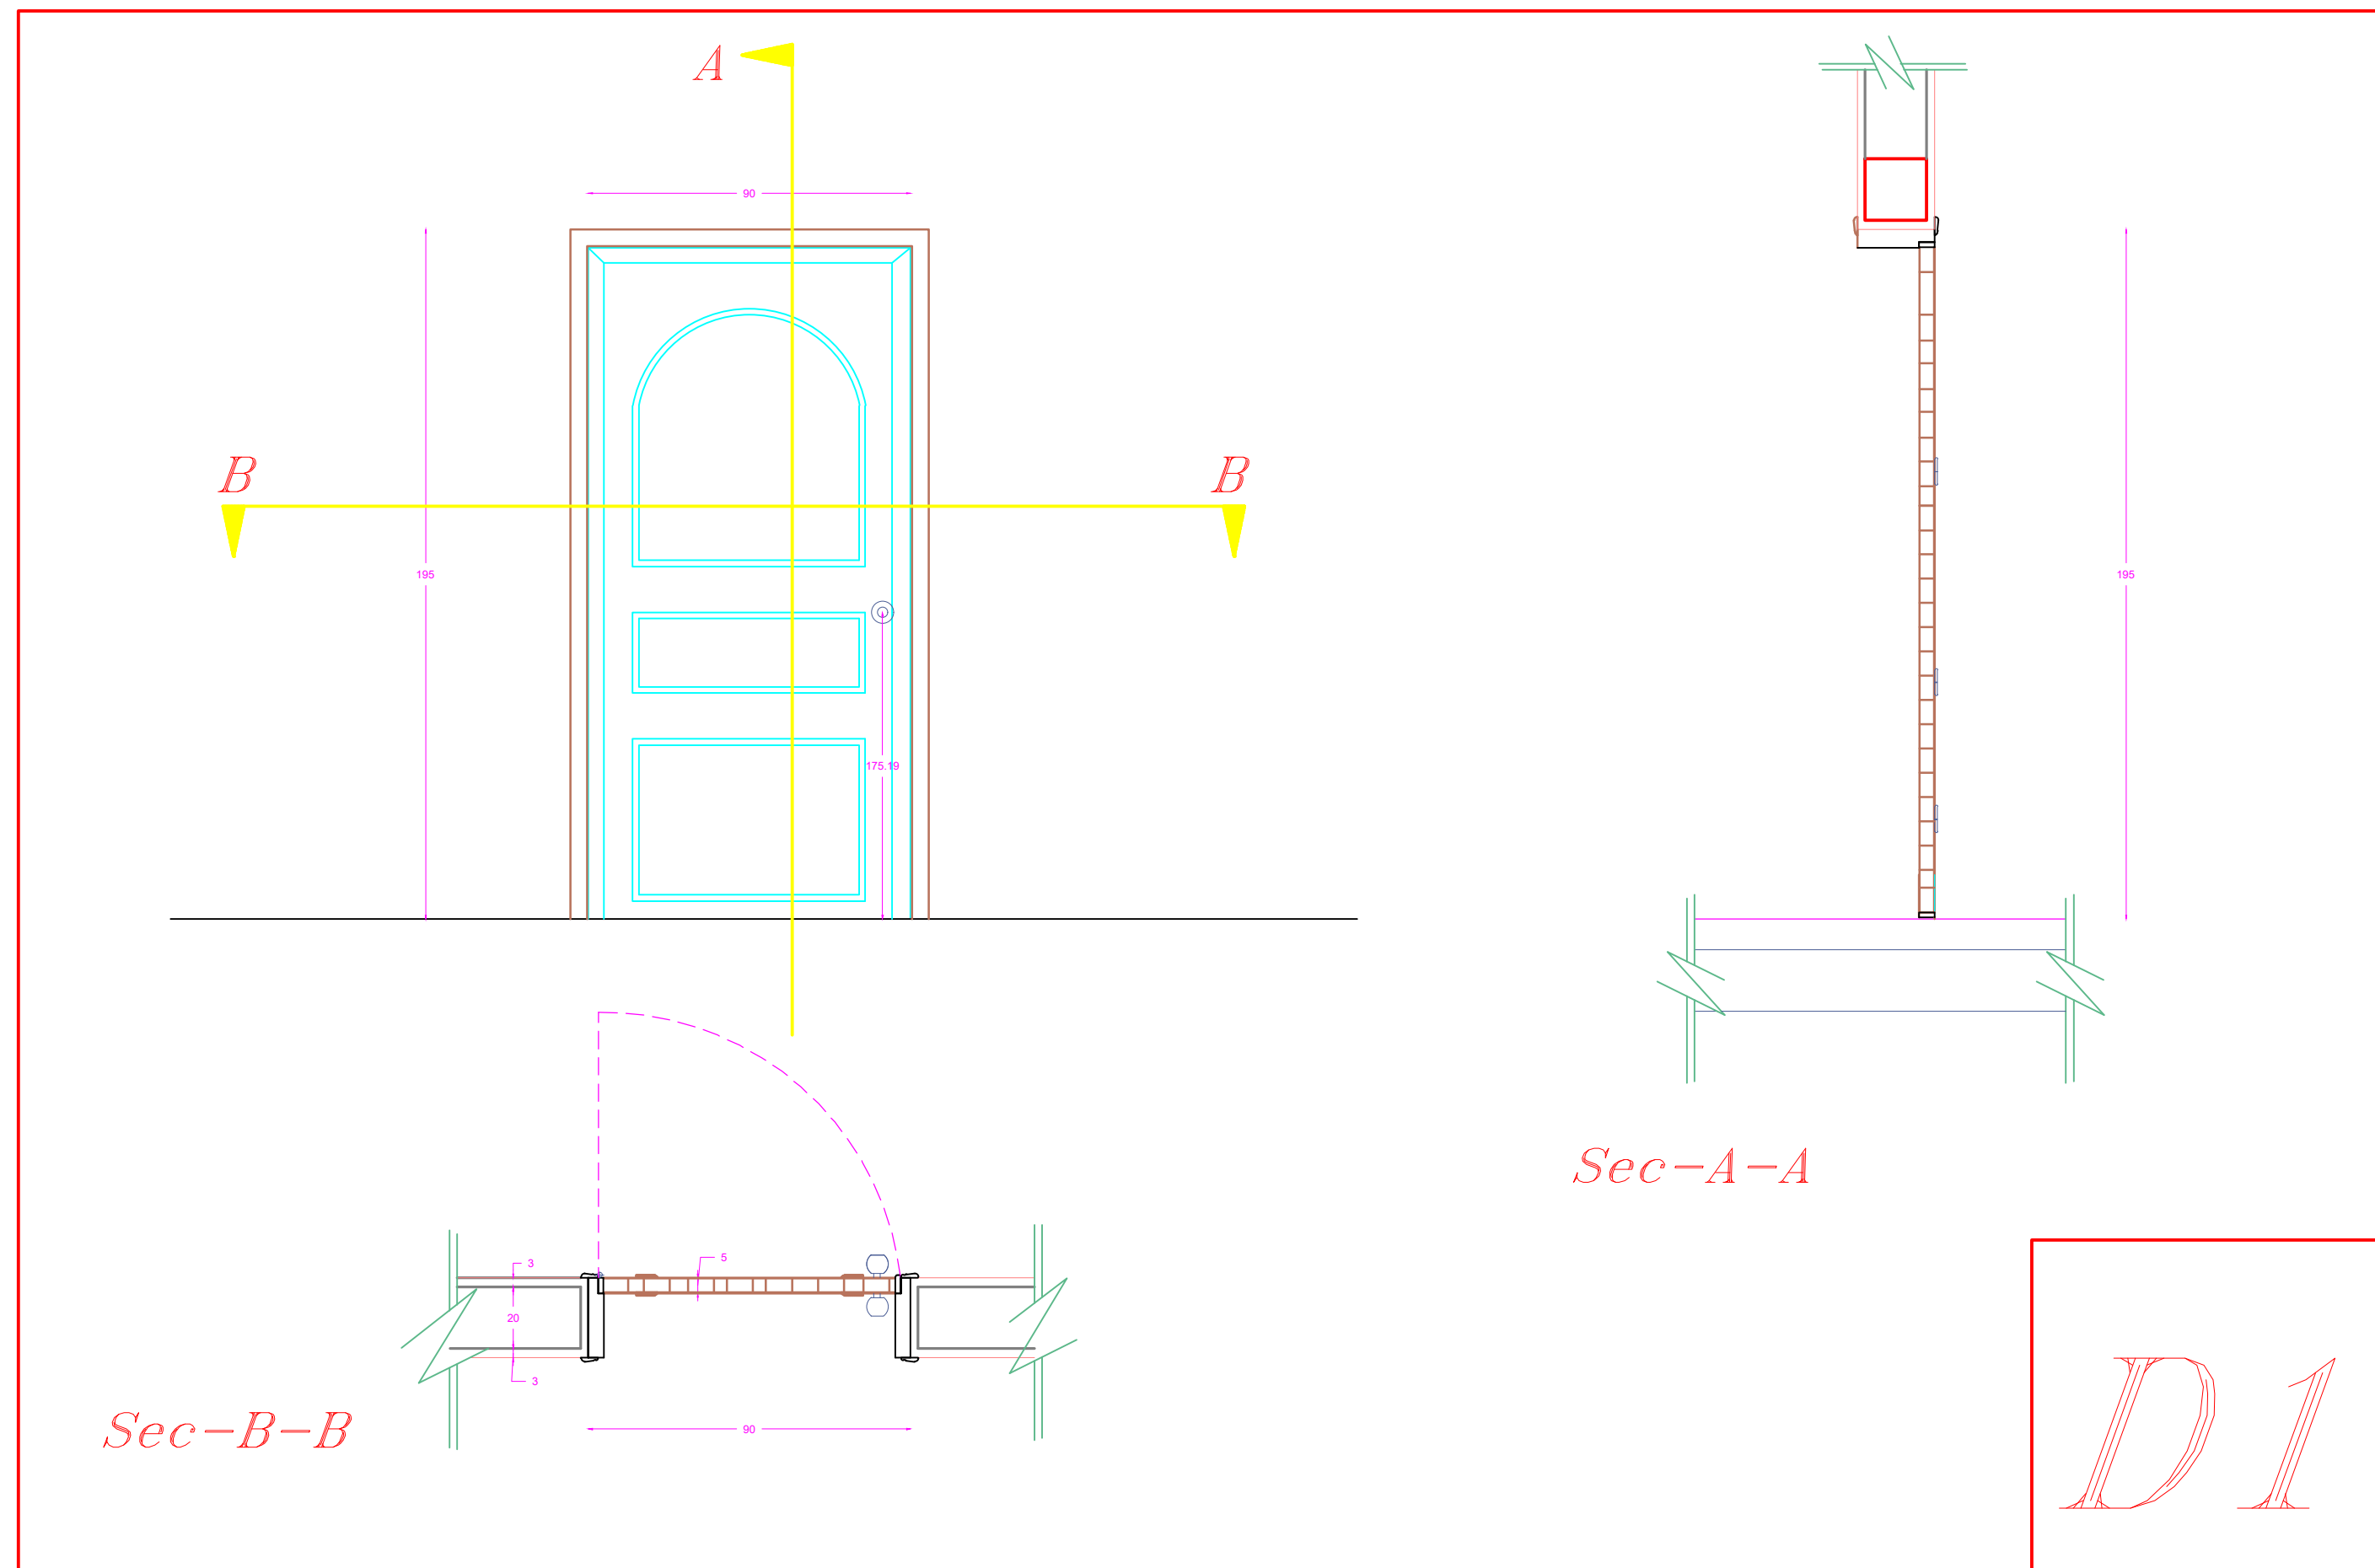

Door	Qty	W (CM)	H (CM)
D1	2	90	195
D2	4	90	195

LED down light 18 w	
LED down light 12 w	
Pole light 3m with LED light	
LED light 120cm with reflector	
LED Mirror light 12 w	
one way one gang switch	
one way two gang switch	
Two way one gang switch	
Push Button	
Single socket	
Double socket	
1 Ton A/c	
1.5 Ton A/c	
Pullet camera	
Dome camera	
Smoke detector	
Heat detector	
Sounder	
Automatic Fire extinguisher	
Fire extinguisher	
Break glass	
TV Outlet	
Telephone Outlet	
Data Outlet	

Doors Details - phase 1



Eng. Khaled Al Jammal
project manager


E-mail: khjammal@hotmail.com
Damascus , Syria

Proposal : 1st floor plan
scale : to fit

Project Name
UNFPA new floor in Damascus

Sheet Size
A3

Date : 27/8/2018

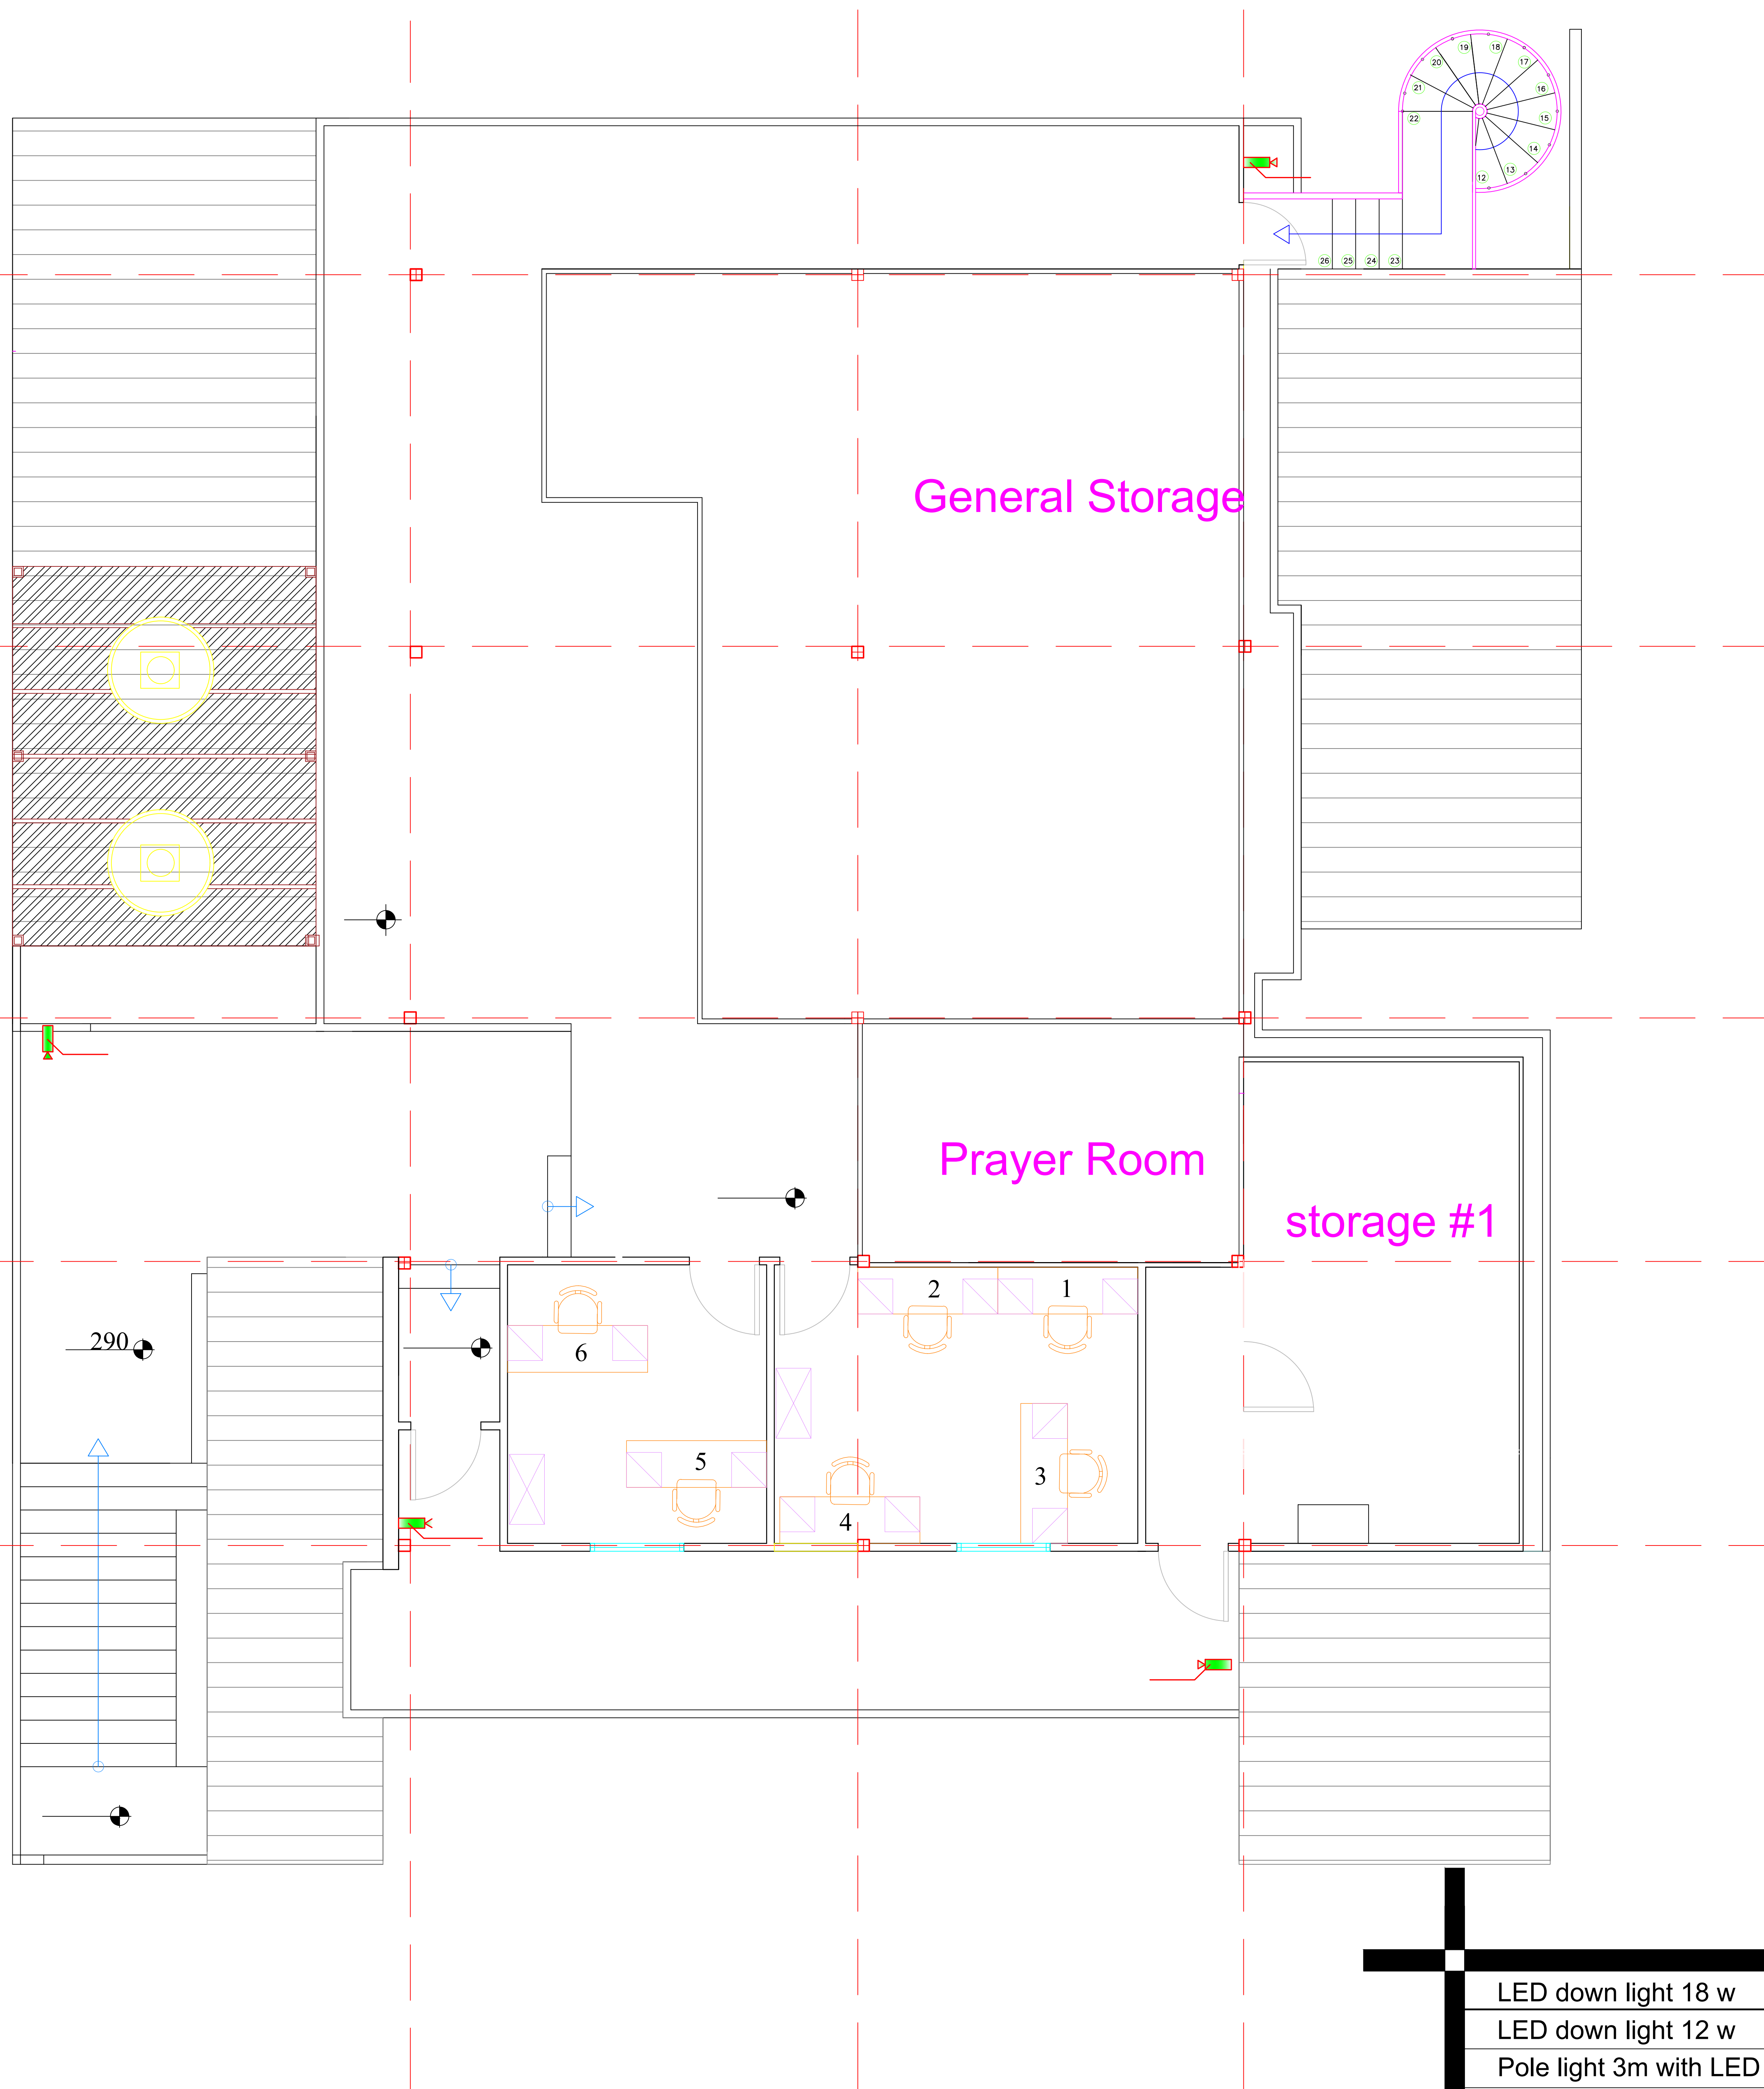

CCTV CAMERAS - phase 1


LED down light 18 w	
LED down light 12 w	
Pole light 3m with LED light	
LED light 120cm with reflector	
LED Mirror light 12 w	
one way one gang switch	
one way two gang switch	
Two way one gang switch	
Push Button	
Single socket	
Double socket	
1 Ton A/c	
1.5 Ton A/c	
Pullet camera	
Dome camera	
Smoke detector	
Heat detector	
Sounder	
Automatic Fire extinguisher	
Fire extinguisher	
Break glass	
TV Outlet	
Telephone Outlet	
Data Outlet	



Eng. Khaled Al Jammal
 project manager
 E-mail: khjammal@hotmail.com
 Damascus , Syria

Proposal : 1st floor plan
 scale : to fit
 Project Name
 UNFPA new floor in Damascus

Sheet Size
 A3
 Date : 27/8/2018

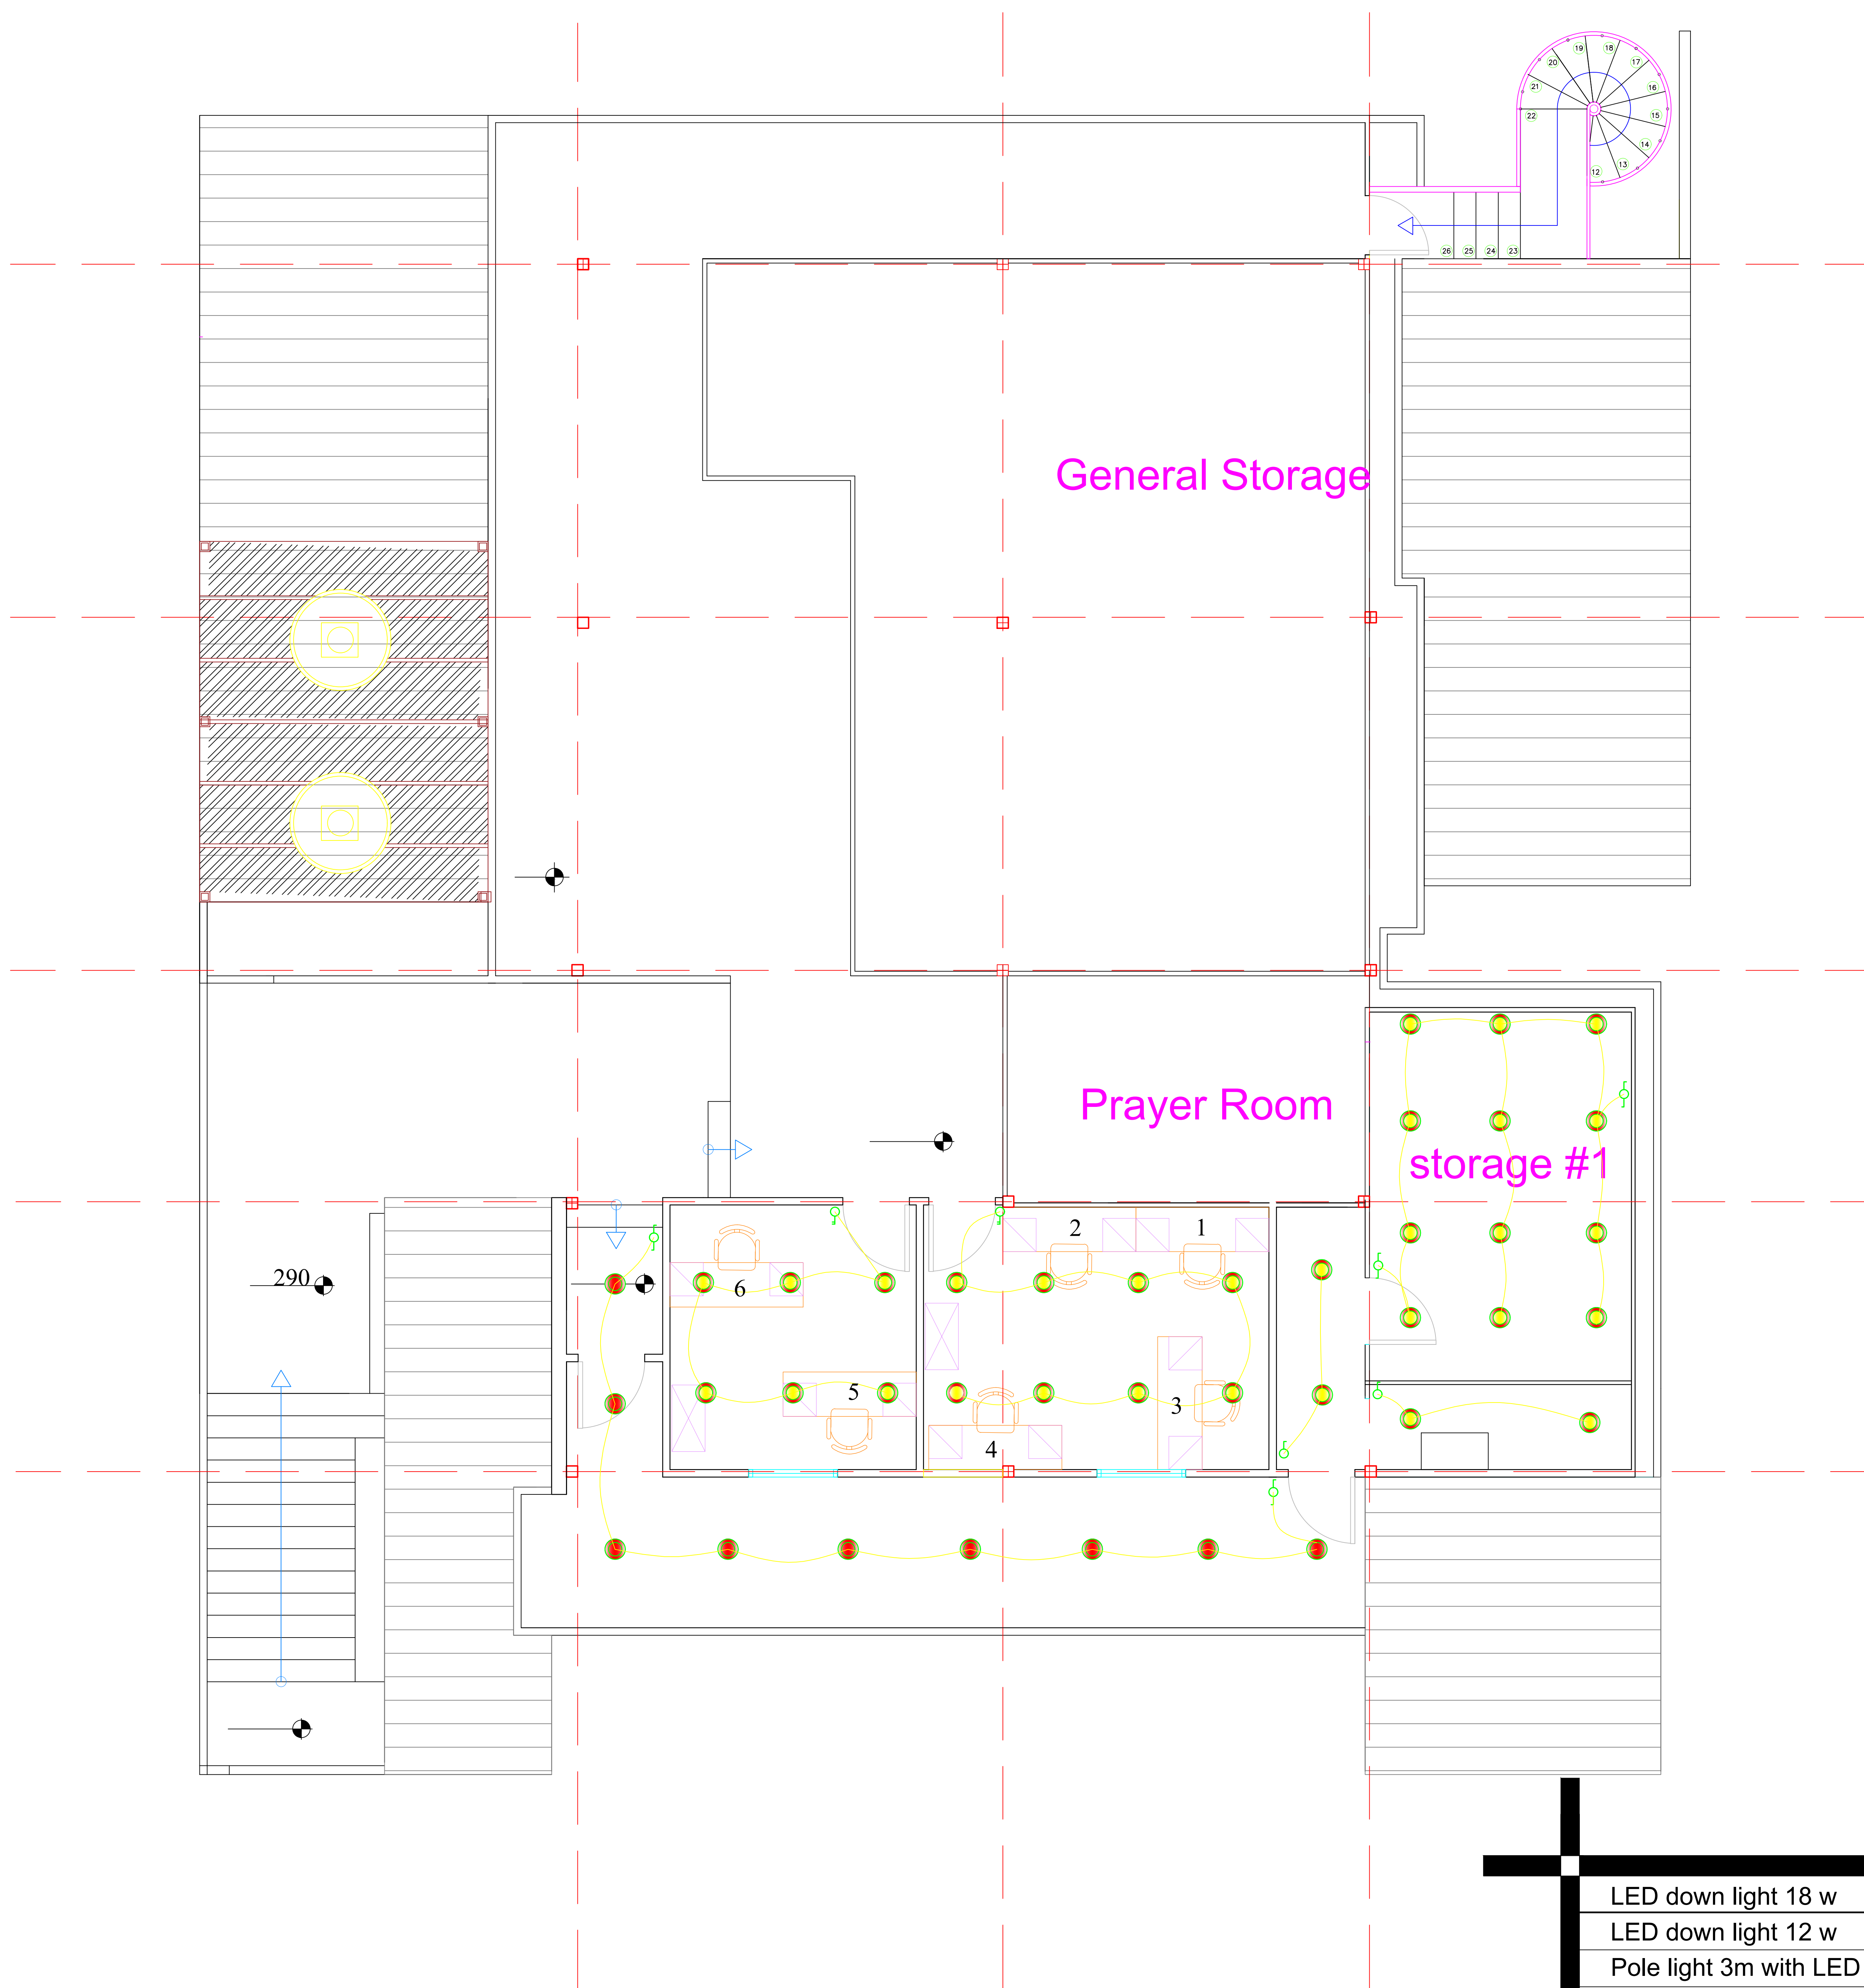

lighting plan - phase 1


LED down light 18 w	
LED down light 12 w	
Pole light 3m with LED light	
LED light 120cm with reflector	
LED Mirror light 12 w	
one way one gang switch	
one way two gang switch	
Two way one gang switch	
Push Button	
Single socket	
Double socket	
1 Ton A/c	
1.5 Ton A/c	
Pullet camera	
Dome camera	
Smoke detector	
Heat detector	
Sounder	
Automatic Fire extinguisher	
Fire extinguisher	
Break glass	
TV Outlet	
Telephone Outlet	
Data Outlet	



Eng. Khaled Al Jammal
project manager
E-mail: khjammal@hotmail.com
Damascus , Syria

Proposal : 1st floor plan
scale : to fit
Project Name
UNFPA new floor in Damascus

Sheet Size
A3
Date : 27/8/2018

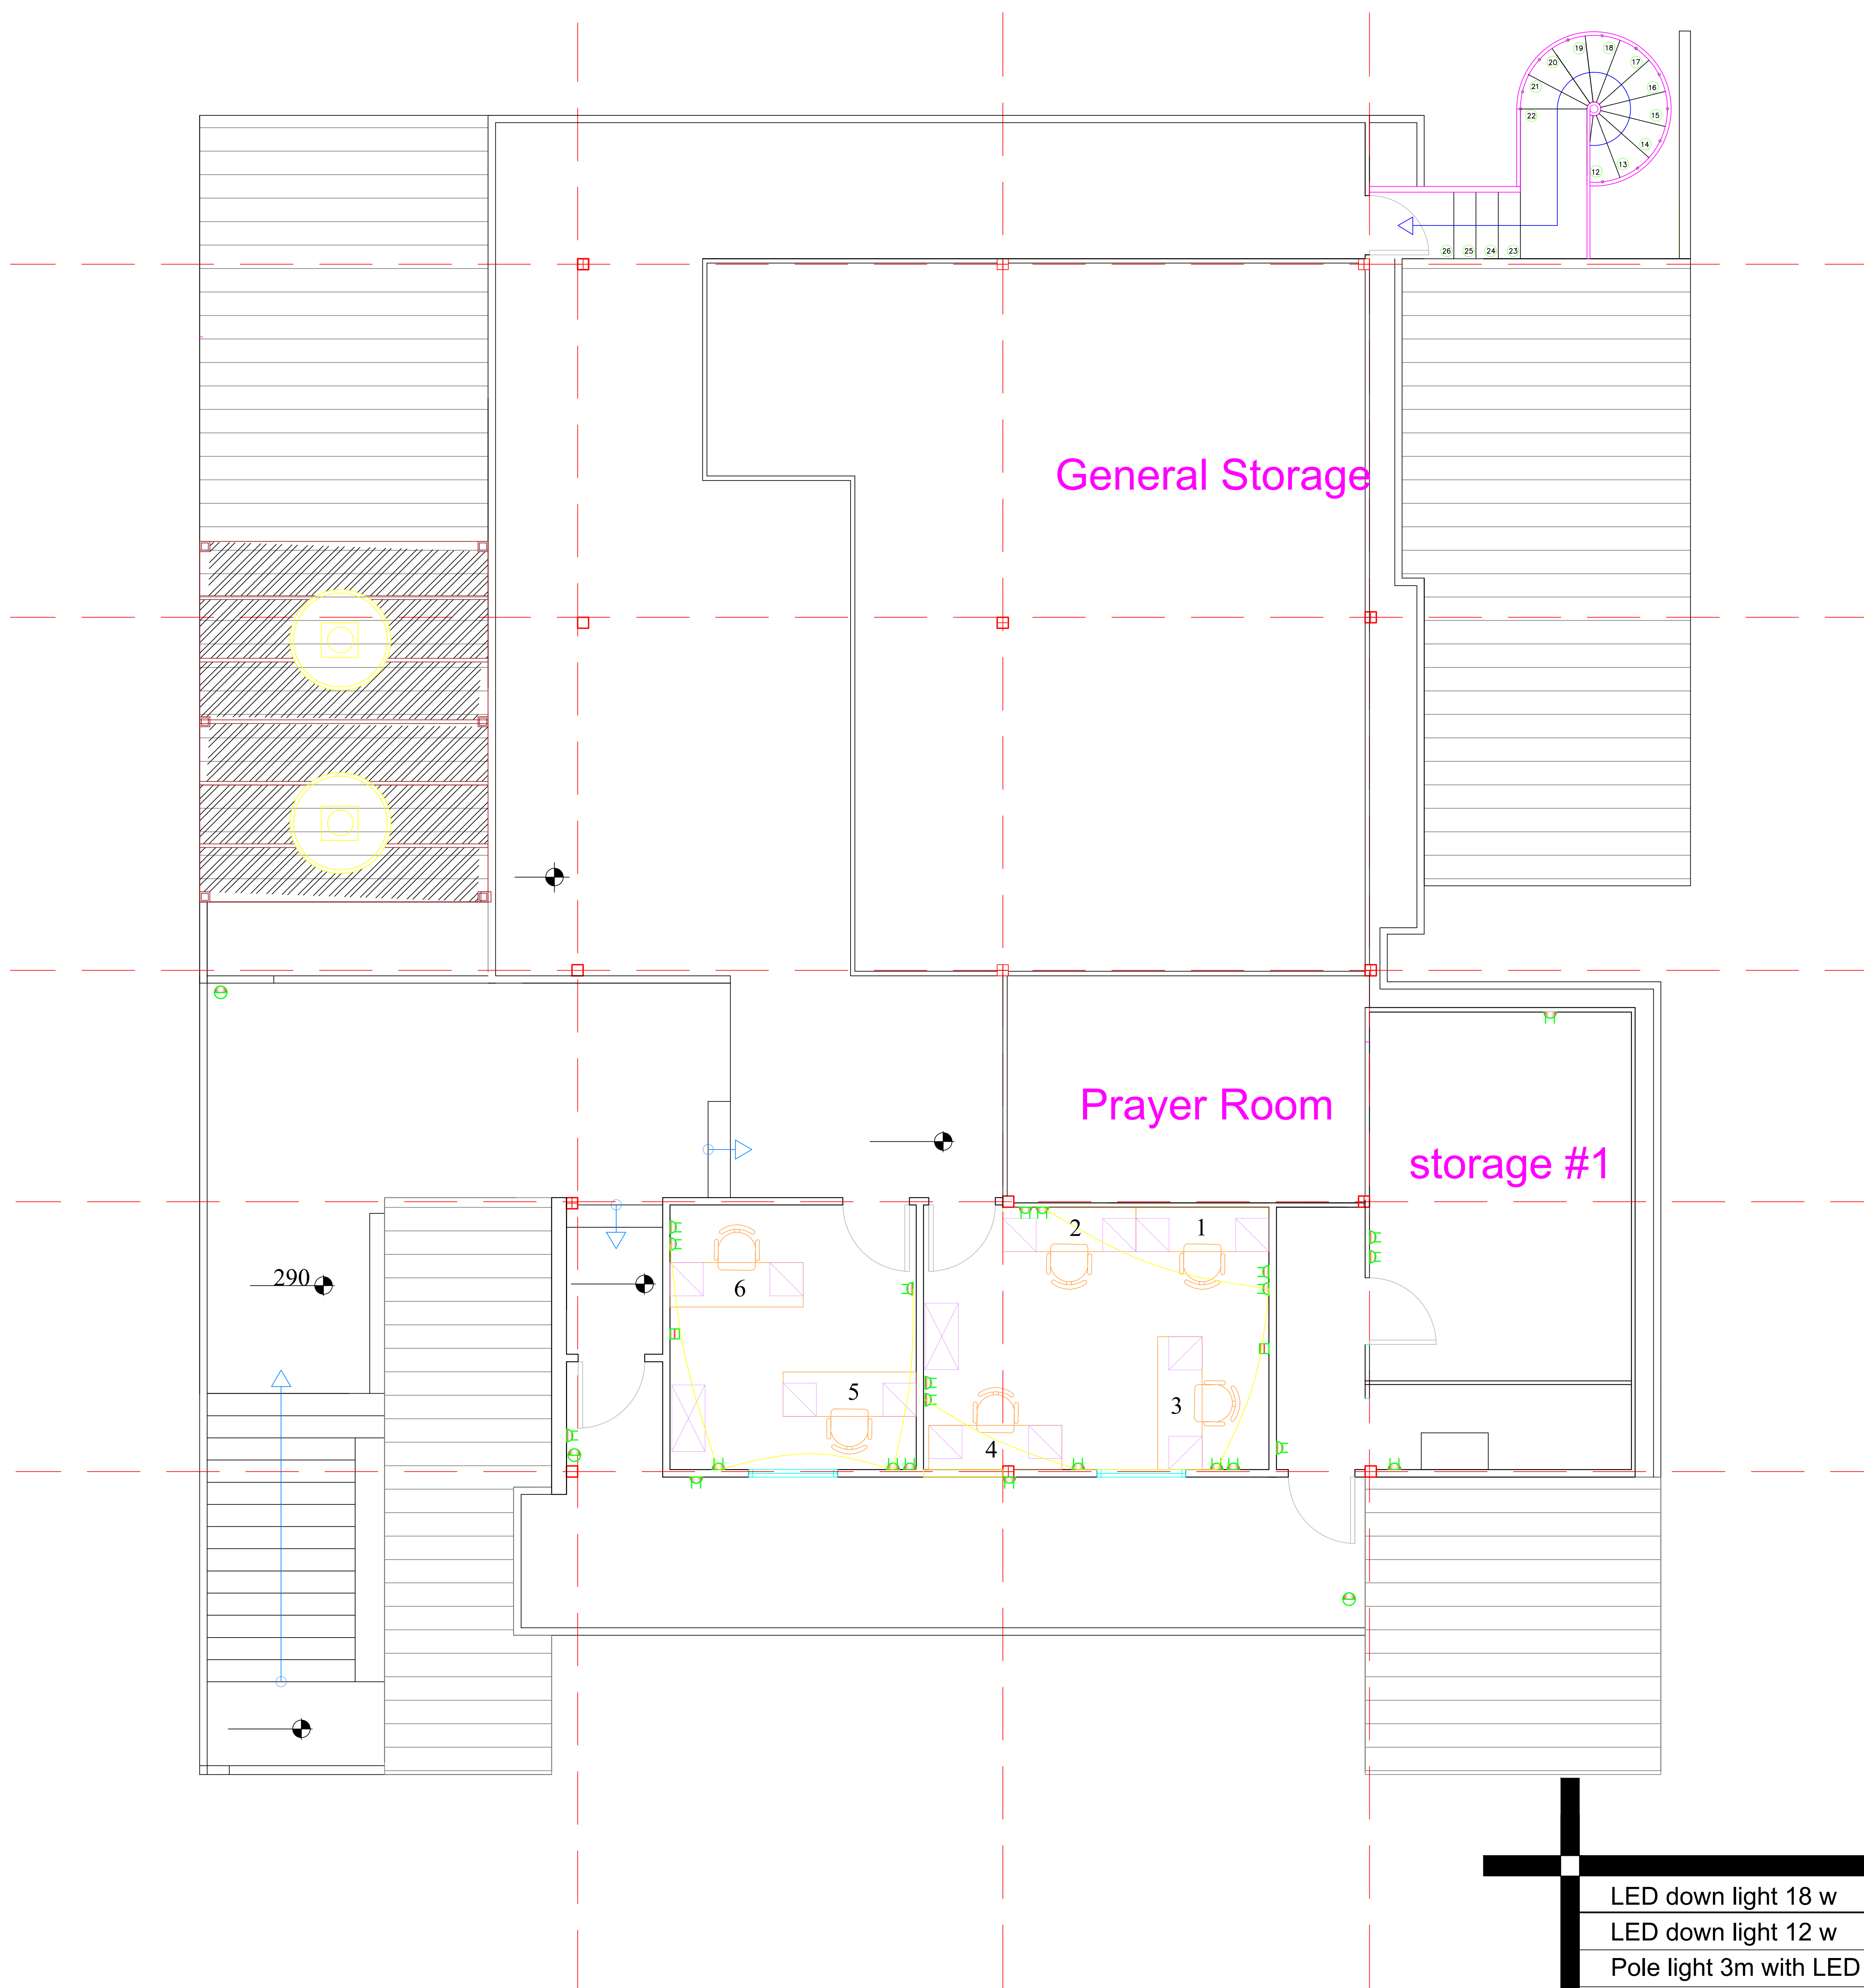

Power Plans - phase 1

LED down light 18 w	
LED down light 12 w	
Pole light 3m with LED light	
LED light 120cm with reflector	
LED Mirror light 12 w	
one way one gang switch	
one way two gang switch	
Two way one gang switch	
Push Button	
Single socket	
Double socket	
1 Ton A/c	
1.5 Ton A/c	
Pullet camera	
Dome camera	
Smoke detector	
Heat detector	
Sounder	
Automatic Fire extinguisher	
Fire extinguisher	
Break glass	
TV Outlet	
Telephone Outlet	
Data Outlet	



Eng. Khaled Al Jammal
project manager


E-mail: khjammal@hotmail.com
Damascus , Syria

Proposal : 1st floor plan
scale : to fit

Project Name
UNFPA new floor in Damascus

Sheet Size
A3

Date : 27/8/2018

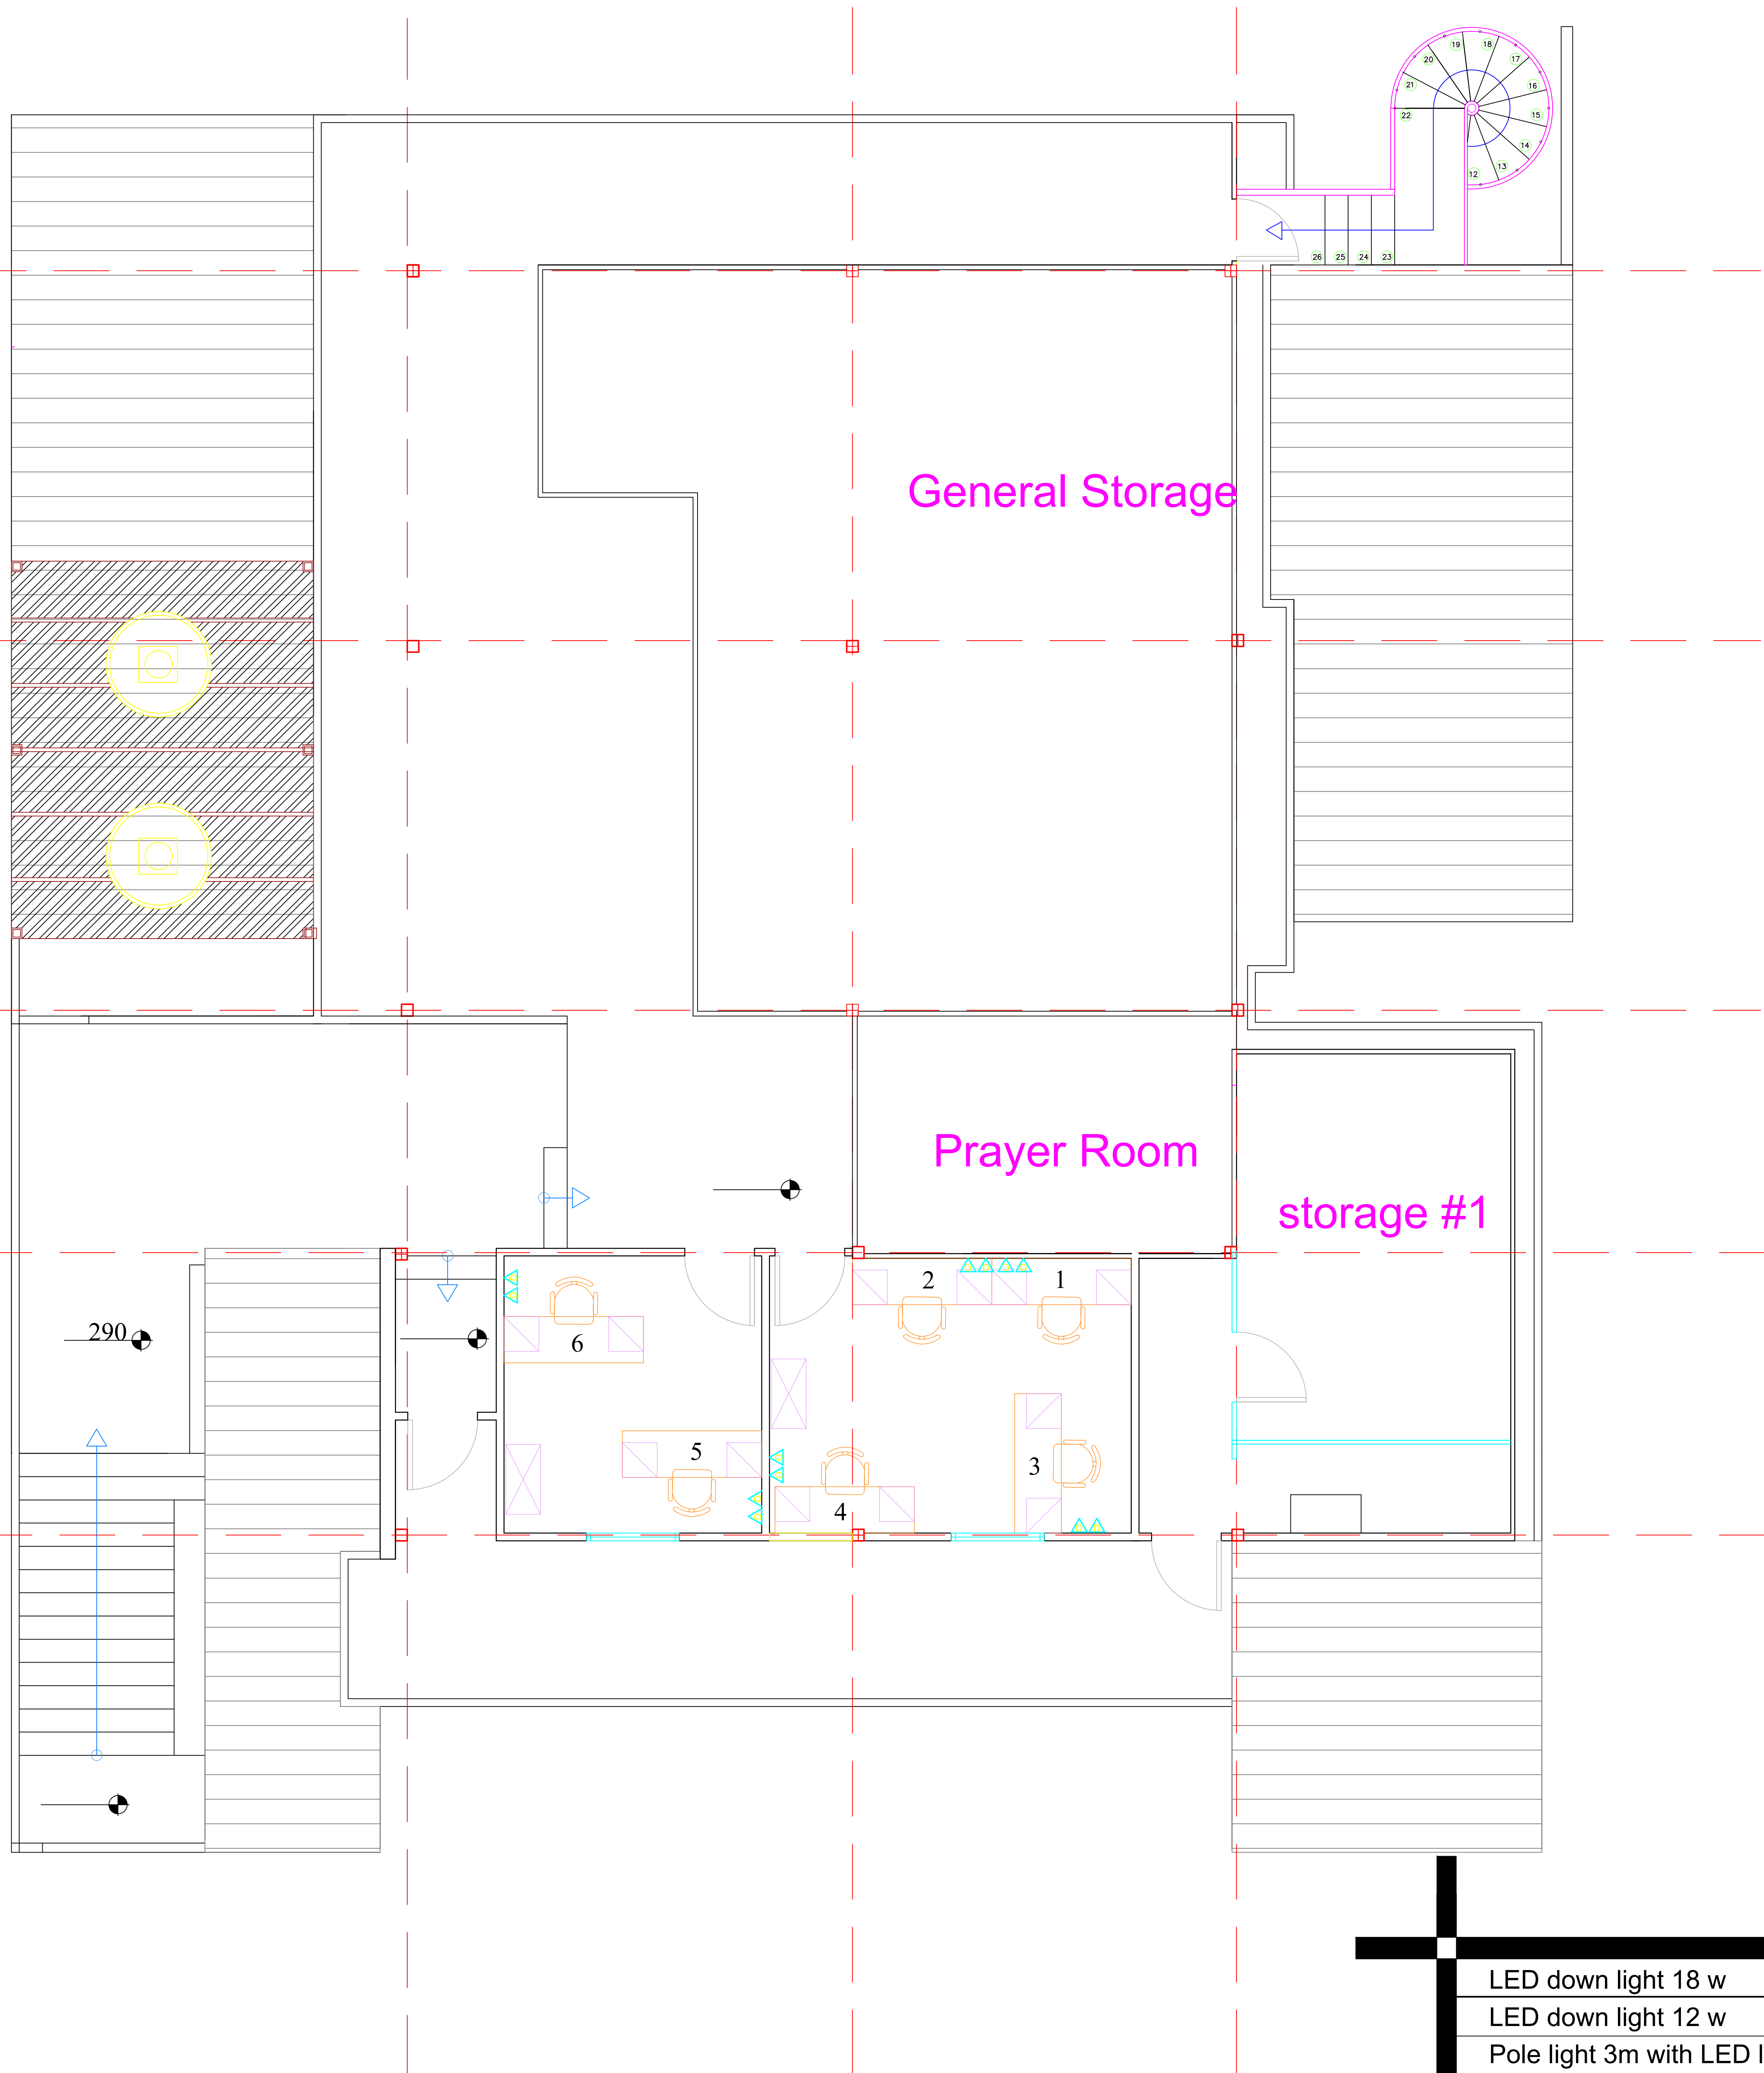

Points Location - phase 1


LED down light 18 w	
LED down light 12 w	
Pole light 3m with LED light	
LED light 120cm with reflector	
LED Mirror light 12 w	
one way one gang switch	
one way two gang switch	
Two way one gang switch	
Push Button	
Single socket	
Double socket	
1 Ton A/c	
1.5 Ton A/c	
Pullet camera	
Dome camera	
Smoke detector	
Heat detector	
Sounder	
Automatic Fire extinguisher	
Fire extinguisher	
Break glass	
TV Outlet	
Telephone Outlet	
Data Outlet	



Eng. Khaled Al Jammal
 project manager
 E-mail: khjammal@hotmail.com
 Damascus , Syria

Proposal : 1st floor plan
 scale : to fit
 Project Name
 UNFPA new floor in Damascus

Sheet Size
 A3
 Date : 27/8/2018

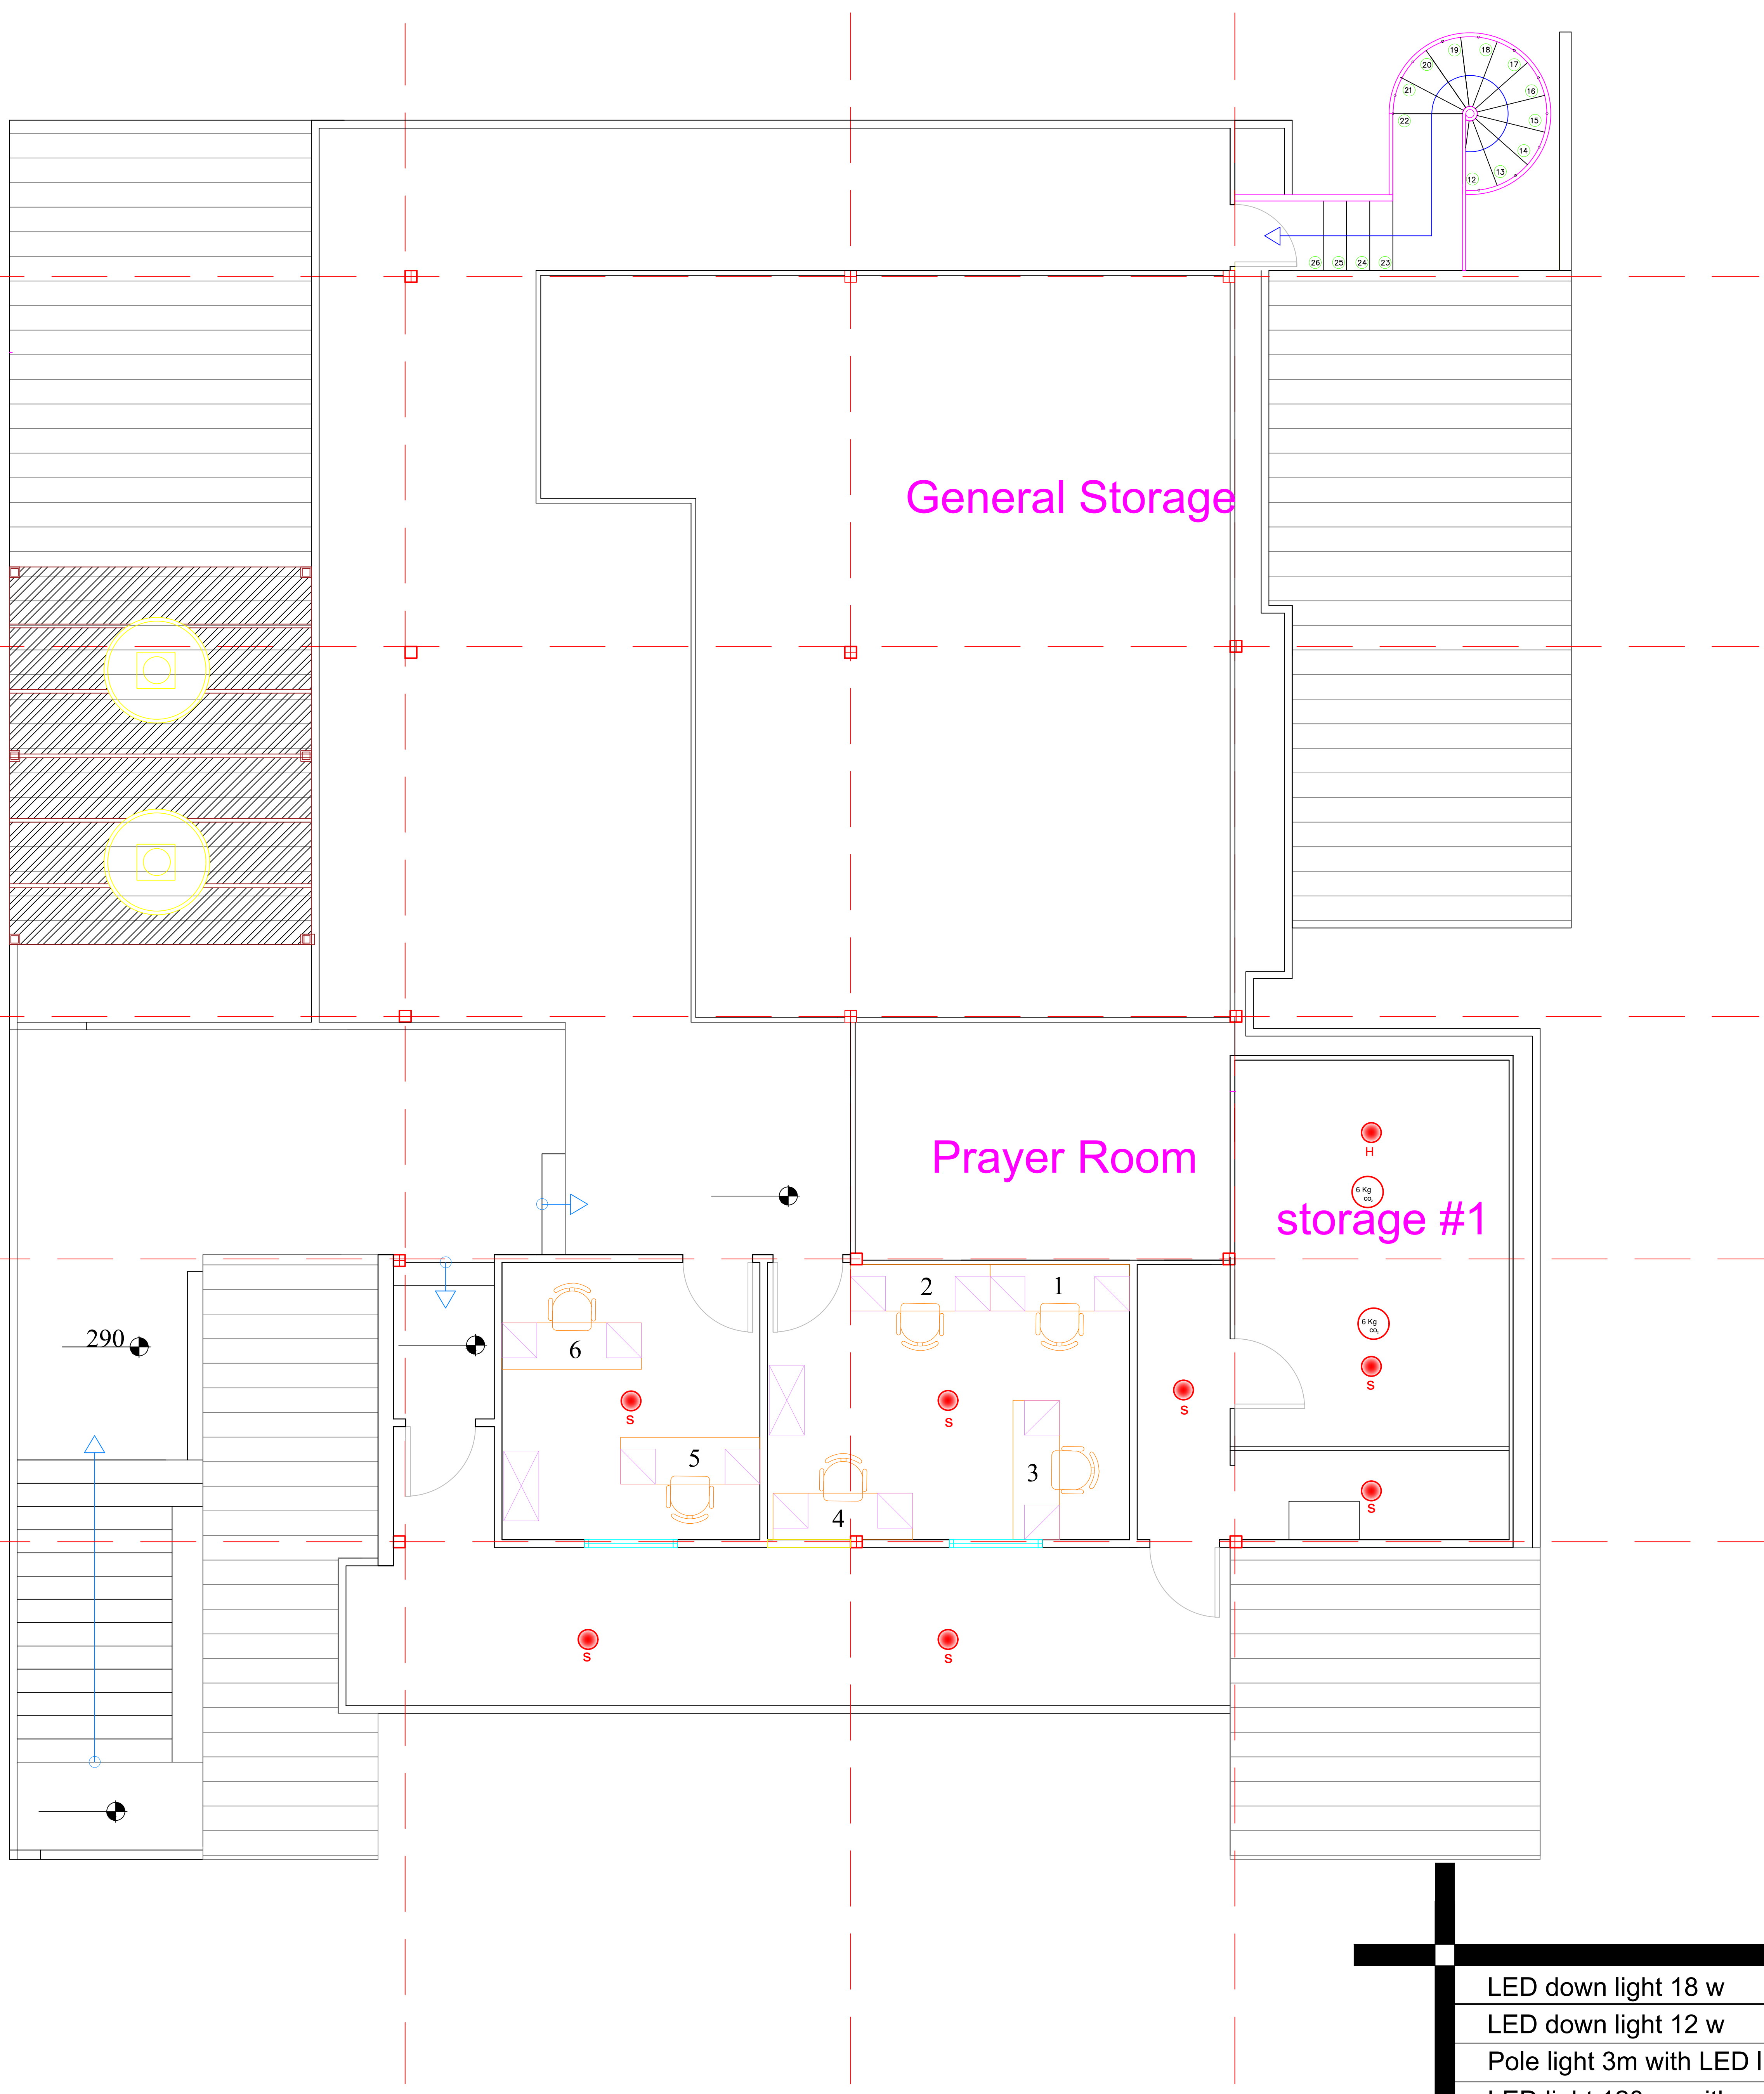

Alarm system - phase 1


LED down light 18 w	
LED down light 12 w	
Pole light 3m with LED light	
LED light 120cm with reflector	
LED Mirror light 12 w	
one way one gang switch	
one way two gang switch	
Two way one gang switch	
Push Button	
Single socket	
Double socket	
1 Ton A/c	
1.5 Ton A/c	
Pullet camera	
Dome camera	
Smoke detector	
Heat detector	
Sounder	
Automatic Fire extinguisher	
Fire extinguisher	
Break glass	
TV Outlet	
Telephone Outlet	
Data Outlet	



Eng. Khaled Al Jammal
project manager
E-mail: khjammal@hotmail.com
Damascus , Syria

Proposal : 1st floor plan
scale : to fit
Project Name
UNFPA new floor in Damascus

Sheet Size
A3
Date : 27/8/2018

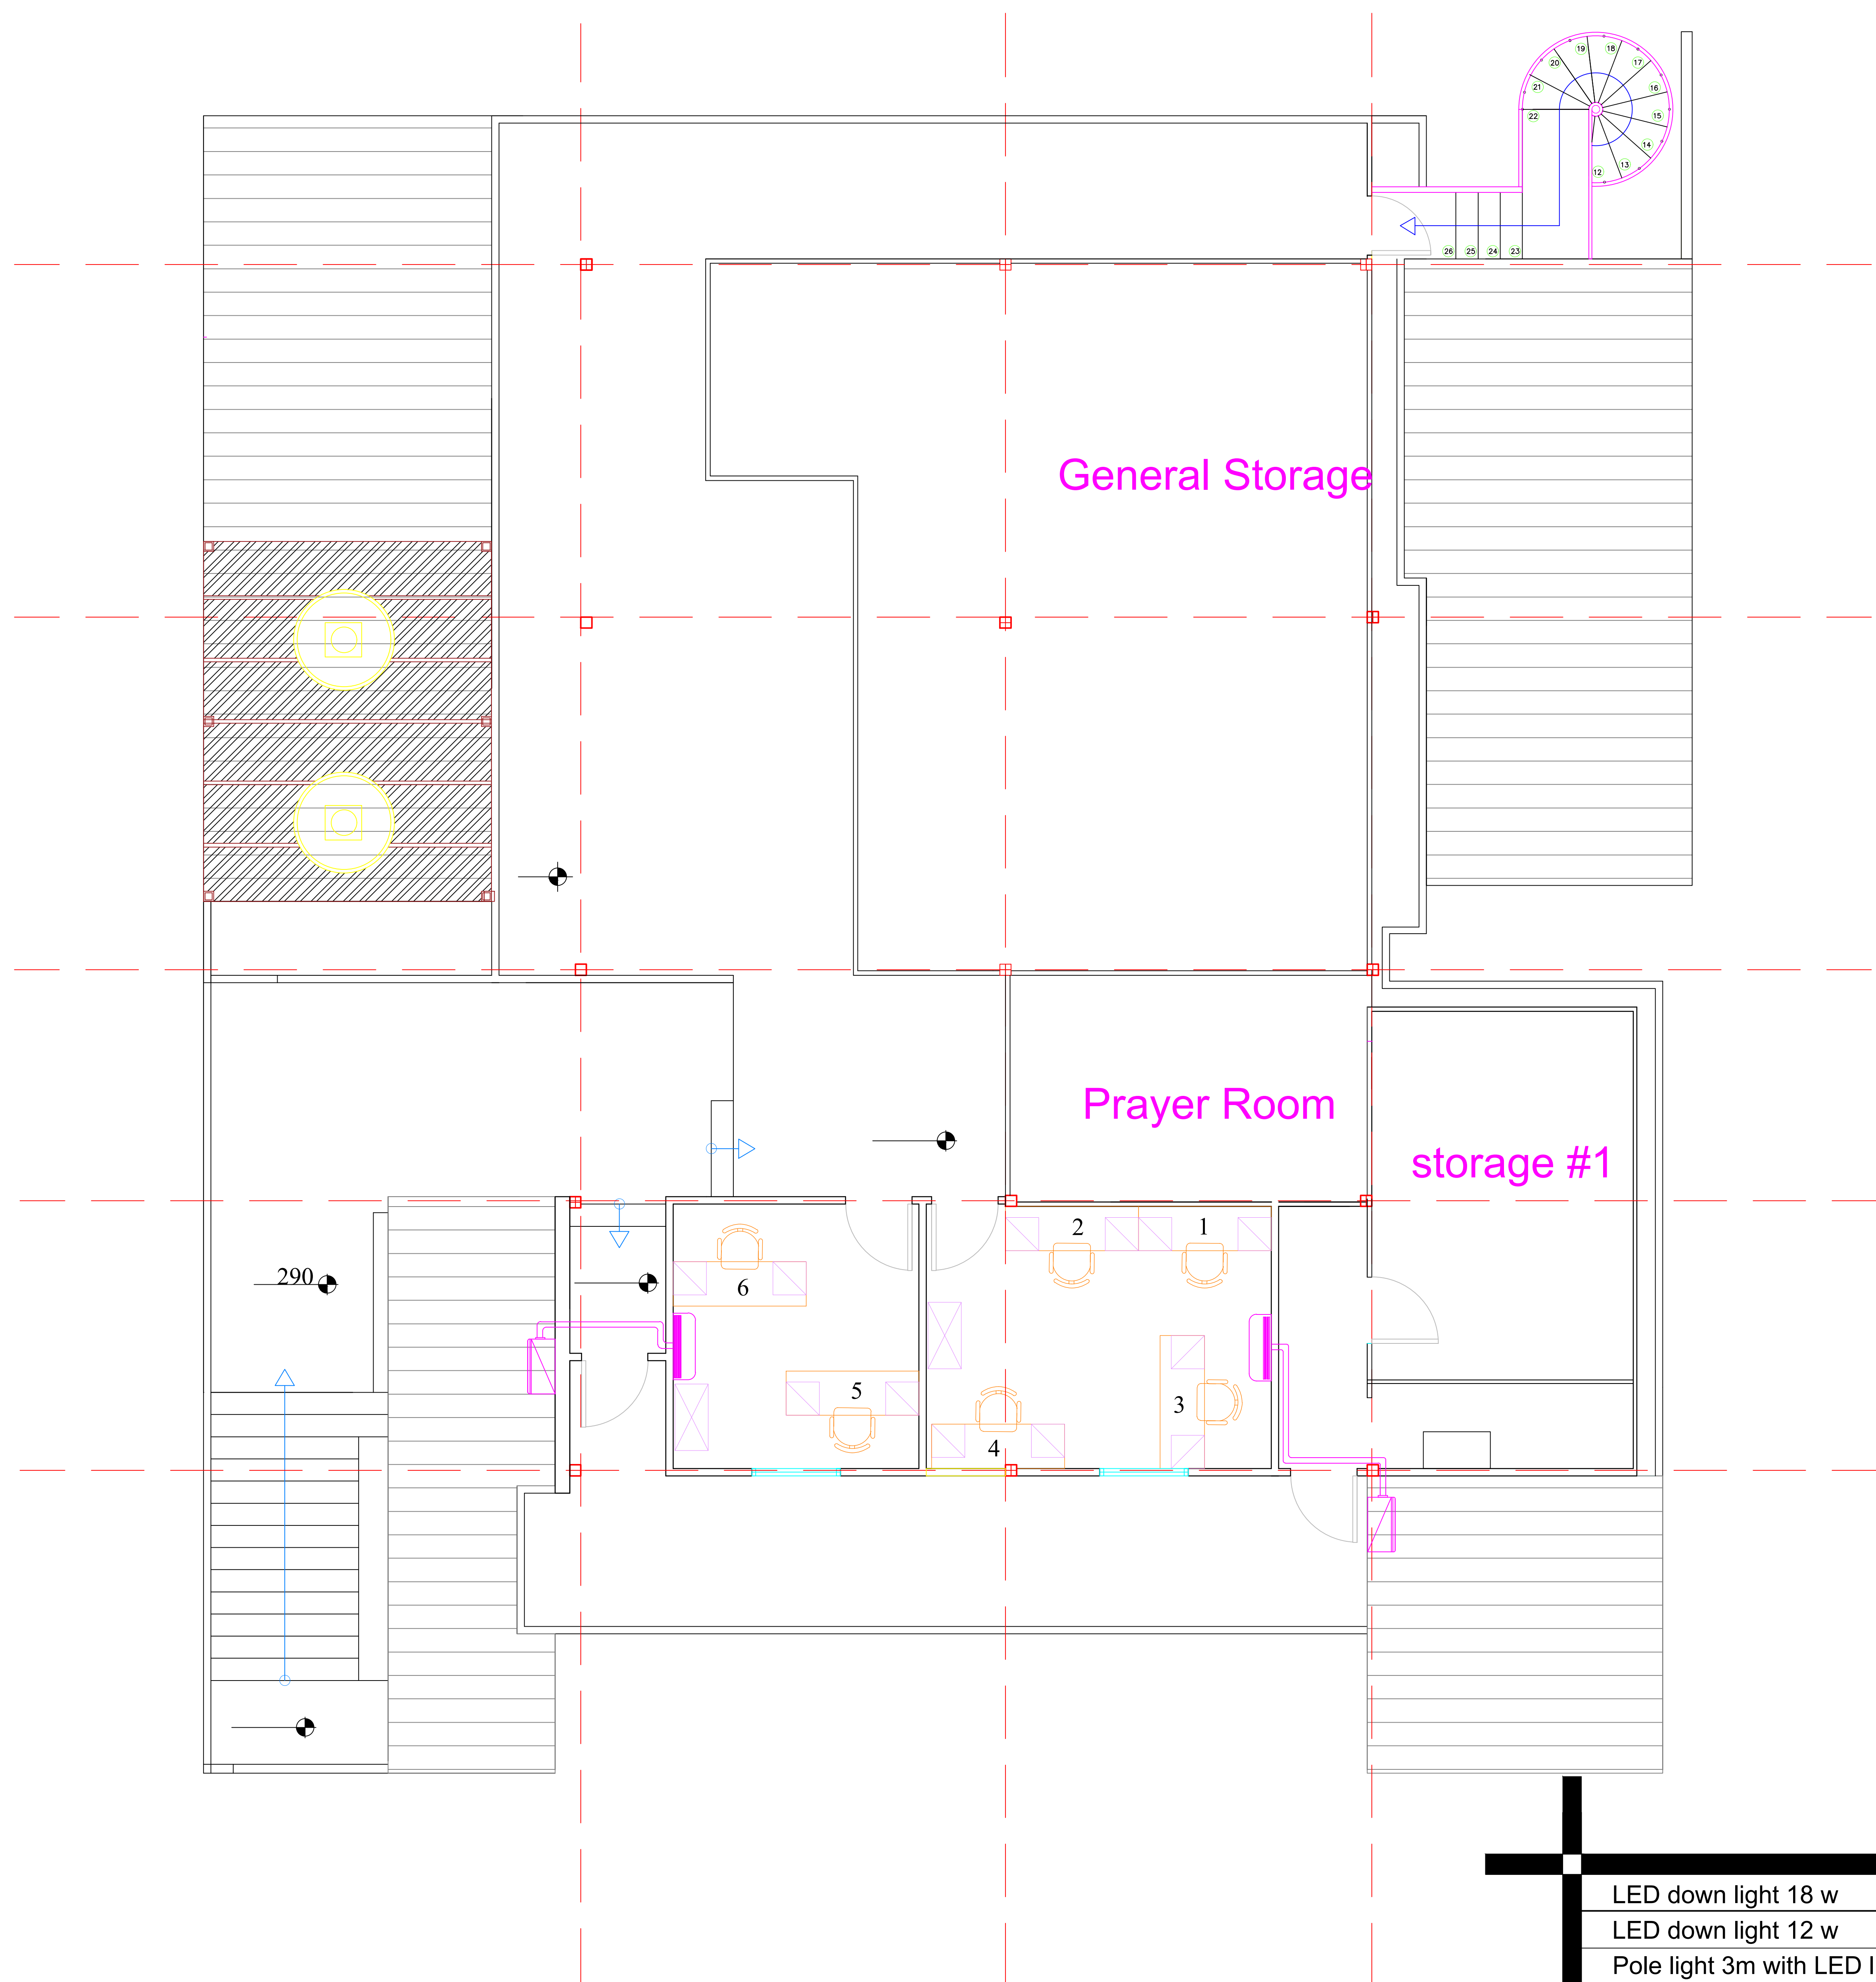

Air Conditioning plan - phase 1

LED down light 18 w	
LED down light 12 w	
Pole light 3m with LED light	
LED light 120cm with reflector	
LED Mirror light 12 w	
one way one gang switch	
one way two gang switch	
Two way one gang switch	
Push Button	
Single socket	
Double socket	
1 Ton A/c	
1.5 Ton A/c	
Pullet camera	
Dome camera	
Smoke detector	
Heat detector	
Sounder	
Automatic Fire extinguisher	
Fire extinguisher	
Break glass	
TV Outlet	
Telephone Outlet	
Data Outlet	



Eng. Khaled Al Jammal
project manager

E-mail: khjammal@hotmail.com
Damascus , Syria

Proposal : 1st floor plan
scale : to fit

Project Name
UNFPA new floor in Damascus

Sheet Size
A3

Date : 27/8/2018