 
 
 


 

 
 

 
 

 





 

 
 
 


Drawing NO.	Title - phase 2
Arc 1 - phase 2	Current Situation Plan
Arc 2 - phase 2	proposed plan
Arc 3 - phase 2	Walls to be moved
Arc 4 - phase 2	Details
Arc 5 - phase 2	Windows Details
Arc 6 - phase 2	Doors Details
Ele 1 - phase 2	CCTV CAMERAS
Ele 2 - phase 2	lighting plan
Ele 3 - phase 2	Power Plans
Ele 4 - phase 2	Points Location
Ele 6 - phase 2	Electrical Details
Mec 1- phase 2	Fire extinguisher and Alarm system
Mec 2- phase 2	Air Conditioning plan
Mec 3- phase 2	Wast Water System
Mec 4- phase 2	Utility Water System
Mec 5- phase 2	Ventilation for Bathrooms and buffet

Drawing Board - phase 2

LED down light 18 w	
LED down light 12 w	
Pole light 3m with LED light	
LED light 120cm with reflector	
LED Mirror light 12 w	
one way one gang switch	
one way two gang switch	
Two way one gang switch	
Push Button	
Single socket	
Double socket	
1 Ton A/c	
1.5 Ton A/c	
Pullet camera	
Dome camera	
Smoke detector	
Heat detector	
Sounder	
Automatic Fire extinguisher	
Fire extinguisher	
Break glass	
TV Outlet	
Telephone Outlet	
Data Outlet	



Eng. Khaled Al Jammal
project manager


E-mail: khjammal@hotmail.com
Damascus , Syria

Proposal : 1st floor plan
scale : to fit

Project Name
UNFPA new floor in Damascus

Date : 27/8/2018

Sheet Size
A3

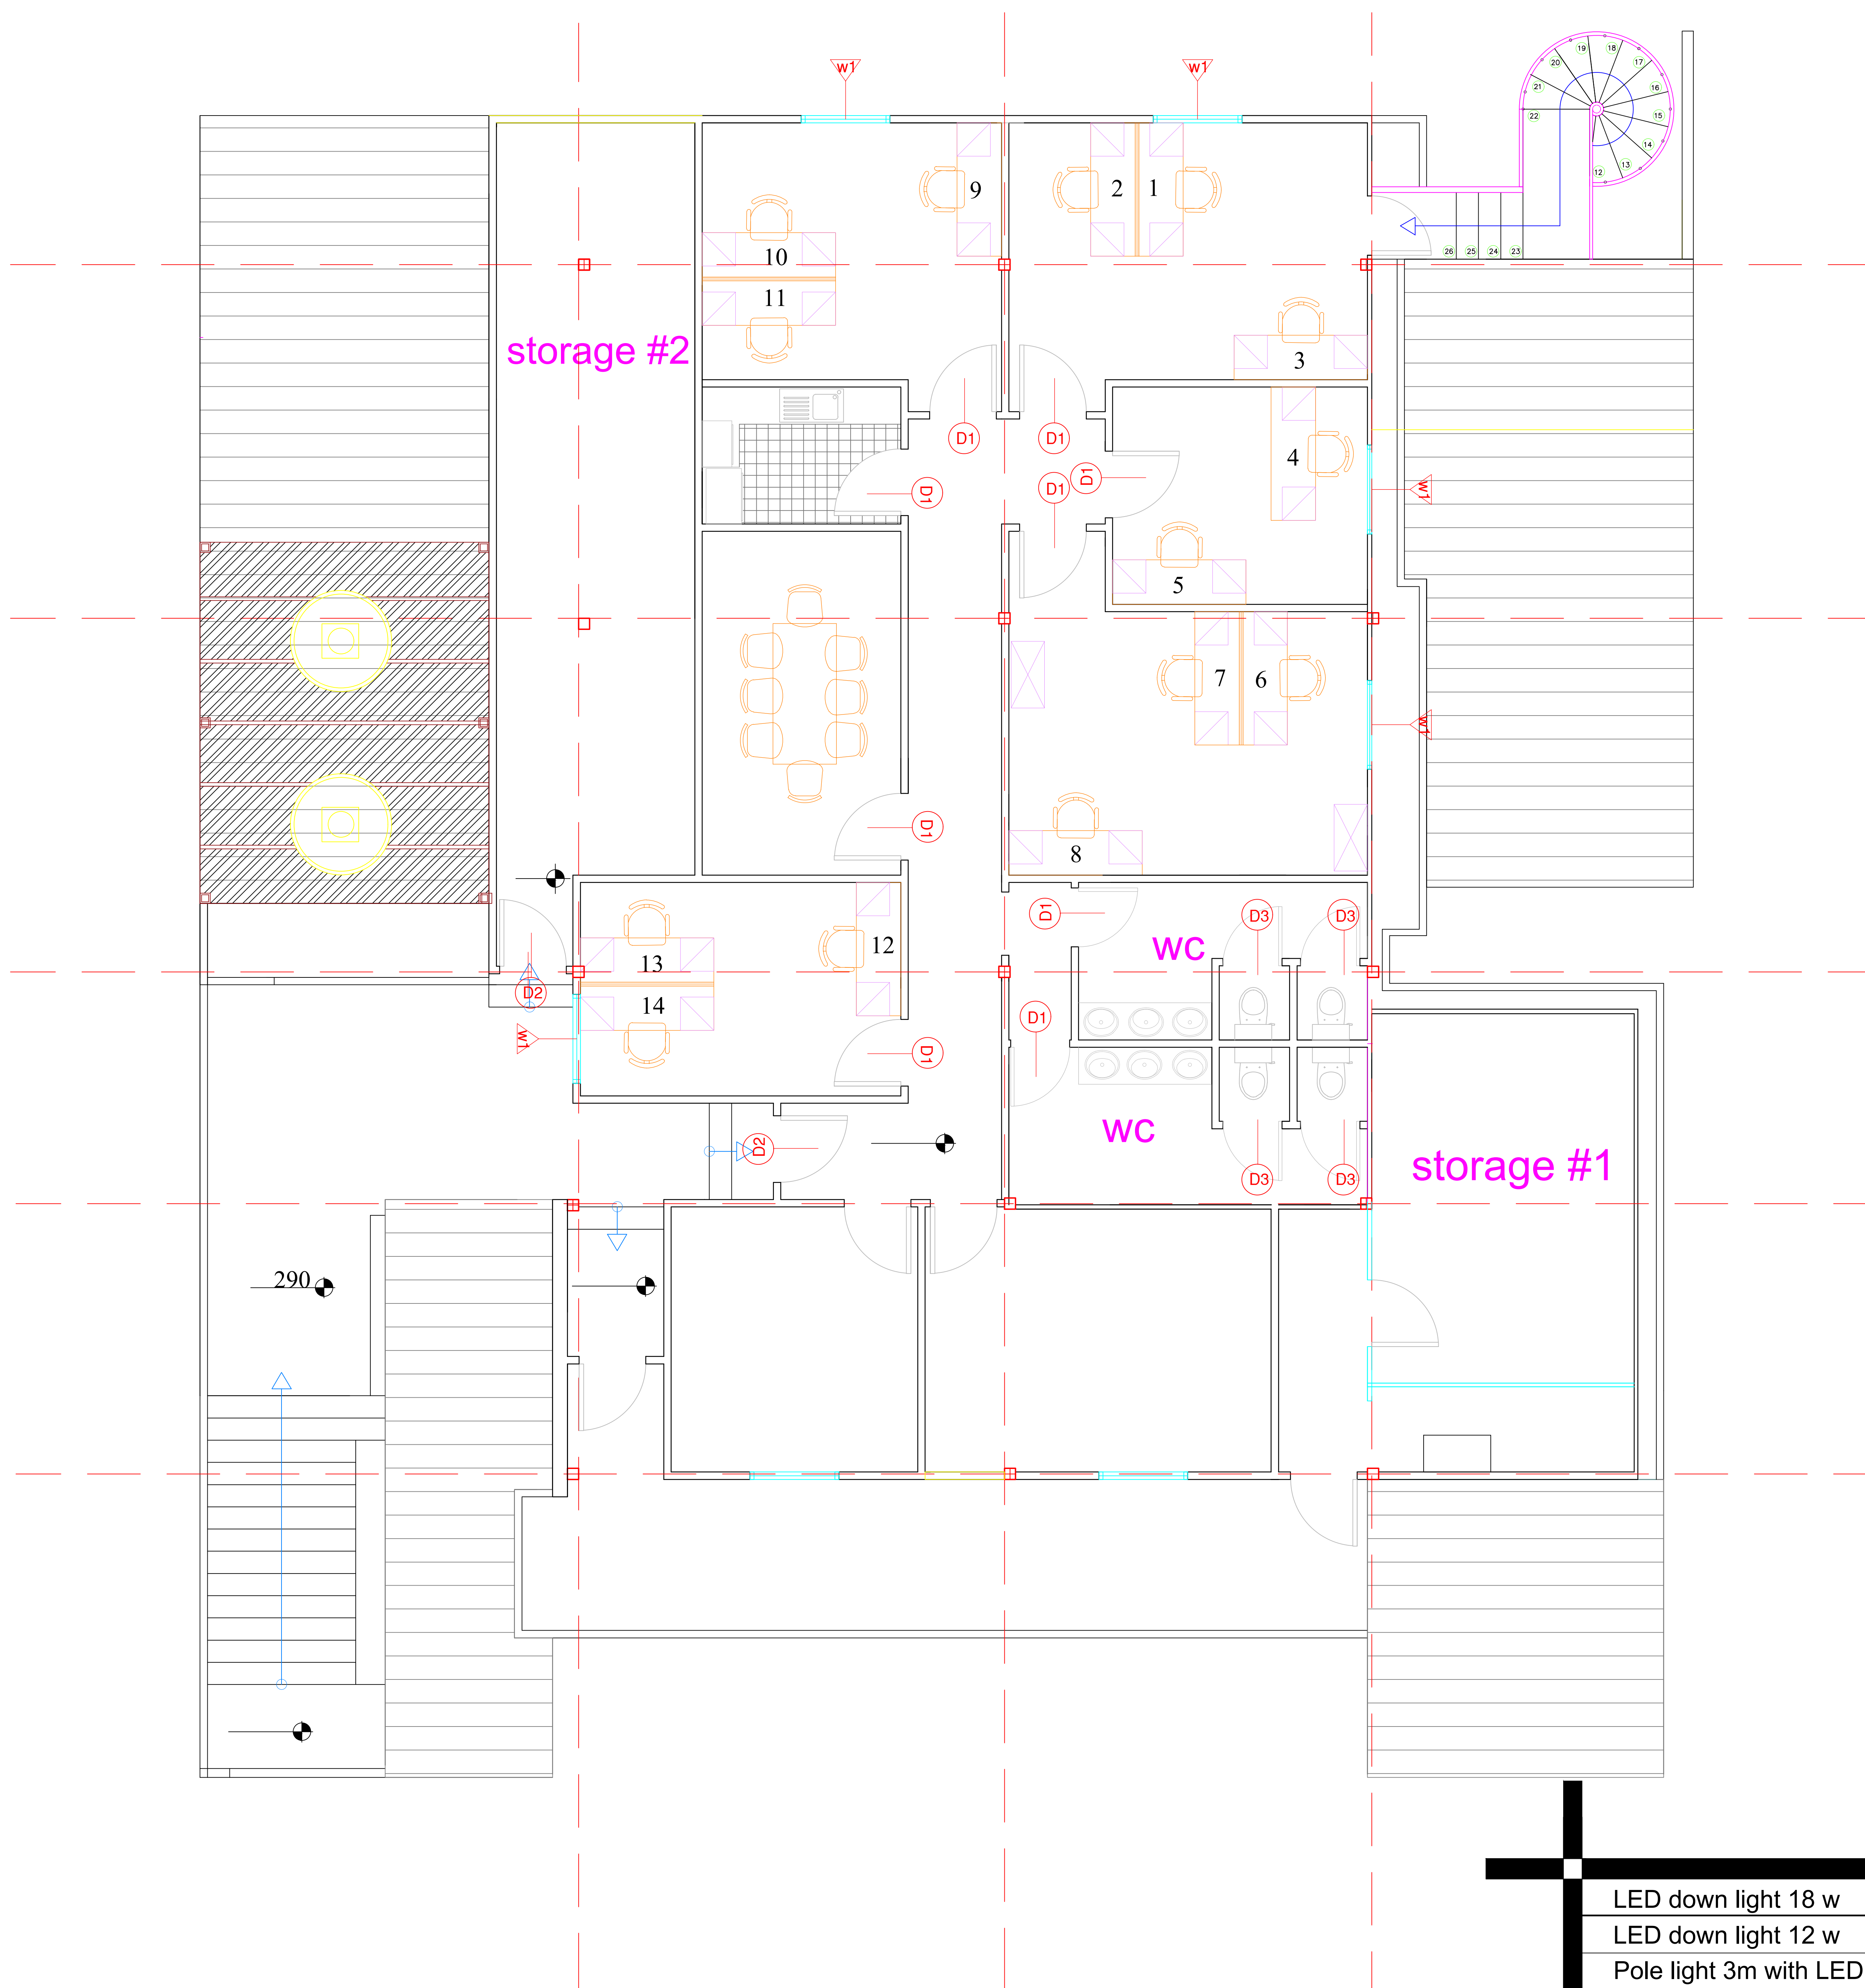

proposed plan - phase 2

LED down light 18 w	
LED down light 12 w	
Pole light 3m with LED light	
LED light 120cm with reflector	
LED Mirror light 12 w	
one way one gang switch	
one way two gang switch	
Two way one gang switch	
Push Button	
Single socket	
Double socket	
1 Ton A/c	
1.5 Ton A/c	
Pullet camera	
Dome camera	
Smoke detector	
Heat detector	
Sounder	
Automatic Fire extinguisher	
Fire extinguisher	
Break glass	
TV Outlet	
Telephone Outlet	
Data Outlet	



Eng. Khaled Al Jammal
project manager



E-mail: khjammal@hotmail.com
Damascus , Syria

Proposal : 1st floor plan
scale : to fit

Project Name
UNFPA new floor in Damascus

Sheet Size
A3

Date : 27/8/2018

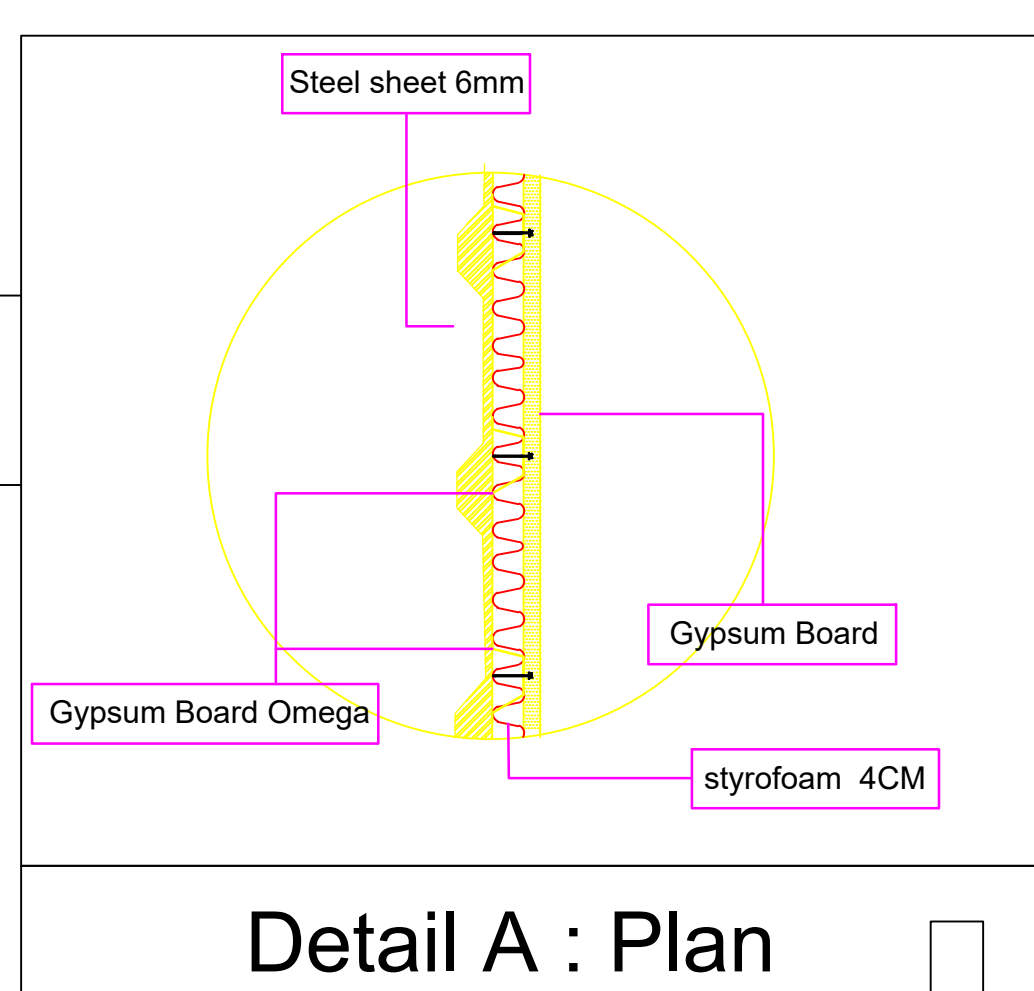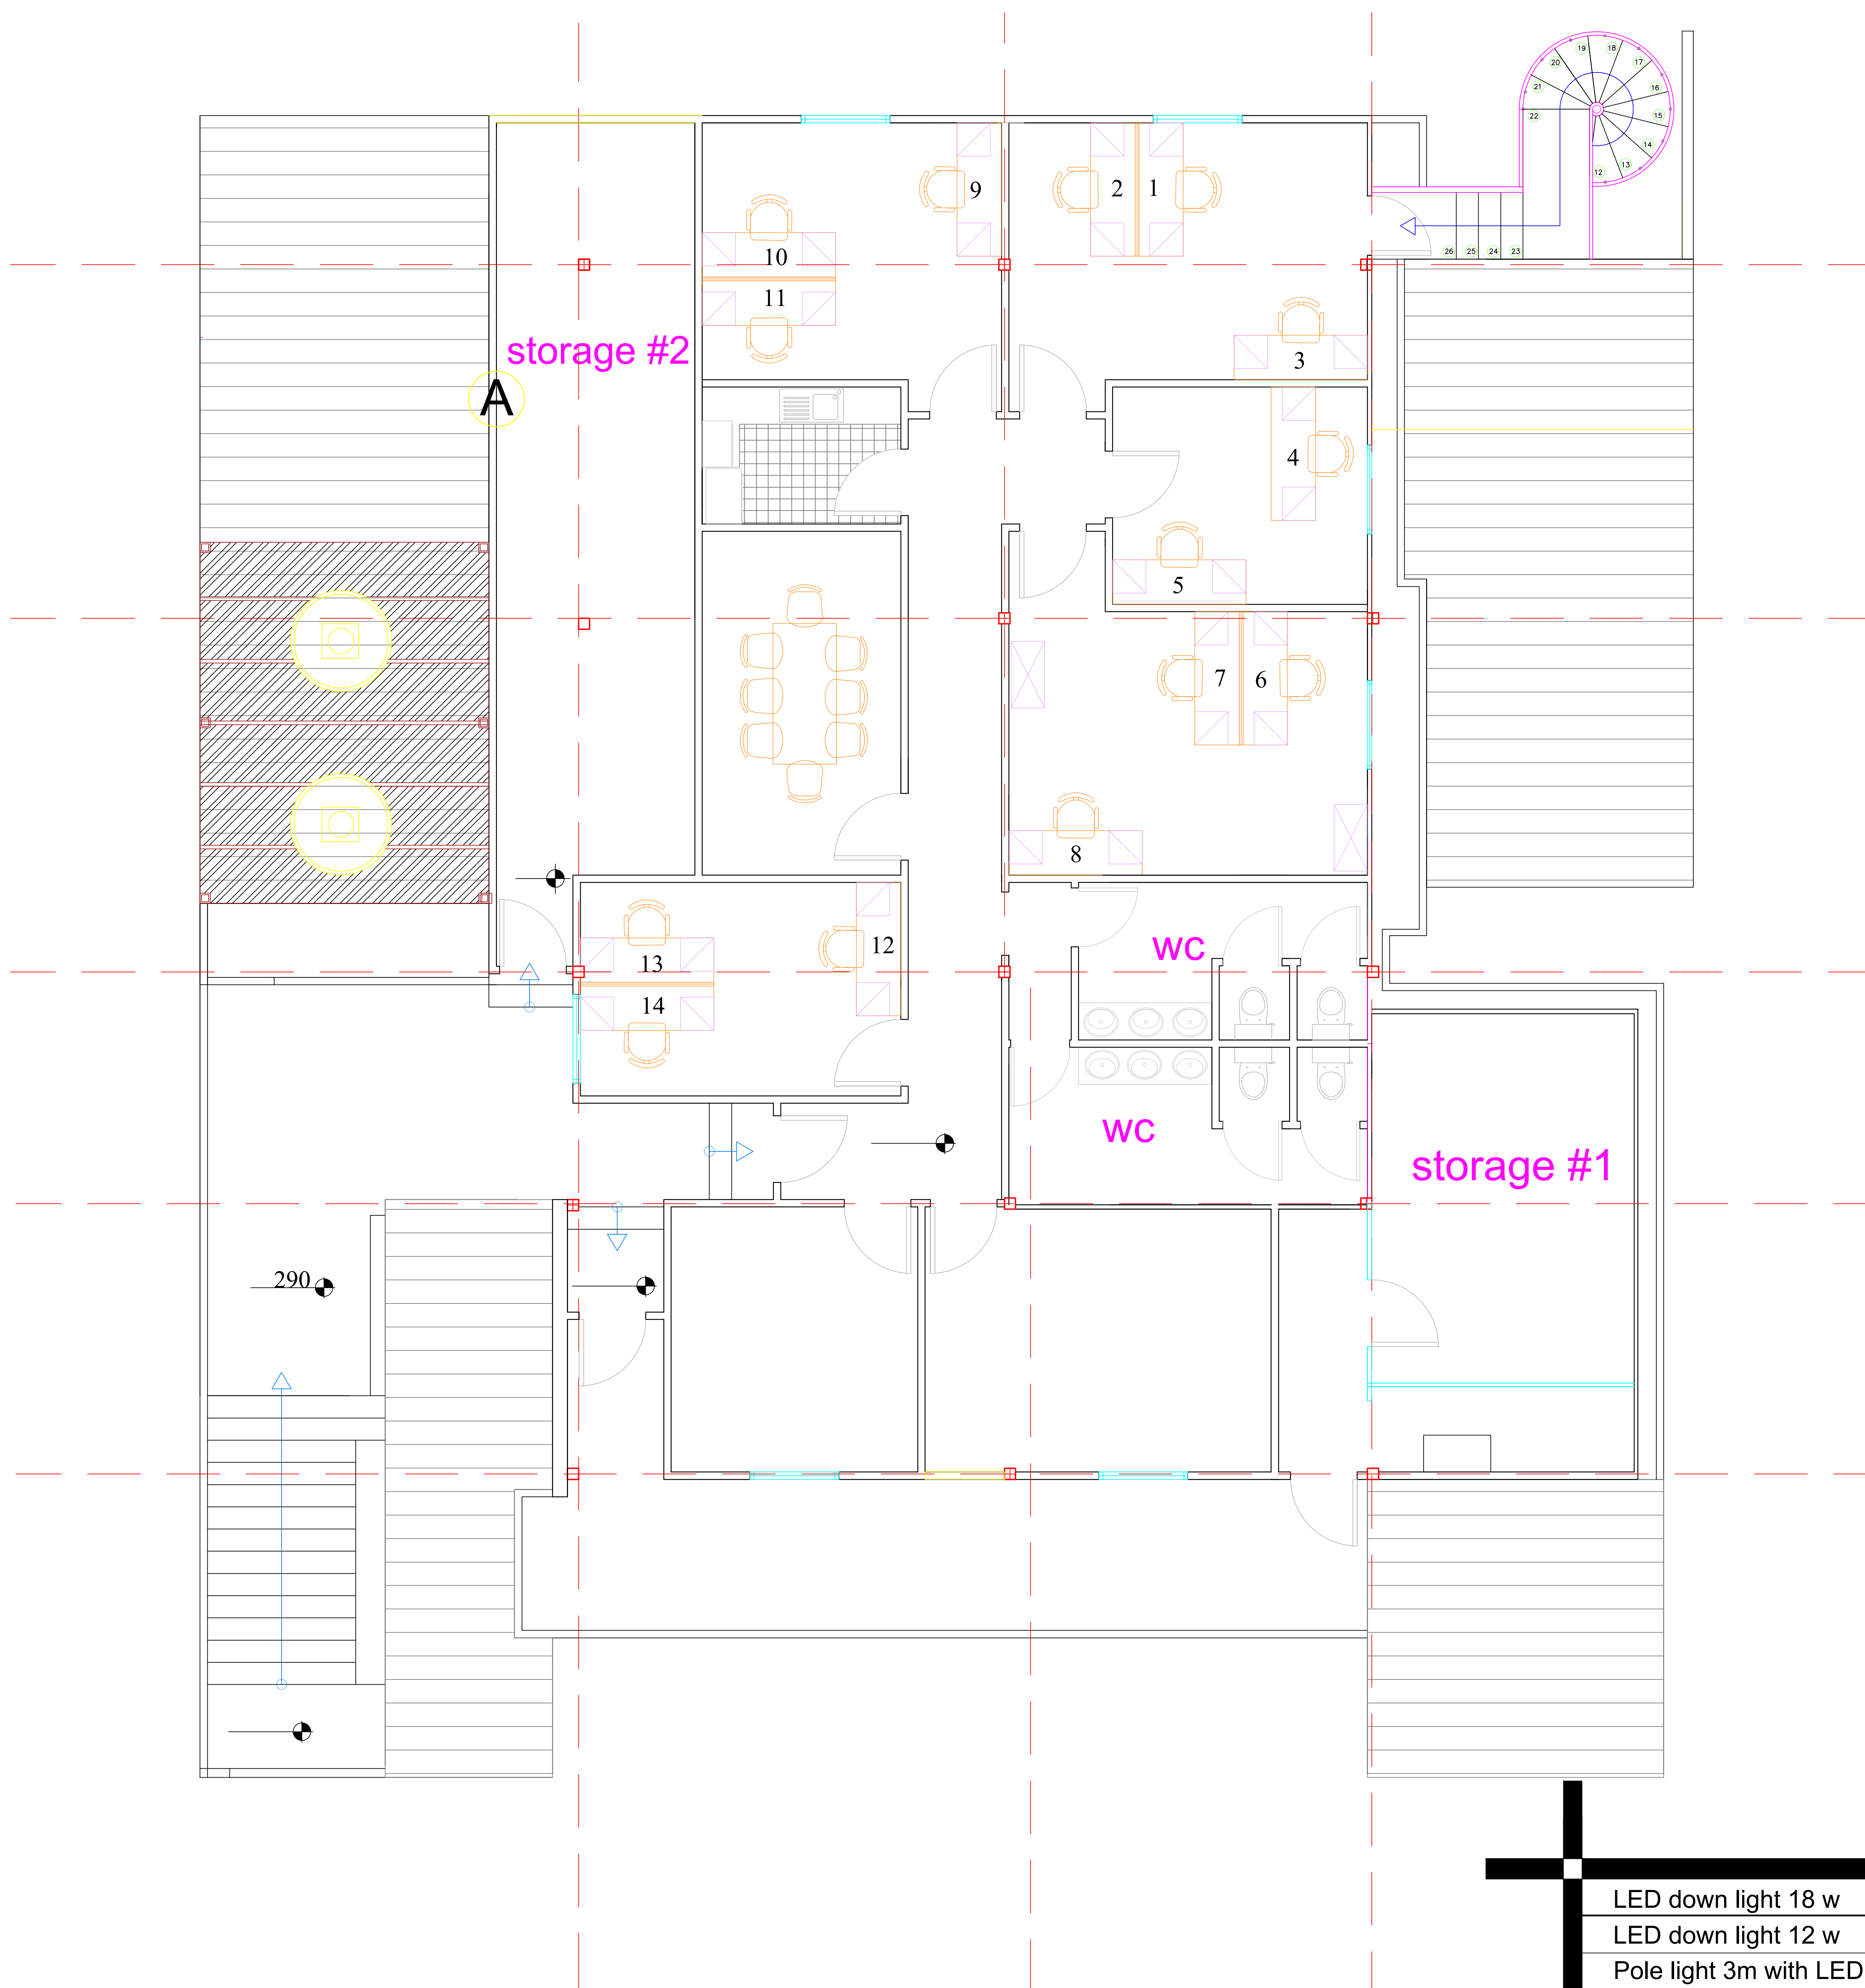

Details - phase 2

LED down light 18 w	
LED down light 12 w	
Pole light 3m with LED light	
LED light 120cm with reflector	
LED Mirror light 12 w	
one way one gang switch	
one way two gang switch	
Two way one gang switch	
Push Button	
Single socket	
Double socket	
1 Ton A/c	
1.5 Ton A/c	
Pullet camera	
Dome camera	
Smoke detector	
Heat detector	
Sounder	
Automatic Fire extinguisher	
Fire extinguisher	
Break glass	
TV Outlet	
Telephone Outlet	
Data Outlet	



Eng. Khaled Al Jammal
project manager



E-mail: khjammal@hotmail.com
Damascus , Syria

Proposal : 1st floor plan
scale : to fit

Project Name
UNFPA new floor in Damascus

Sheet Size
A3

Date : 27/8/2018

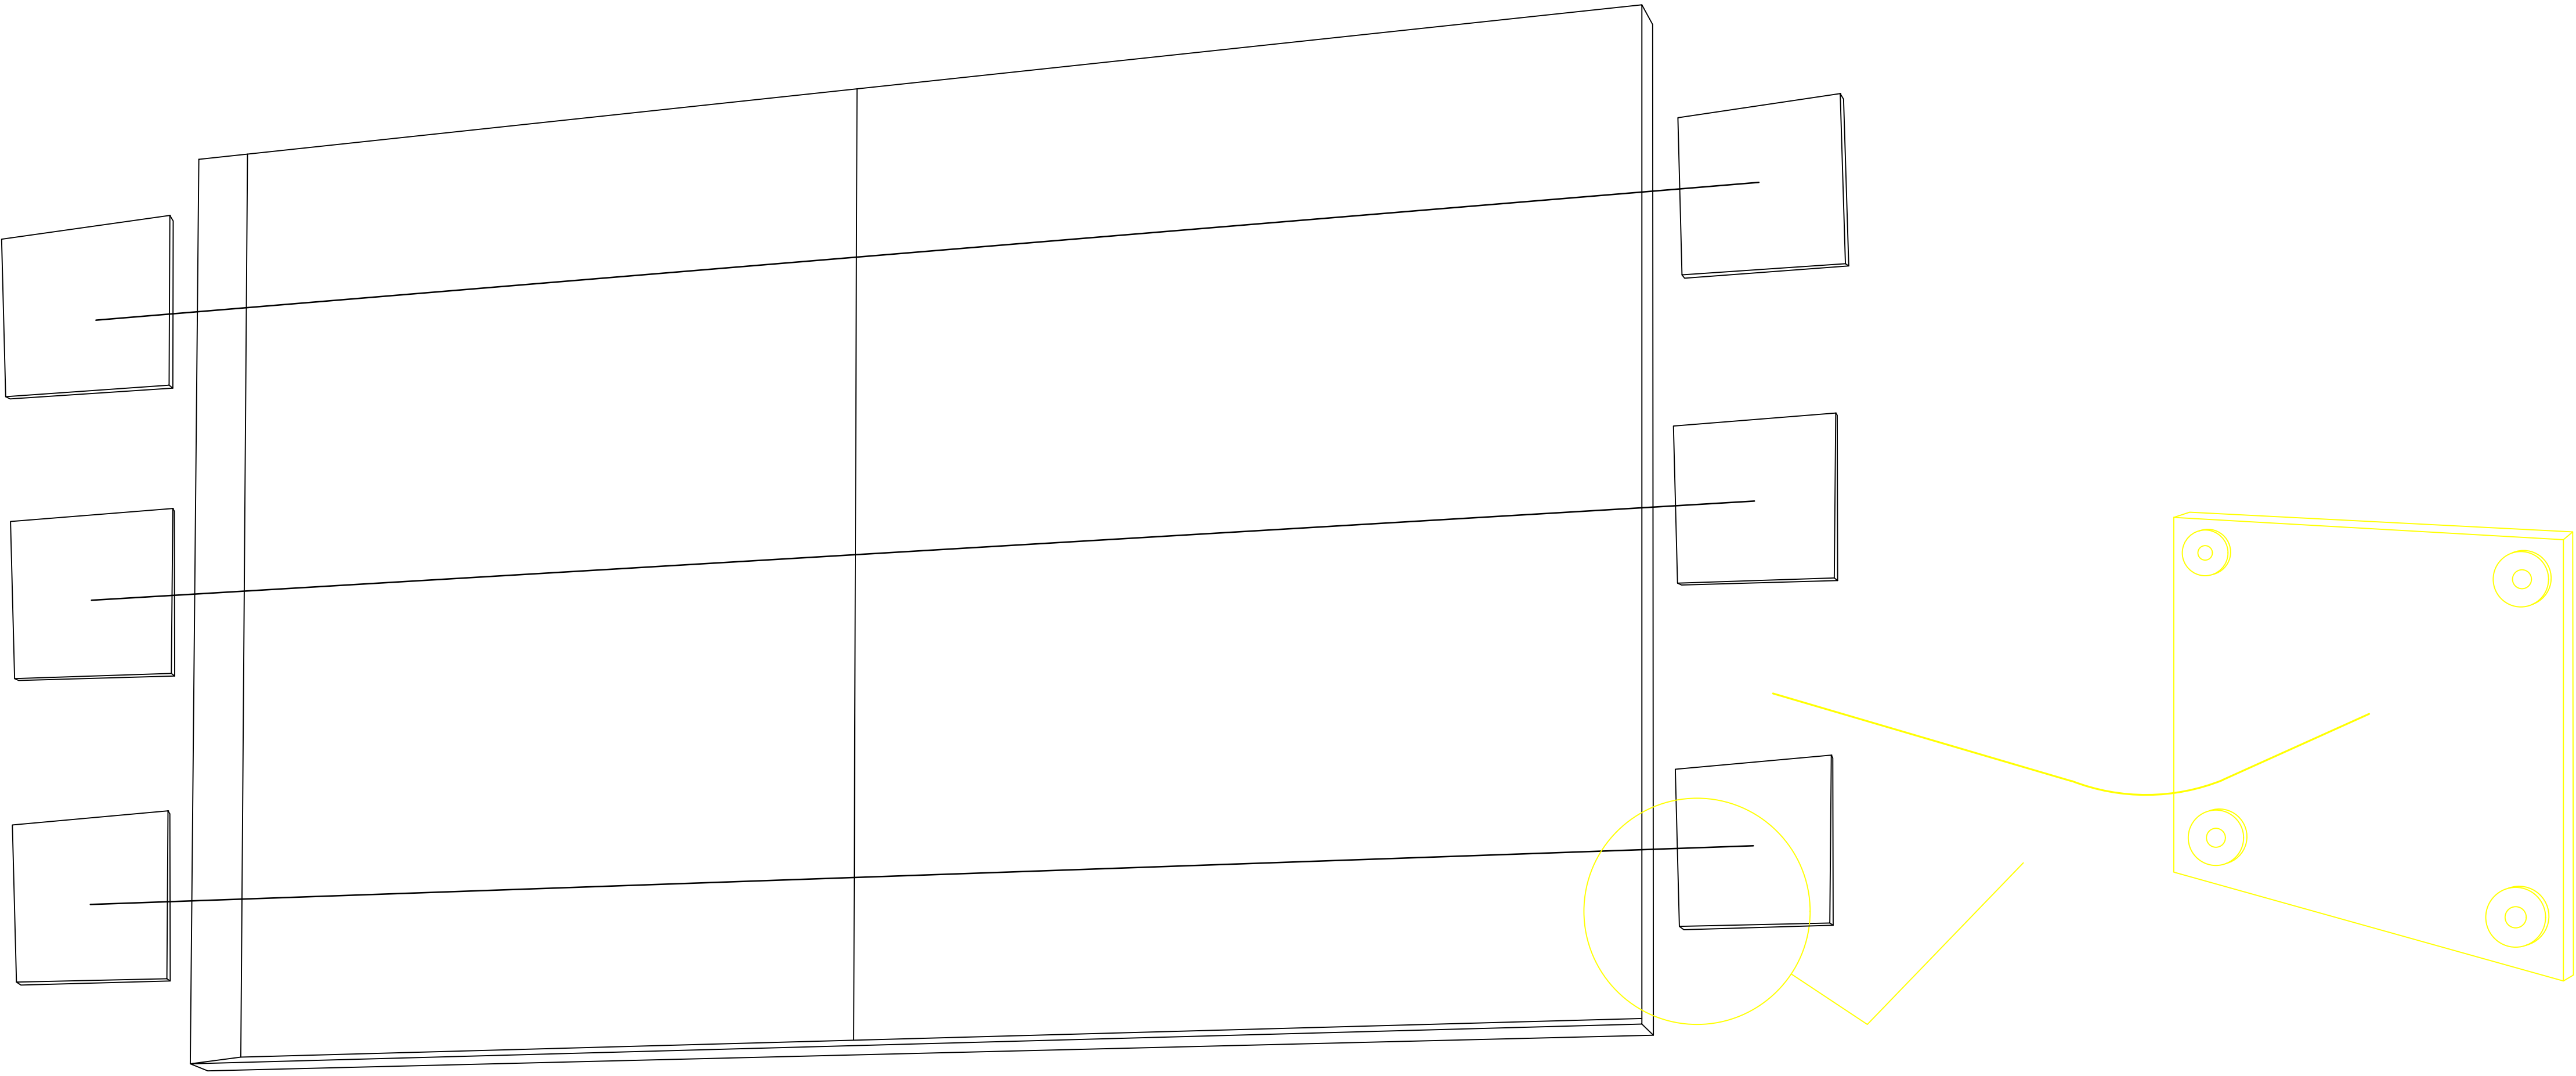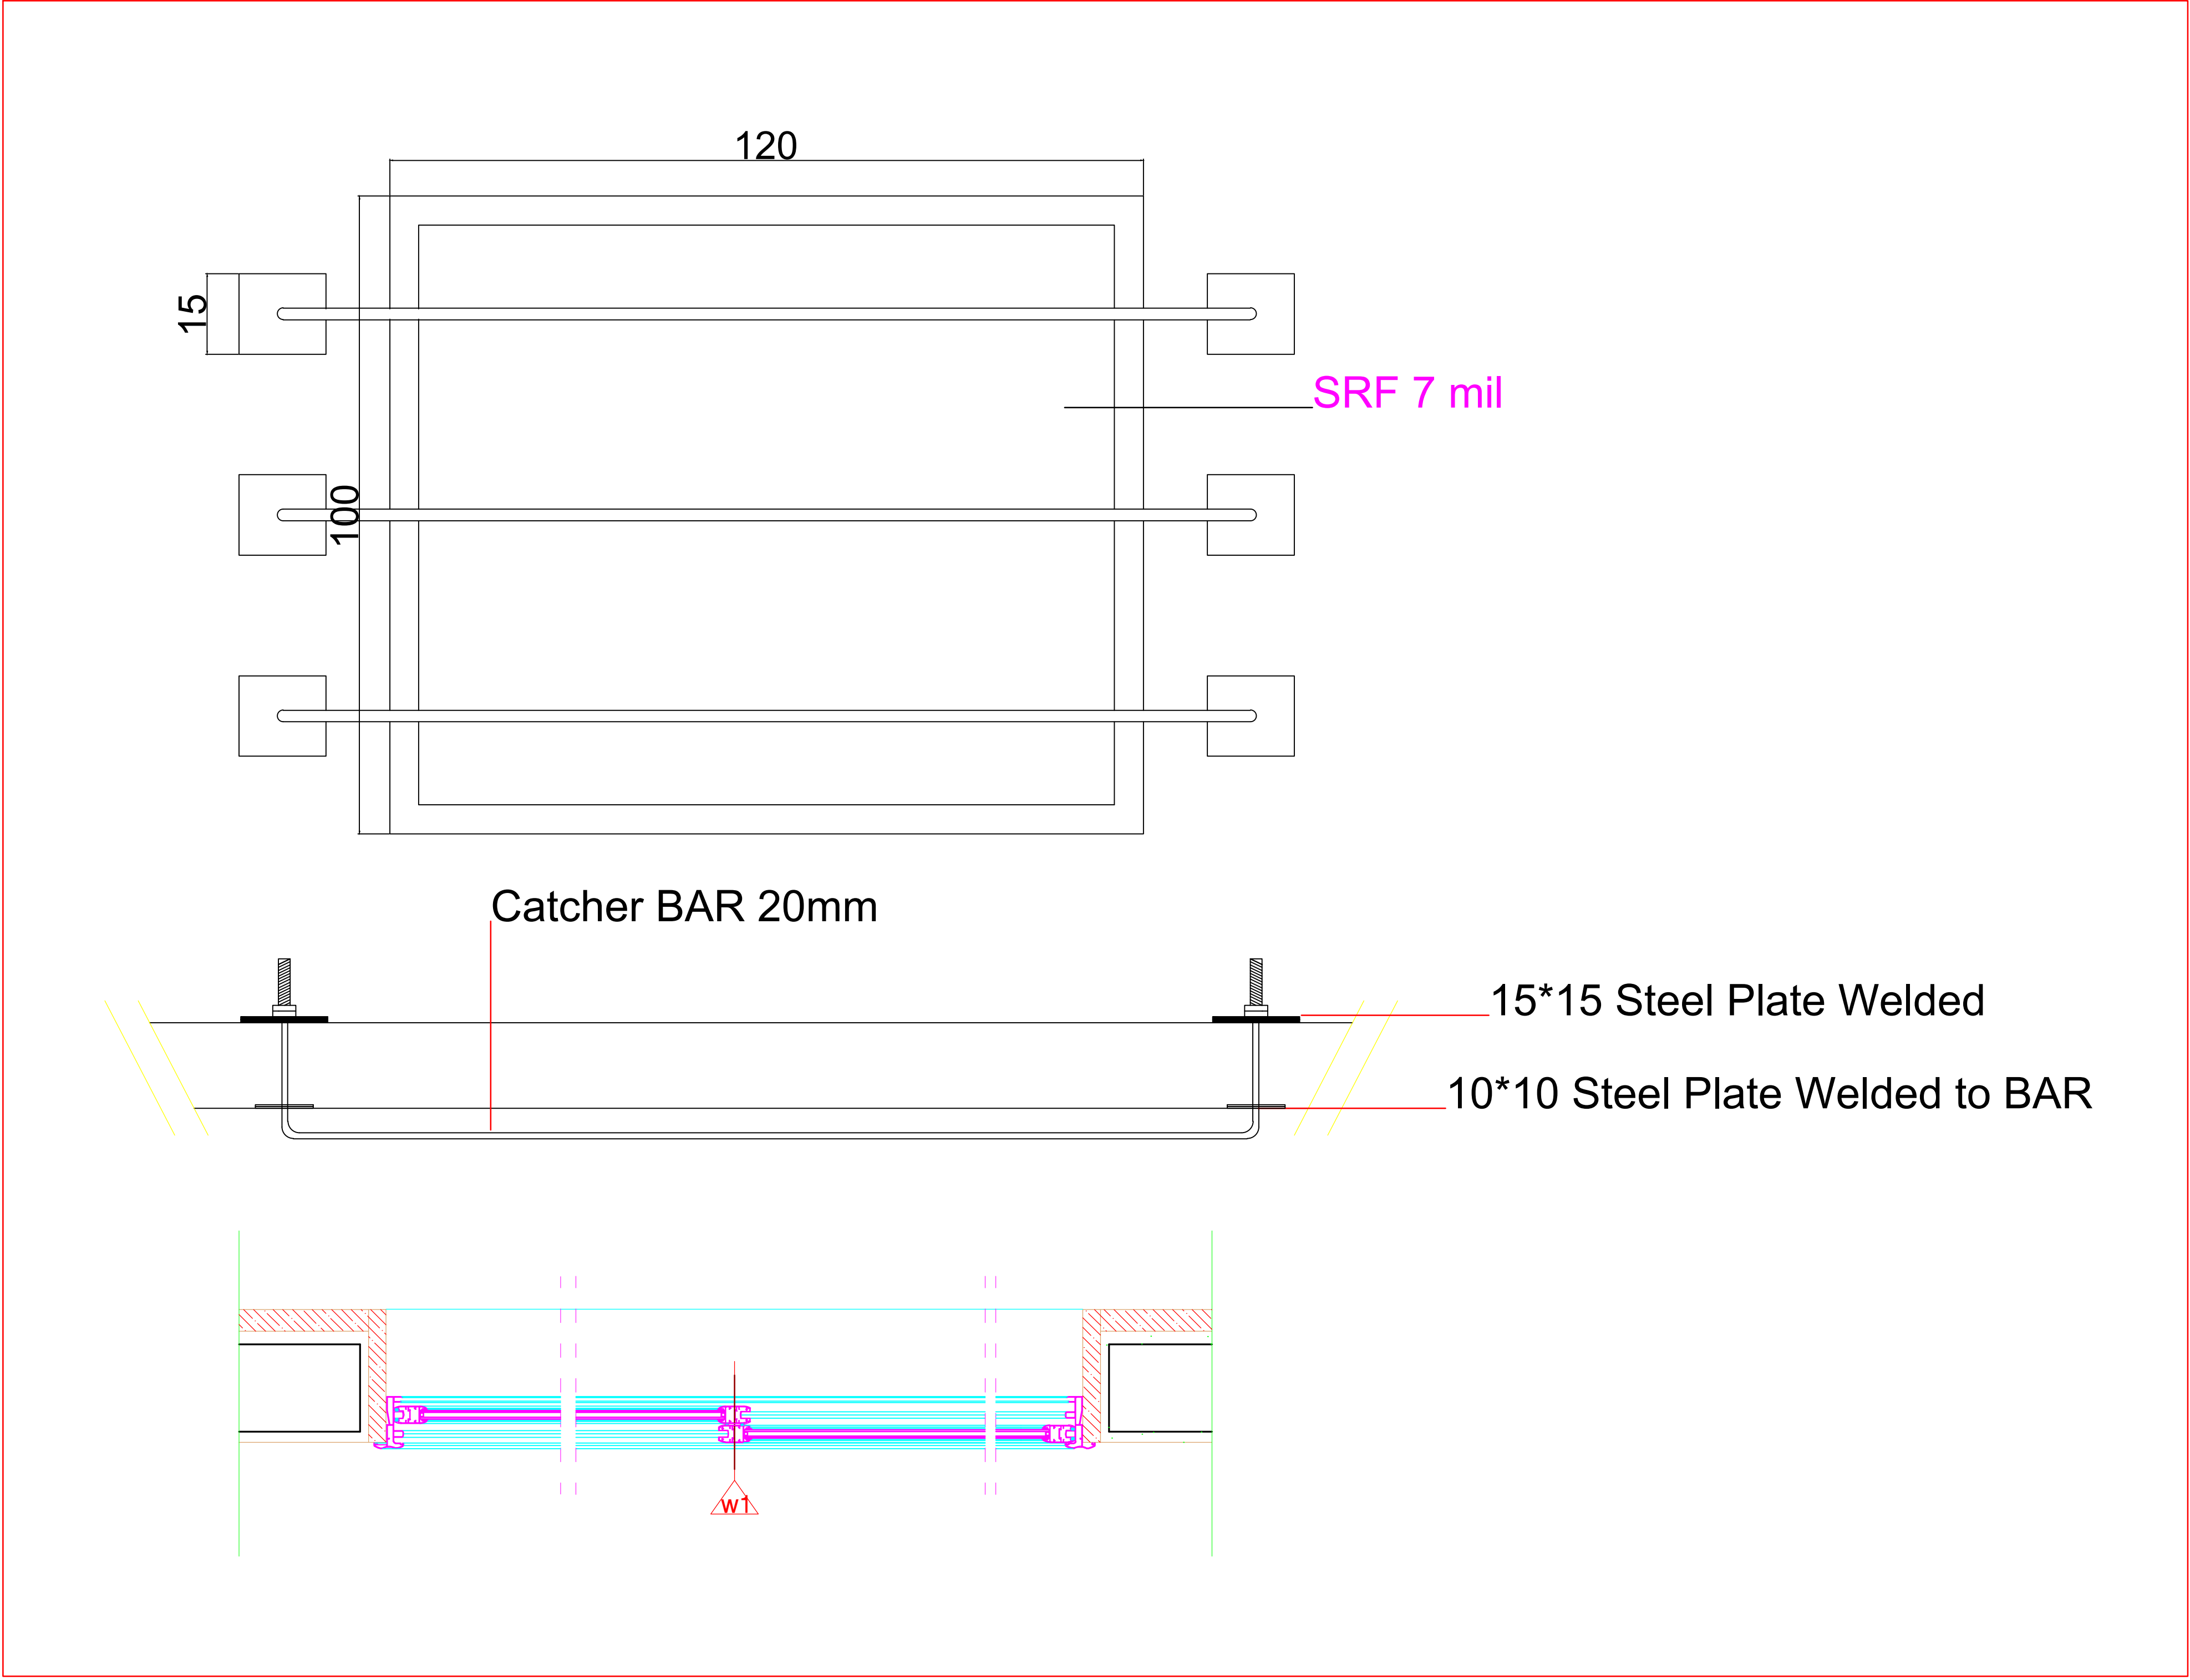

Window	Qty	W (CM)	H (CM)
W1	5	120	100

LED down light 18 w	
LED down light 12 w	
Pole light 3m with LED light	
LED light 120cm with reflector	
LED Mirror light 12 w	
one way one gang switch	
one way two gang switch	
Two way one gang switch	
Push Button	
Single socket	
Double socket	
1 Ton A/c	
1.5 Ton A/c	
Pullet camera	
Dome camera	
Smoke detector	
Heat detector	
Sounder	
Automatic Fire extinguisher	
Fire extinguisher	
Break glass	
TV Outlet	
Telephone Outlet	
Data Outlet	

Windows Details - phase 2



Eng. Khaled Al Jammal
project manager




E-mail: khjammal@hotmail.com
Damascus , Syria

Proposal : 1st floor plan
scale : to fit

Project Name
UNFPA new floor in Damascus

Sheet Size
A3

Date : 27/8/2018

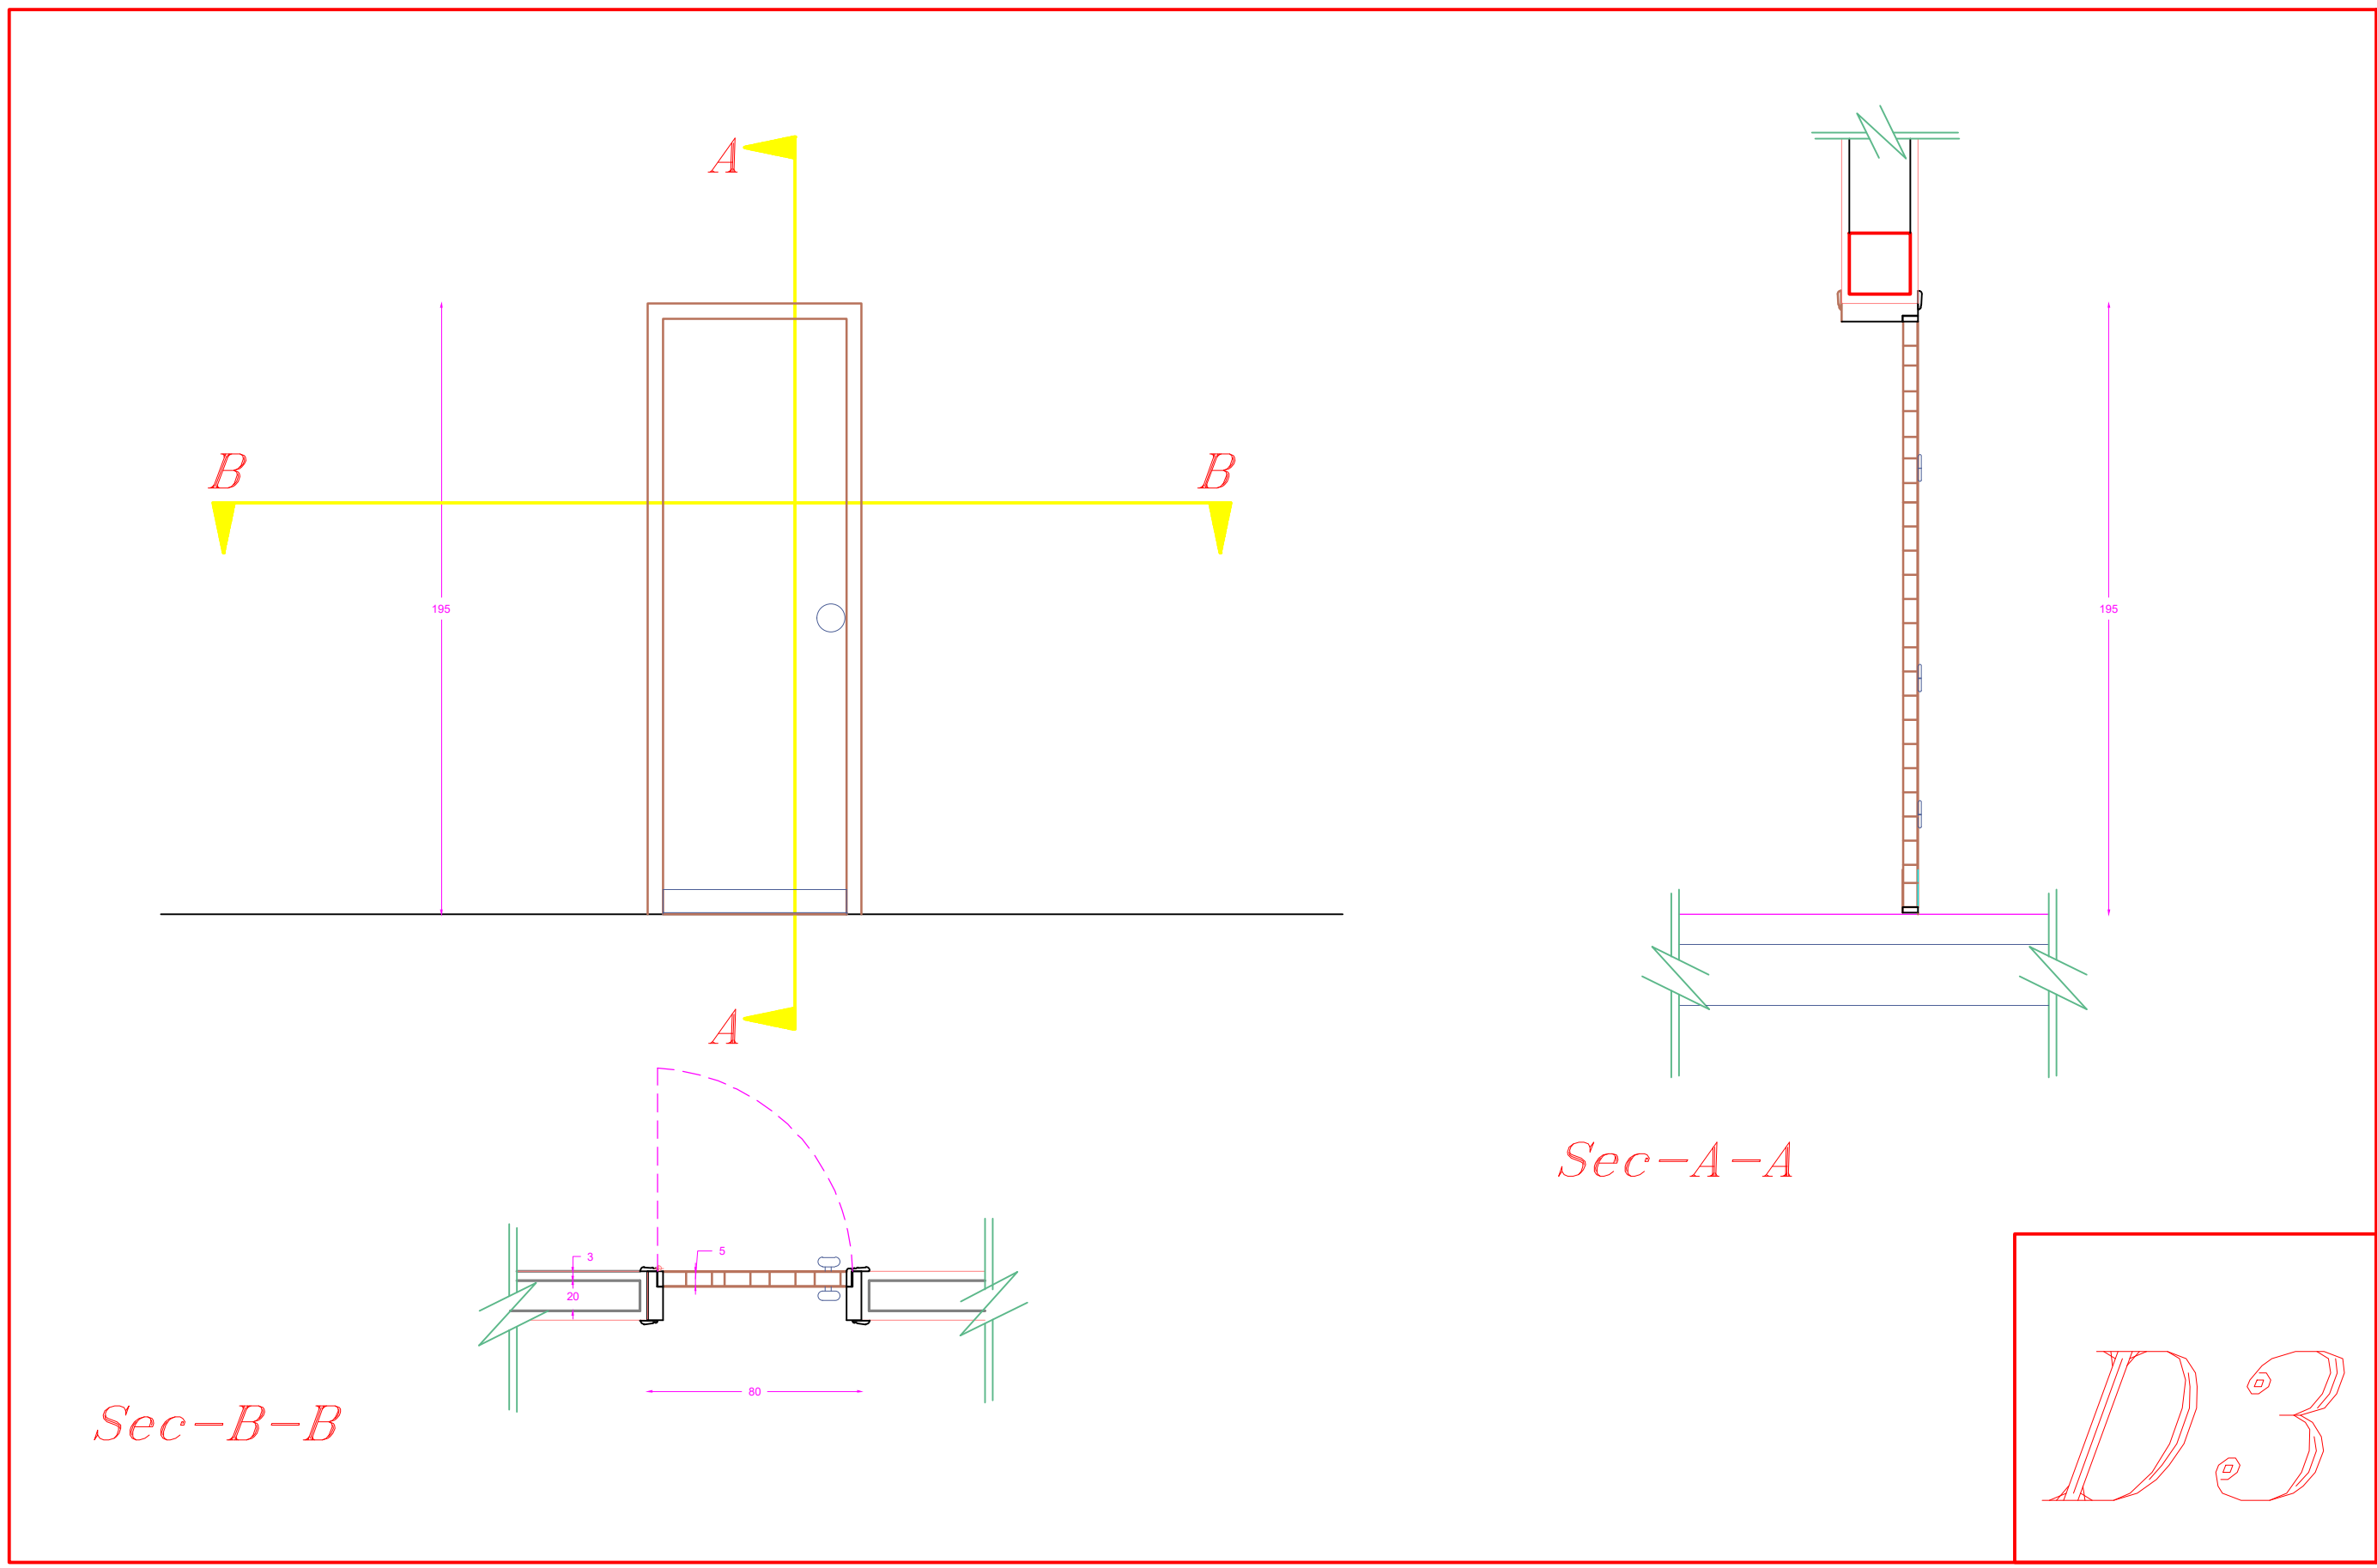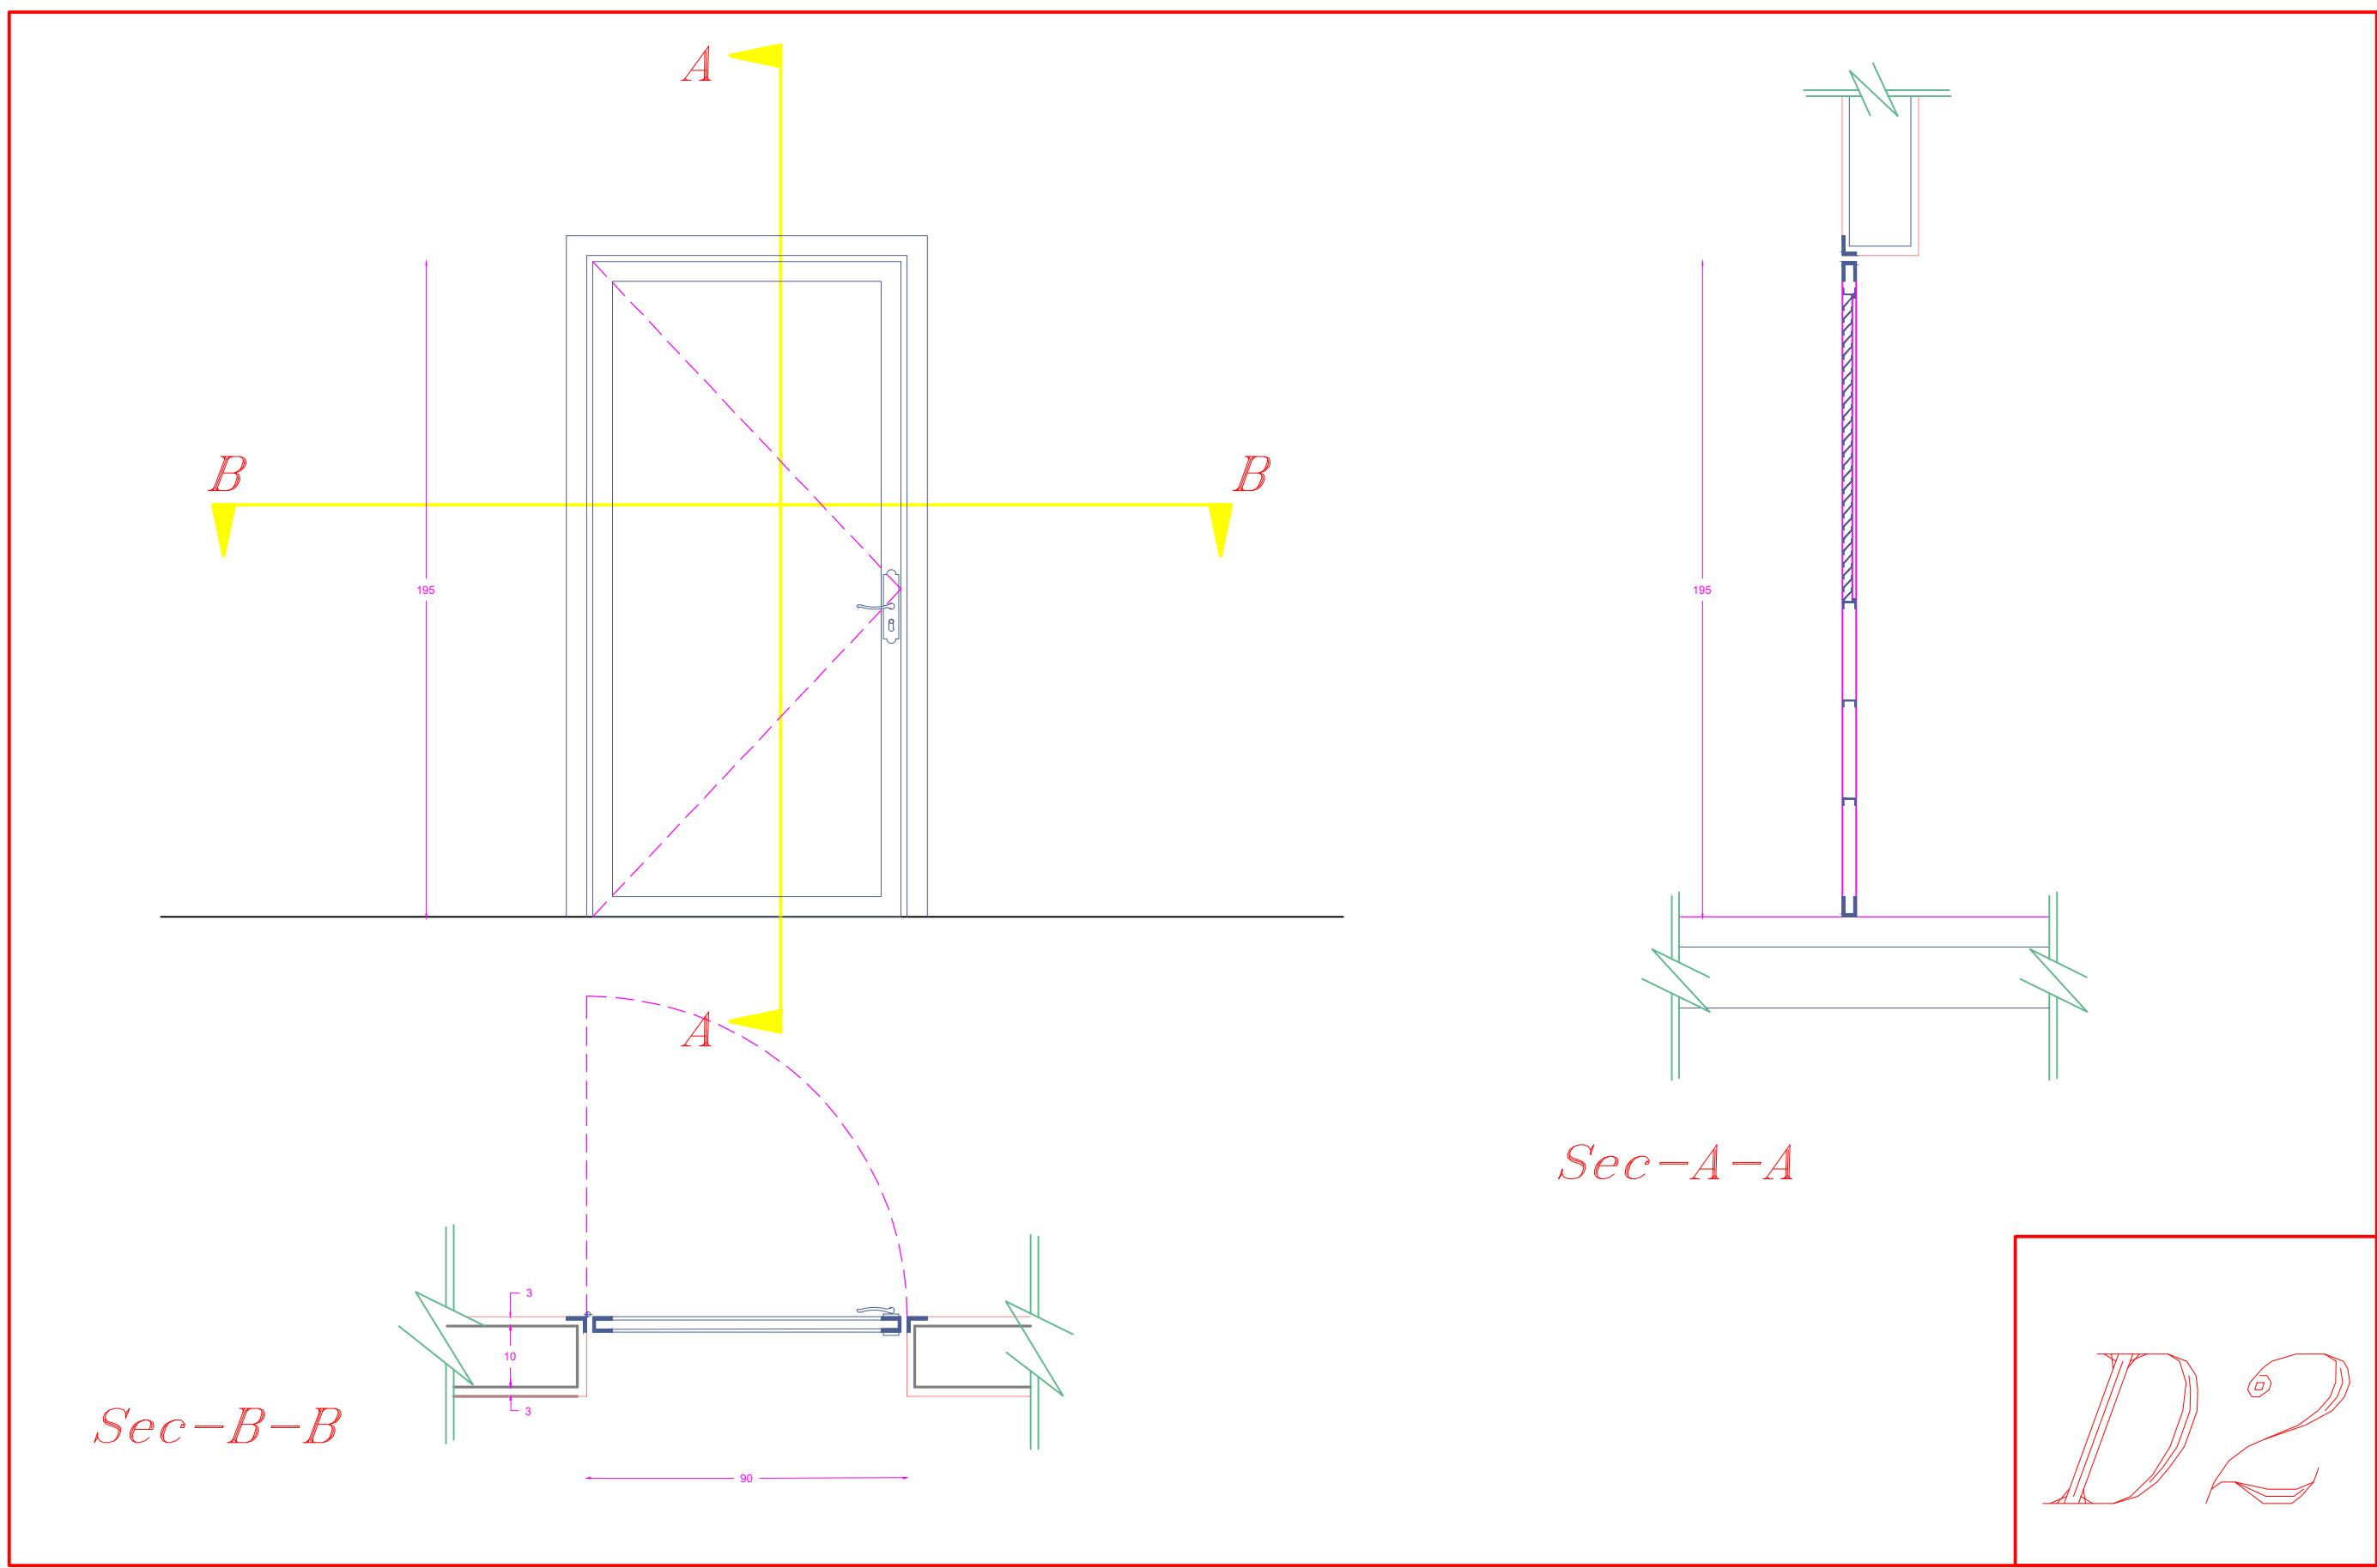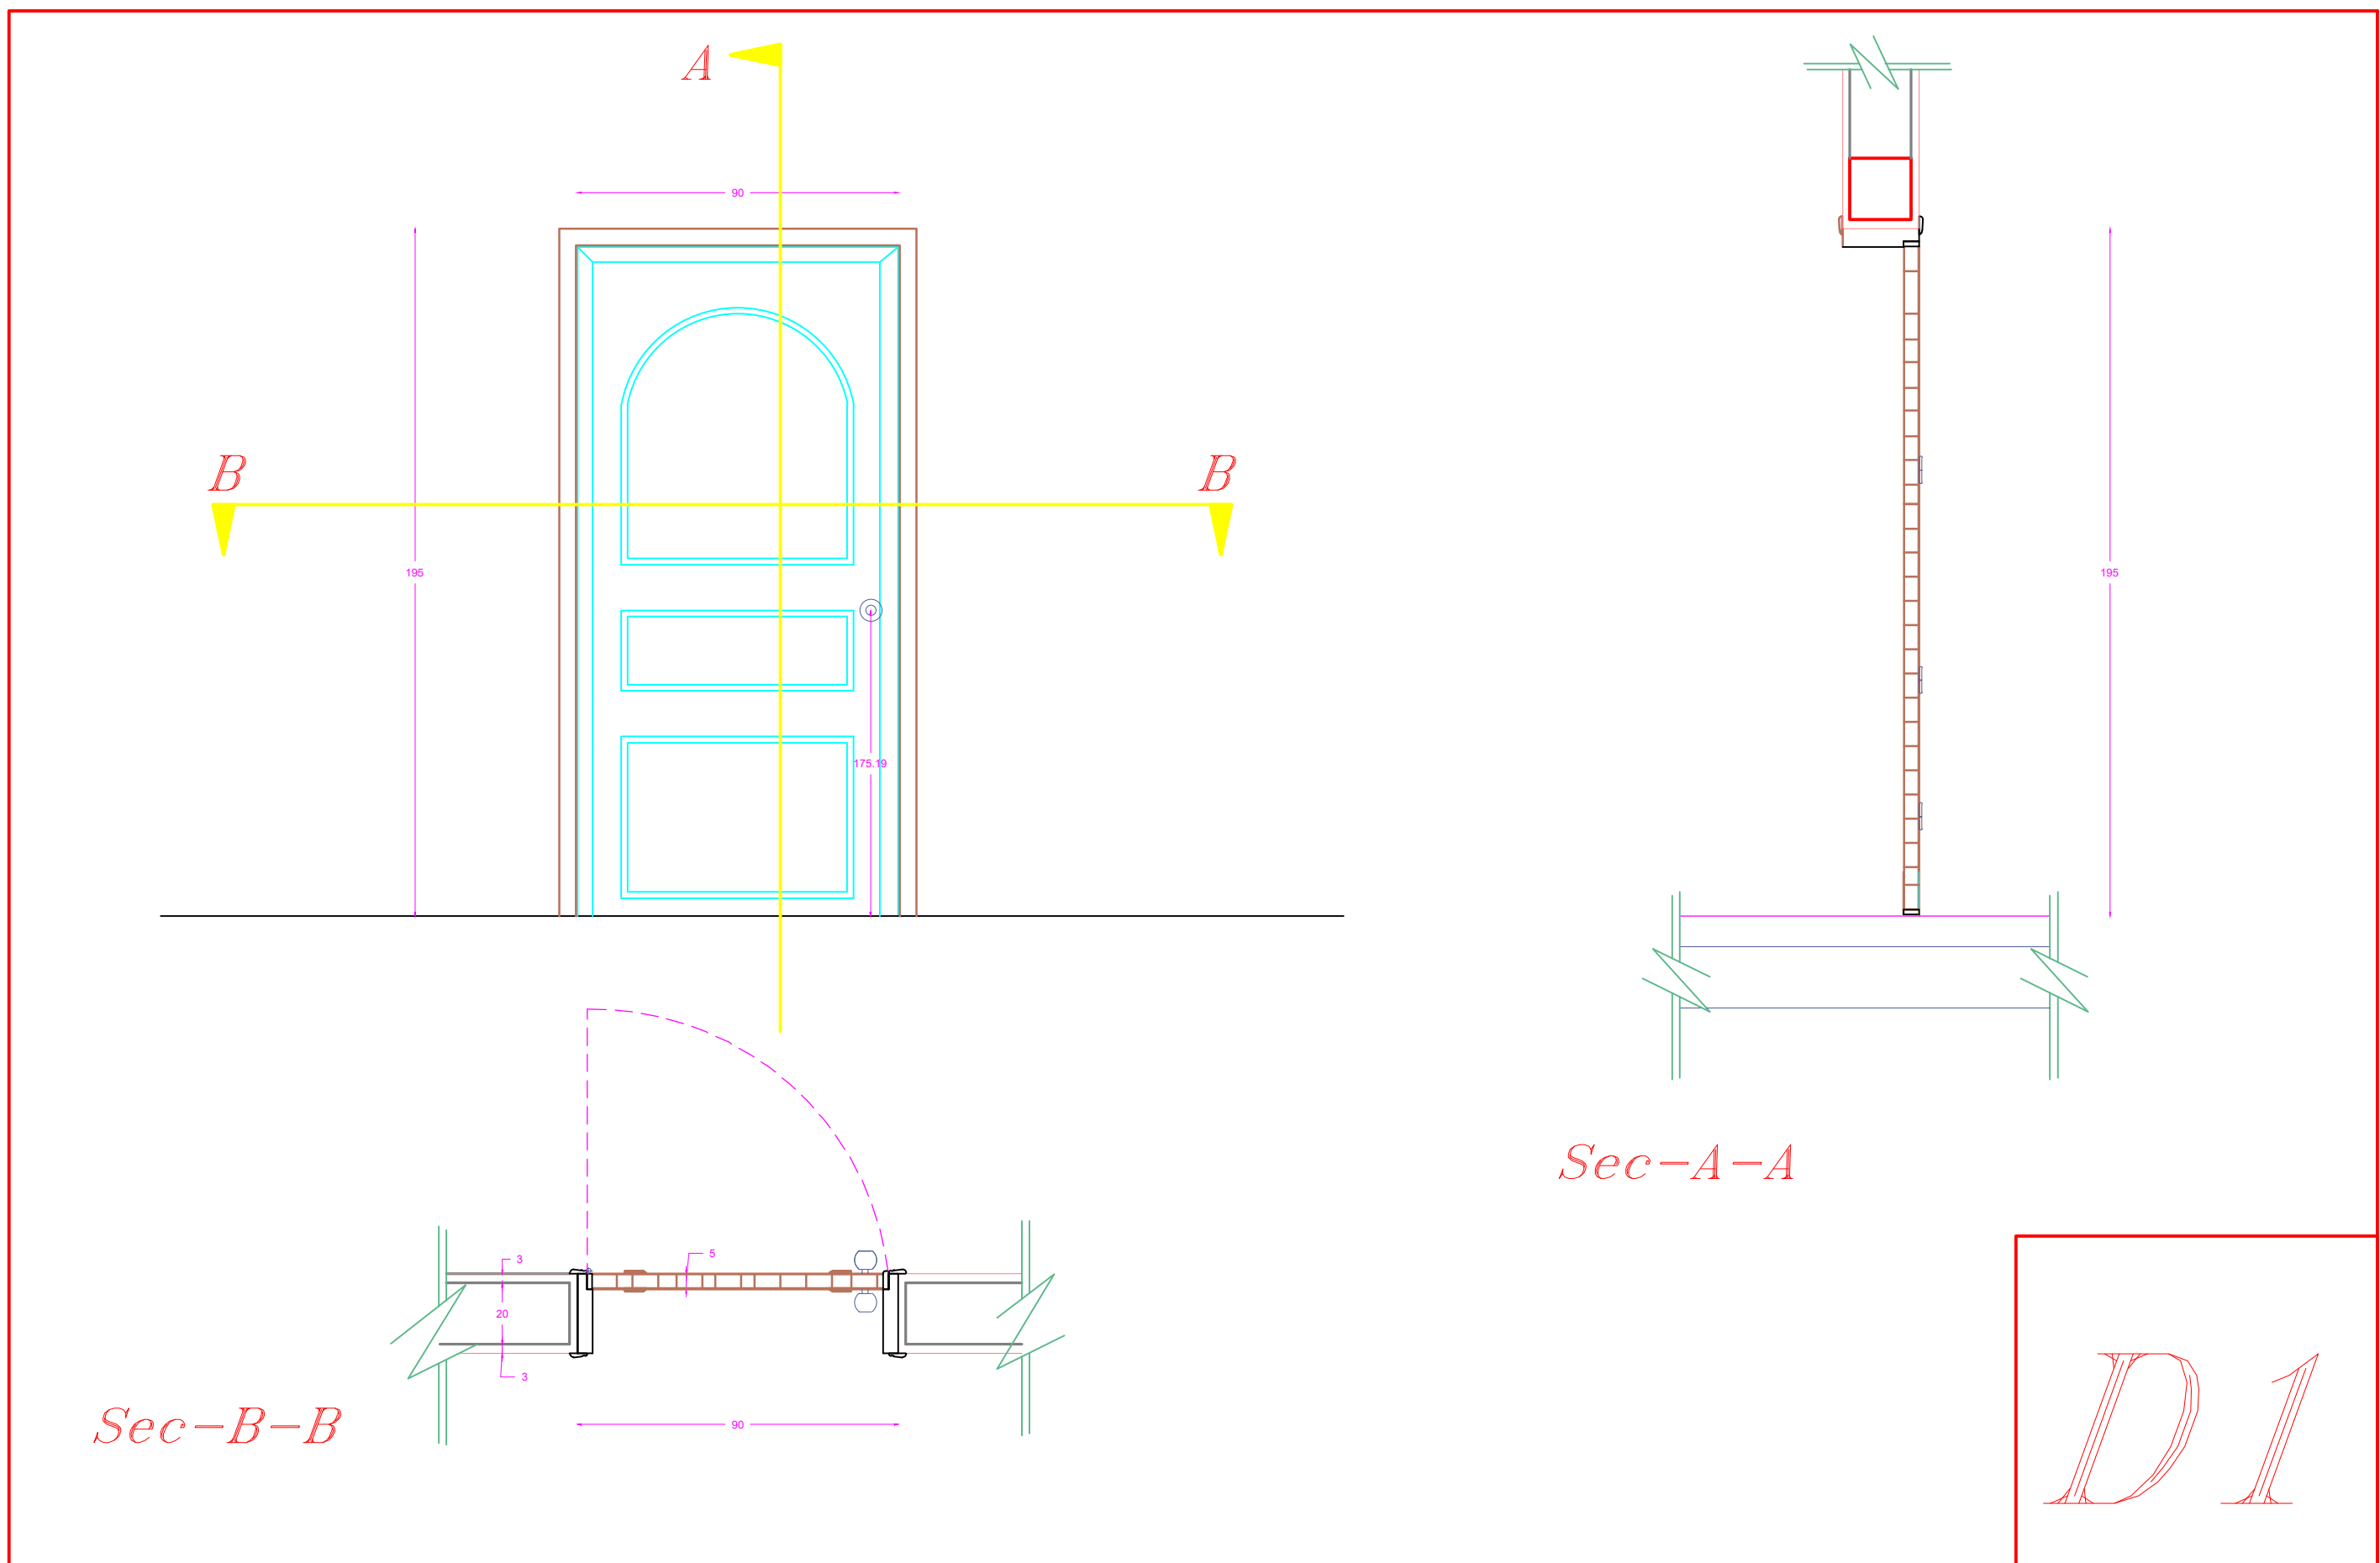

Door	Qty	W (CM)	H (CM)
D1	9	90	195
D2	2	90	195
D3	4	80	195

Doors Details - phase 2

LED down light 18 w	
LED down light 12 w	
Pole light 3m with LED light	
LED light 120cm with reflector	
LED Mirror light 12 w	
one way one gang switch	
one way two gang switch	
Two way one gang switch	
Push Button	
Single socket	
Double socket	
1 Ton A/c	
1.5 Ton A/c	
Pullet camera	
Dome camera	
Smoke detector	
Heat detector	
Sounder	
Automatic Fire extinguisher	
Fire extinguisher	
Break glass	
TV Outlet	
Telephone Outlet	
Data Outlet	

C:\Users\User\Desktop\unfpa.jpg

Eng. Khaled Al Jammal
project manager


E-mail: khjammal@hotmail.com
Damascus , Syria

Proposal : 1st floor plan
scale : to fit

Project Name
UNFPA new floor in Damascus

Sheet Size
A3

Date : 27/8/2018

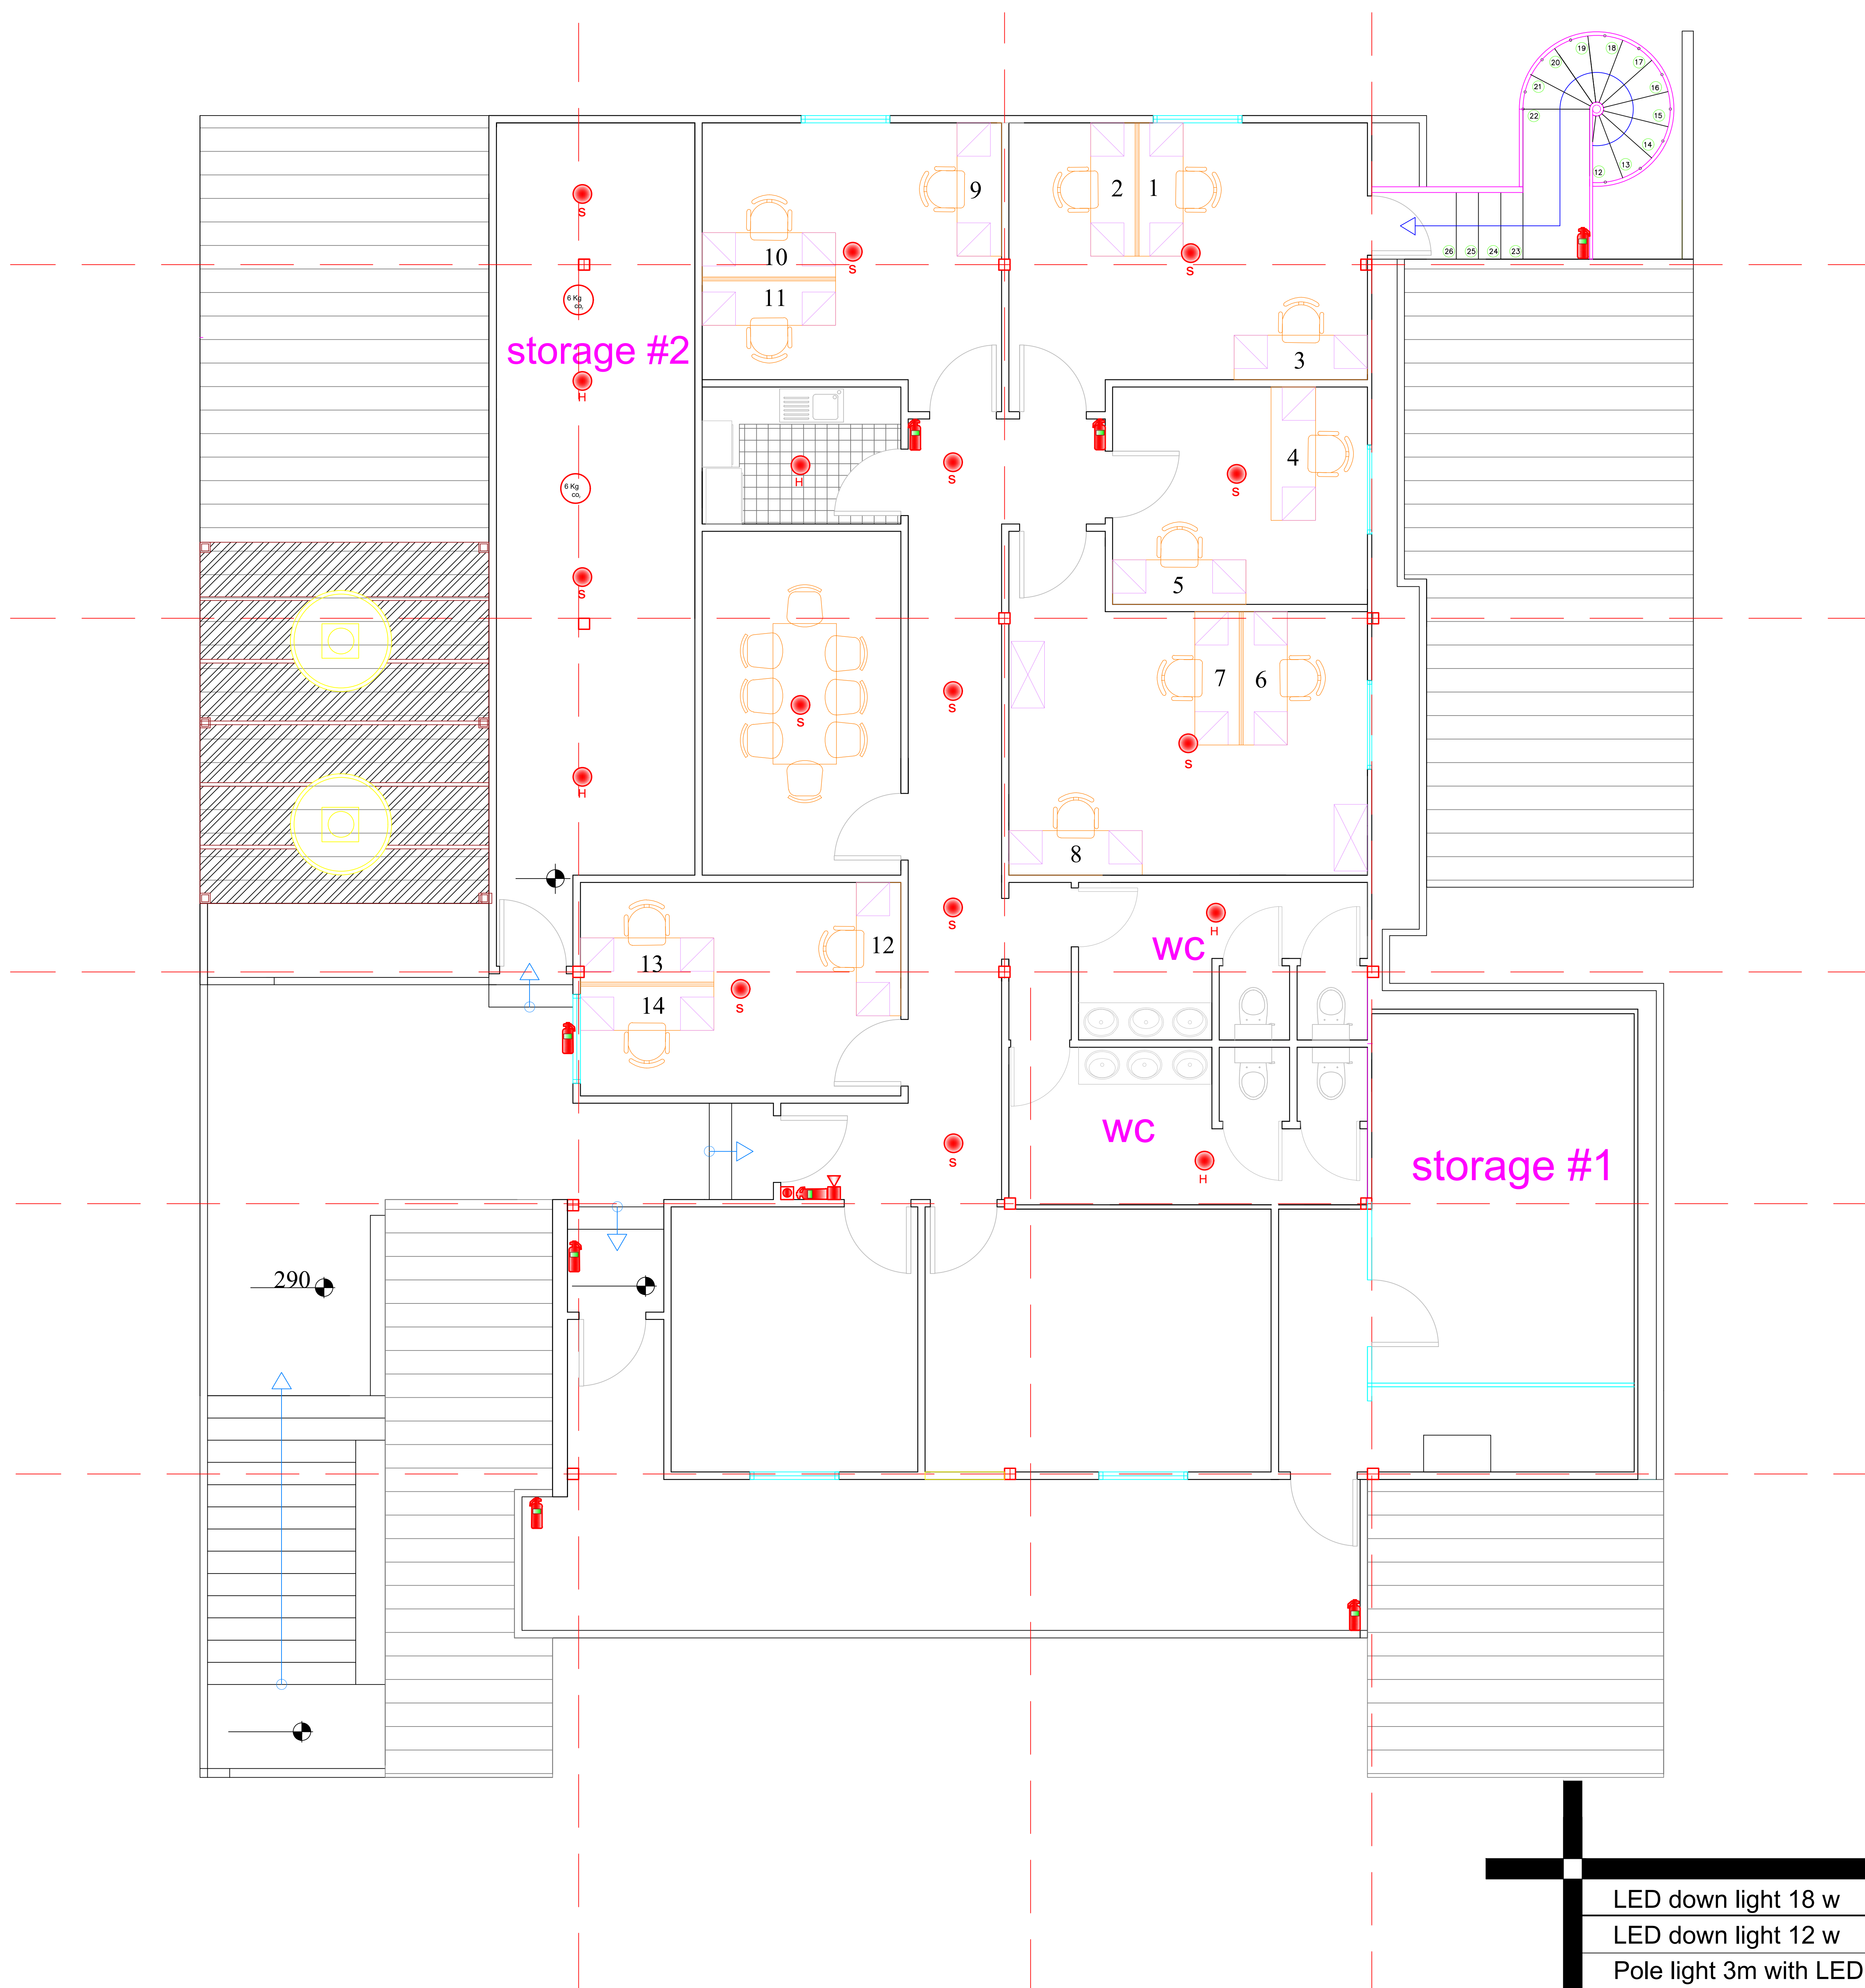

Fire extinguisher and Alarm system- phase 2

LED down light 18 w	
LED down light 12 w	
Pole light 3m with LED light	
LED light 120cm with reflector	
LED Mirror light 12 w	
one way one gang switch	
one way two gang switch	
Two way one gang switch	
Push Button	
Single socket	
Double socket	
1 Ton A/c	
1.5 Ton A/c	
Pullet camera	
Dome camera	
Smoke detector	
Heat detector	
Sounder	
Automatic Fire extinguisher	
Fire extinguisher	
Break glass	
TV Outlet	
Telephone Outlet	
Data Outlet	



Eng. Khaled Al Jammal
project manager


E-mail: khjammal@hotmail.com
Damascus , Syria

Proposal : 1st floor plan
scale : to fit

Project Name
UNFPA new floor in Damascus

Sheet Size
A3

Date : 27/8/2018

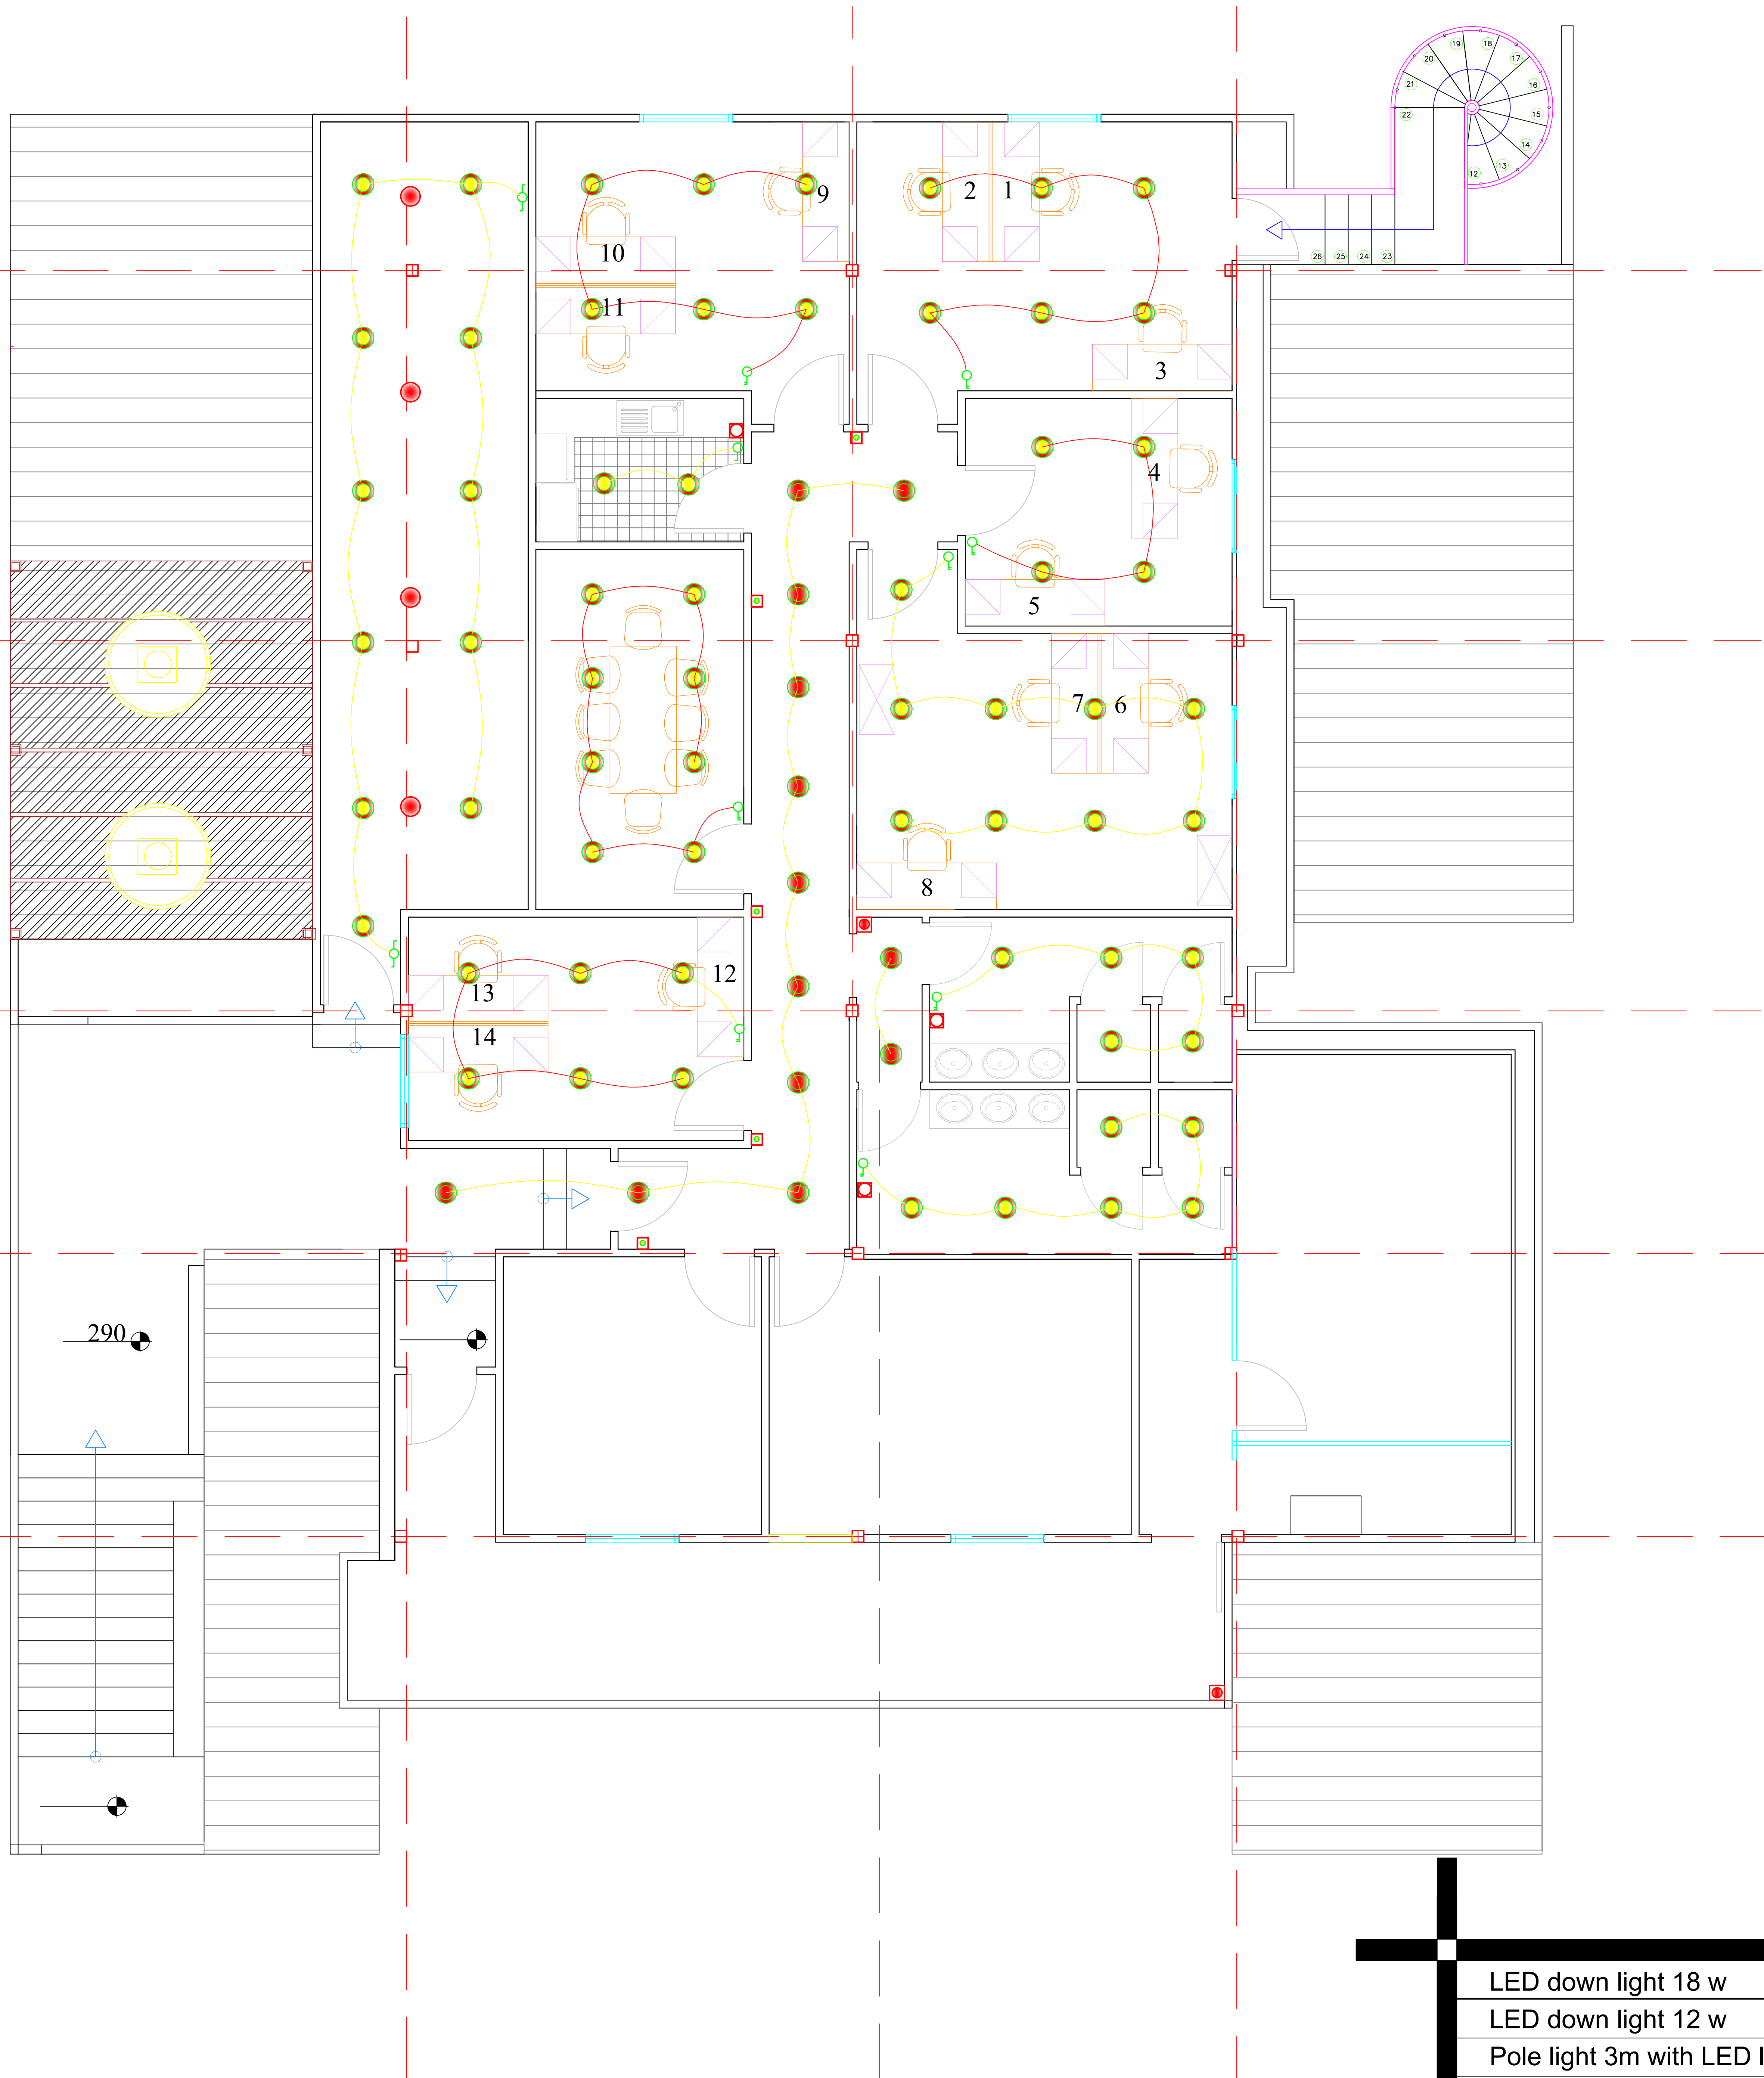

lighting plan - phase 2

LED down light 18 w	
LED down light 12 w	
Pole light 3m with LED light	
LED light 120cm with reflector	
LED Mirror light 12 w	
one way one gang switch	
one way two gang switch	
Two way one gang switch	
Push Button	
Single socket	
Double socket	
1 Ton A/c	
1.5 Ton A/c	
Pullet camera	
Dome camera	
Smoke detector	
Heat detector	
Sounder	
Automatic Fire extinguisher	
Fire extinguisher	
Break glass	
TV Outlet	
Telephone Outlet	
Data Outlet	



Eng. Khaled Al Jammal
project manager


E-mail: khjammal@hotmail.com
Damascus , Syria

Proposal : 1st floor plan
scale : to fit

Project Name
UNFPA new floor in Damascus

Sheet Size
A3

Date : 27/8/2018

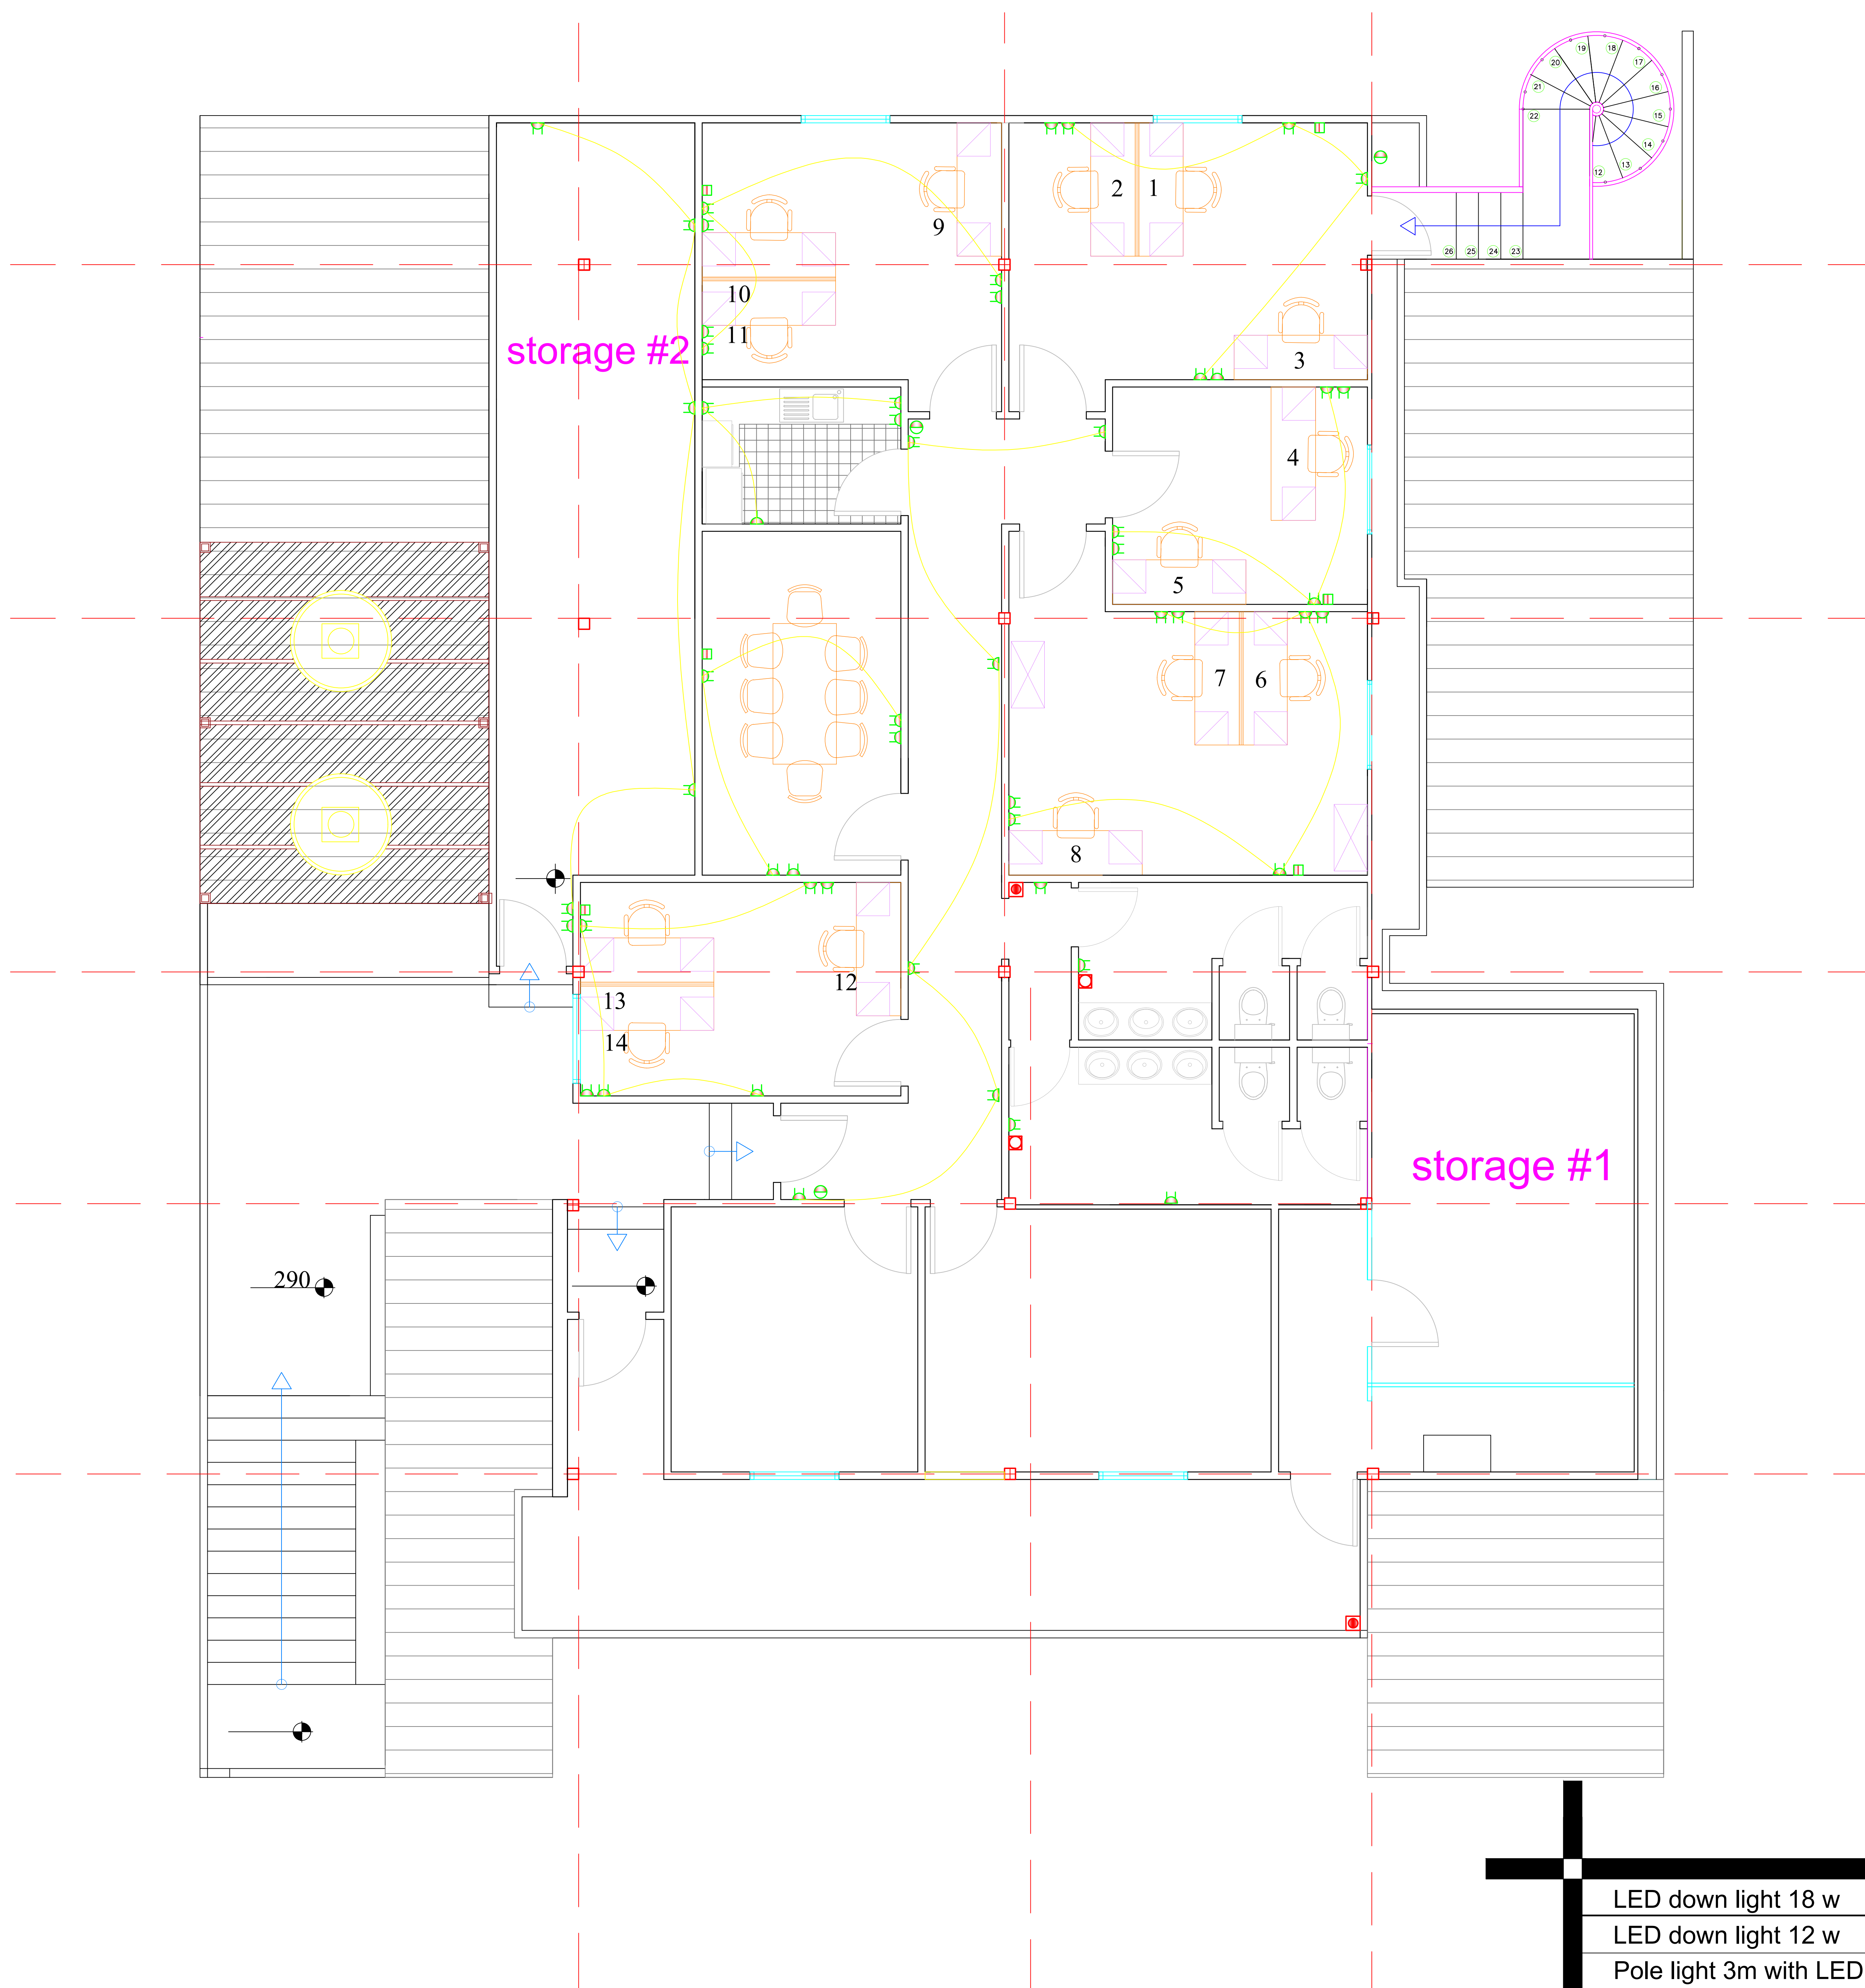

Power Plans - phase 2

LED down light 18 w	
LED down light 12 w	
Pole light 3m with LED light	
LED light 120cm with reflector	
LED Mirror light 12 w	
one way one gang switch	
one way two gang switch	
Two way one gang switch	
Push Button	
Single socket	
Double socket	
1 Ton A/c	
1.5 Ton A/c	
Pullet camera	
Dome camera	
Smoke detector	
Heat detector	
Sounder	
Automatic Fire extinguisher	
Fire extinguisher	
Break glass	
TV Outlet	
Telephone Outlet	
Data Outlet	



Eng. Khaled Al Jammal
project manager


E-mail: khjammal@hotmail.com
Damascus , Syria

Proposal : 1st floor plan
scale : to fit

Project Name
UNFPA new floor in Damascus

Sheet Size
A3

Date : 27/8/2018

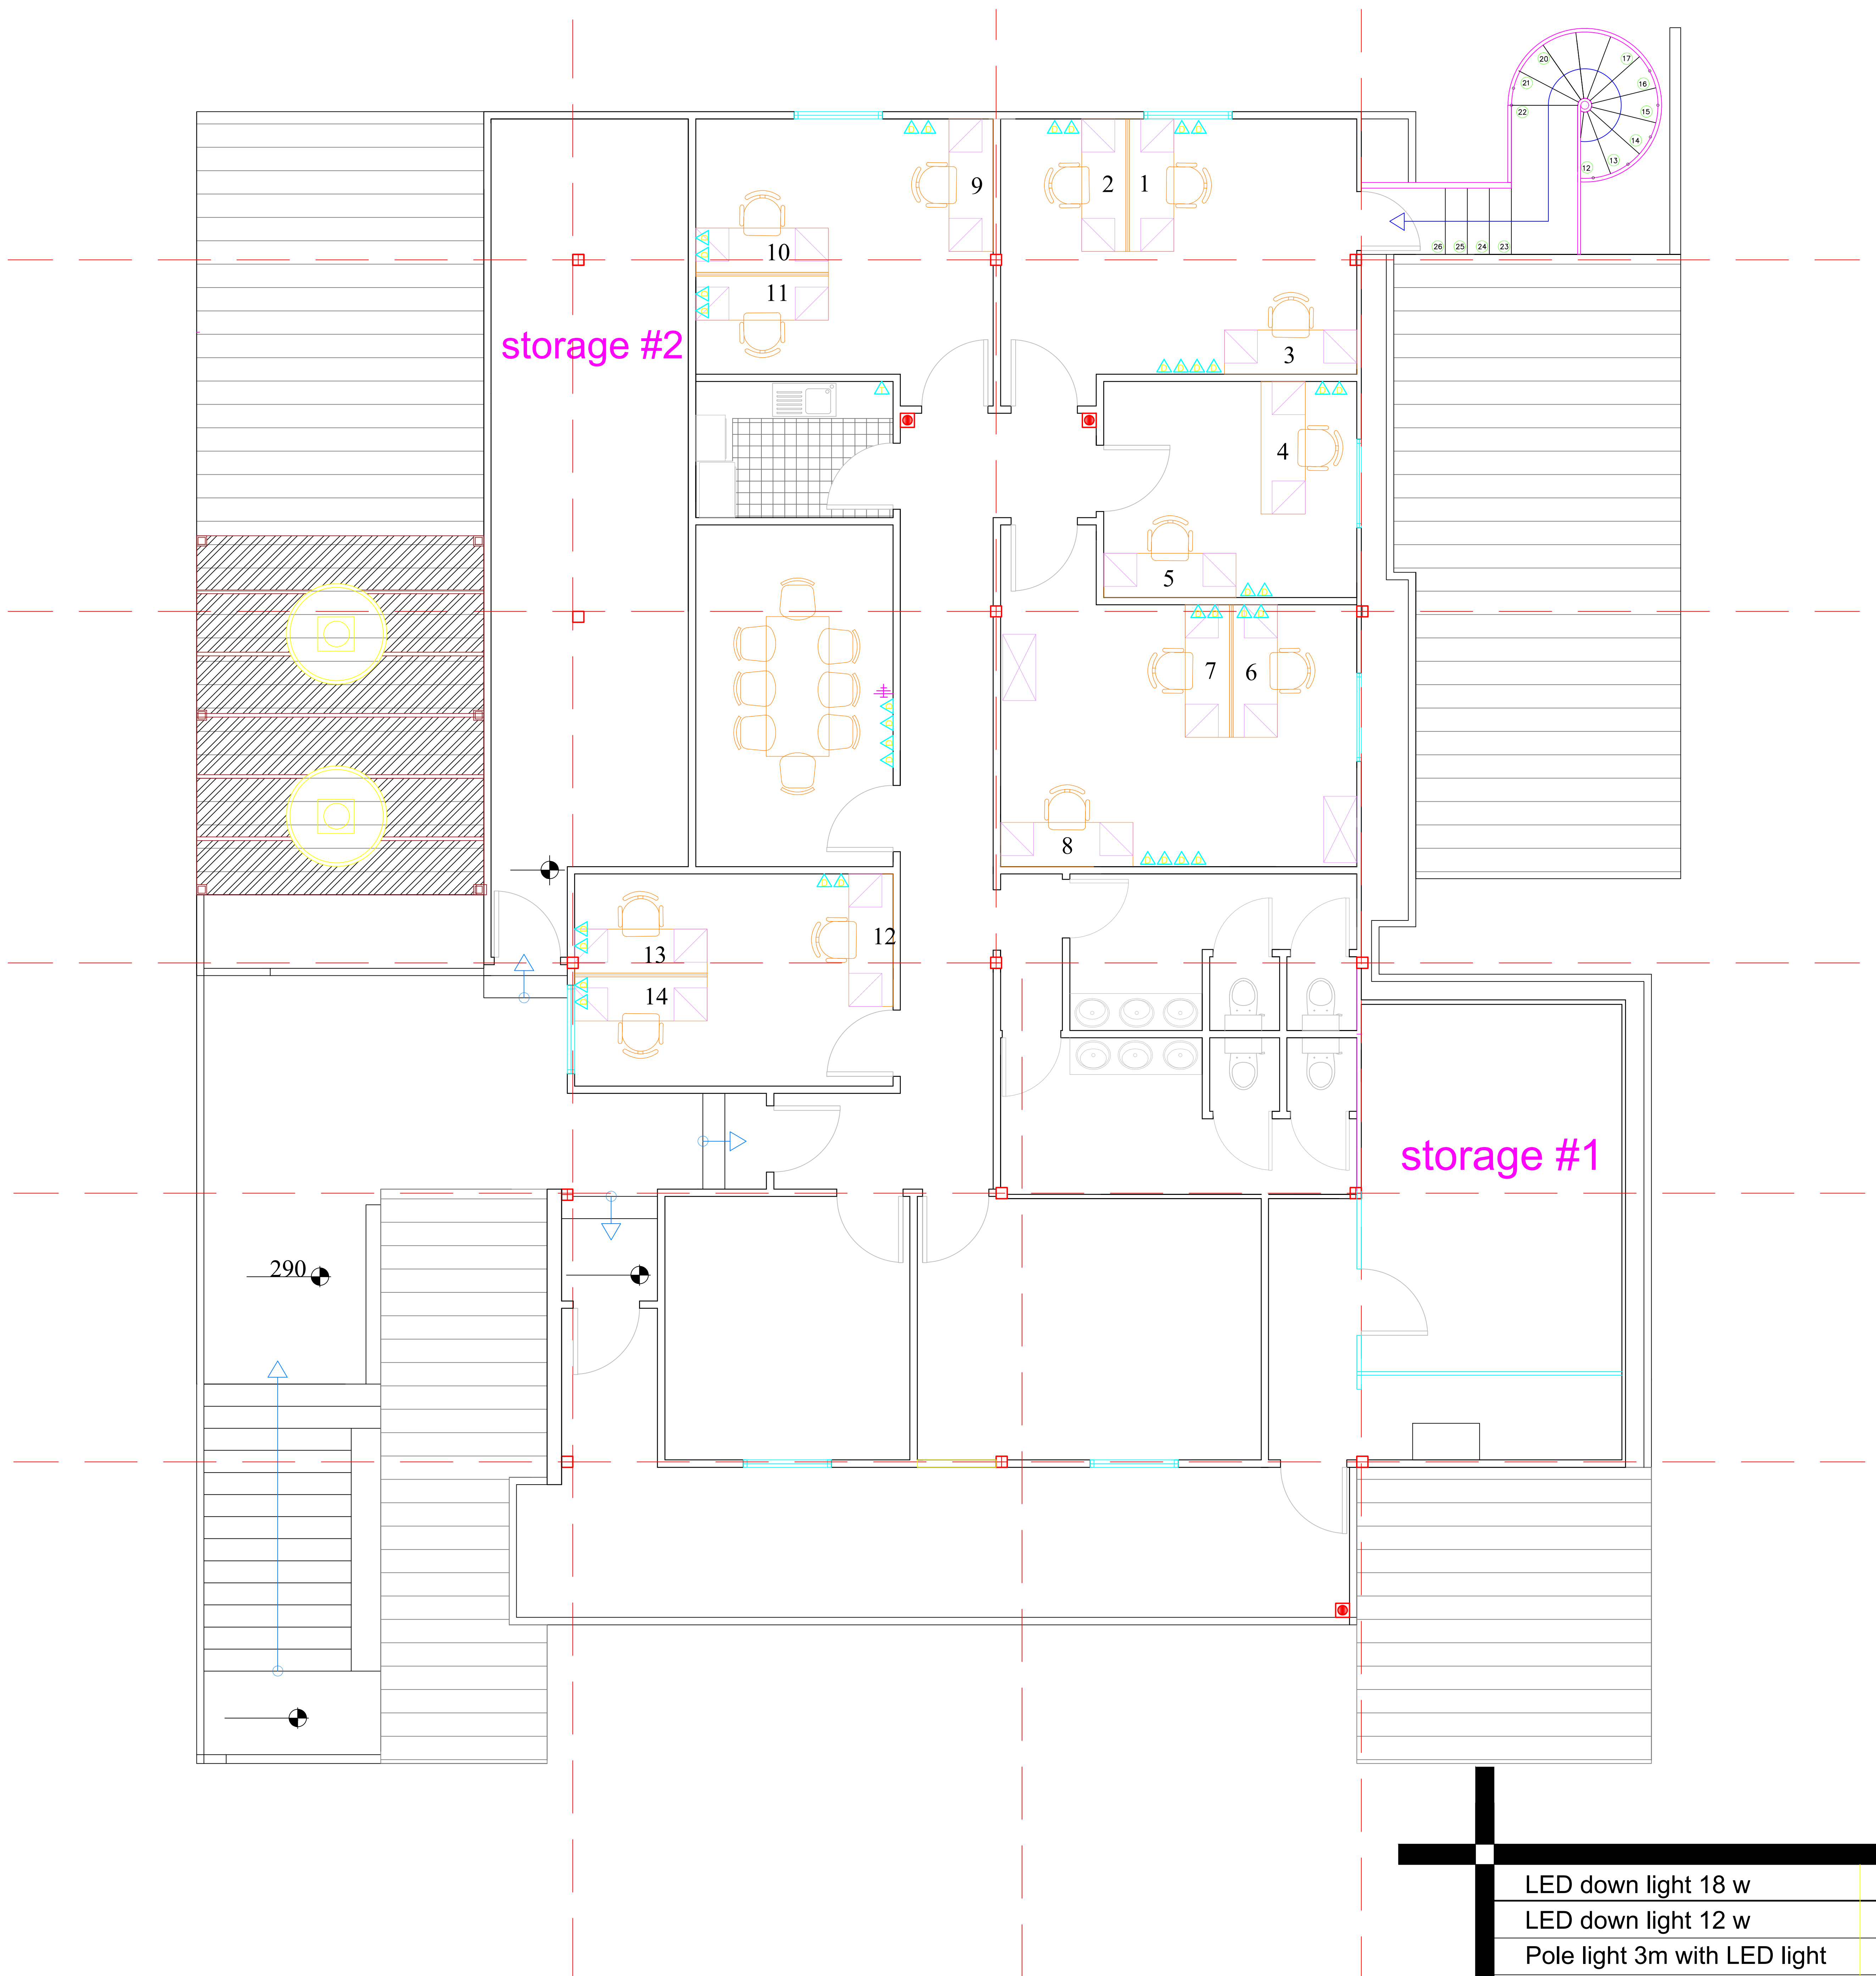

Points Location - phase 2

LED down light 18 w	
LED down light 12 w	
Pole light 3m with LED light	
LED light 120cm with reflector	
LED Mirror light 12 w	
one way one gang switch	
one way two gang switch	
Two way one gang switch	
Push Button	
Single socket	
Double socket	
1 Ton A/c	
1.5 Ton A/c	
Pullet camera	
Dome camera	
Smoke detector	
Heat detector	
Sounder	
Automatic Fire extinguisher	
Fire extinguisher	
Break glass	
TV Outlet	
Telephone Outlet	
Data Outlet	



Eng. Khaled Al Jammal
project manager

E-mail: khjammal@hotmail.com
Damascus , Syria

Proposal : 1st floor plan
scale : to fit


Project Name
UNFPA new floor in Damascus



 

 

 




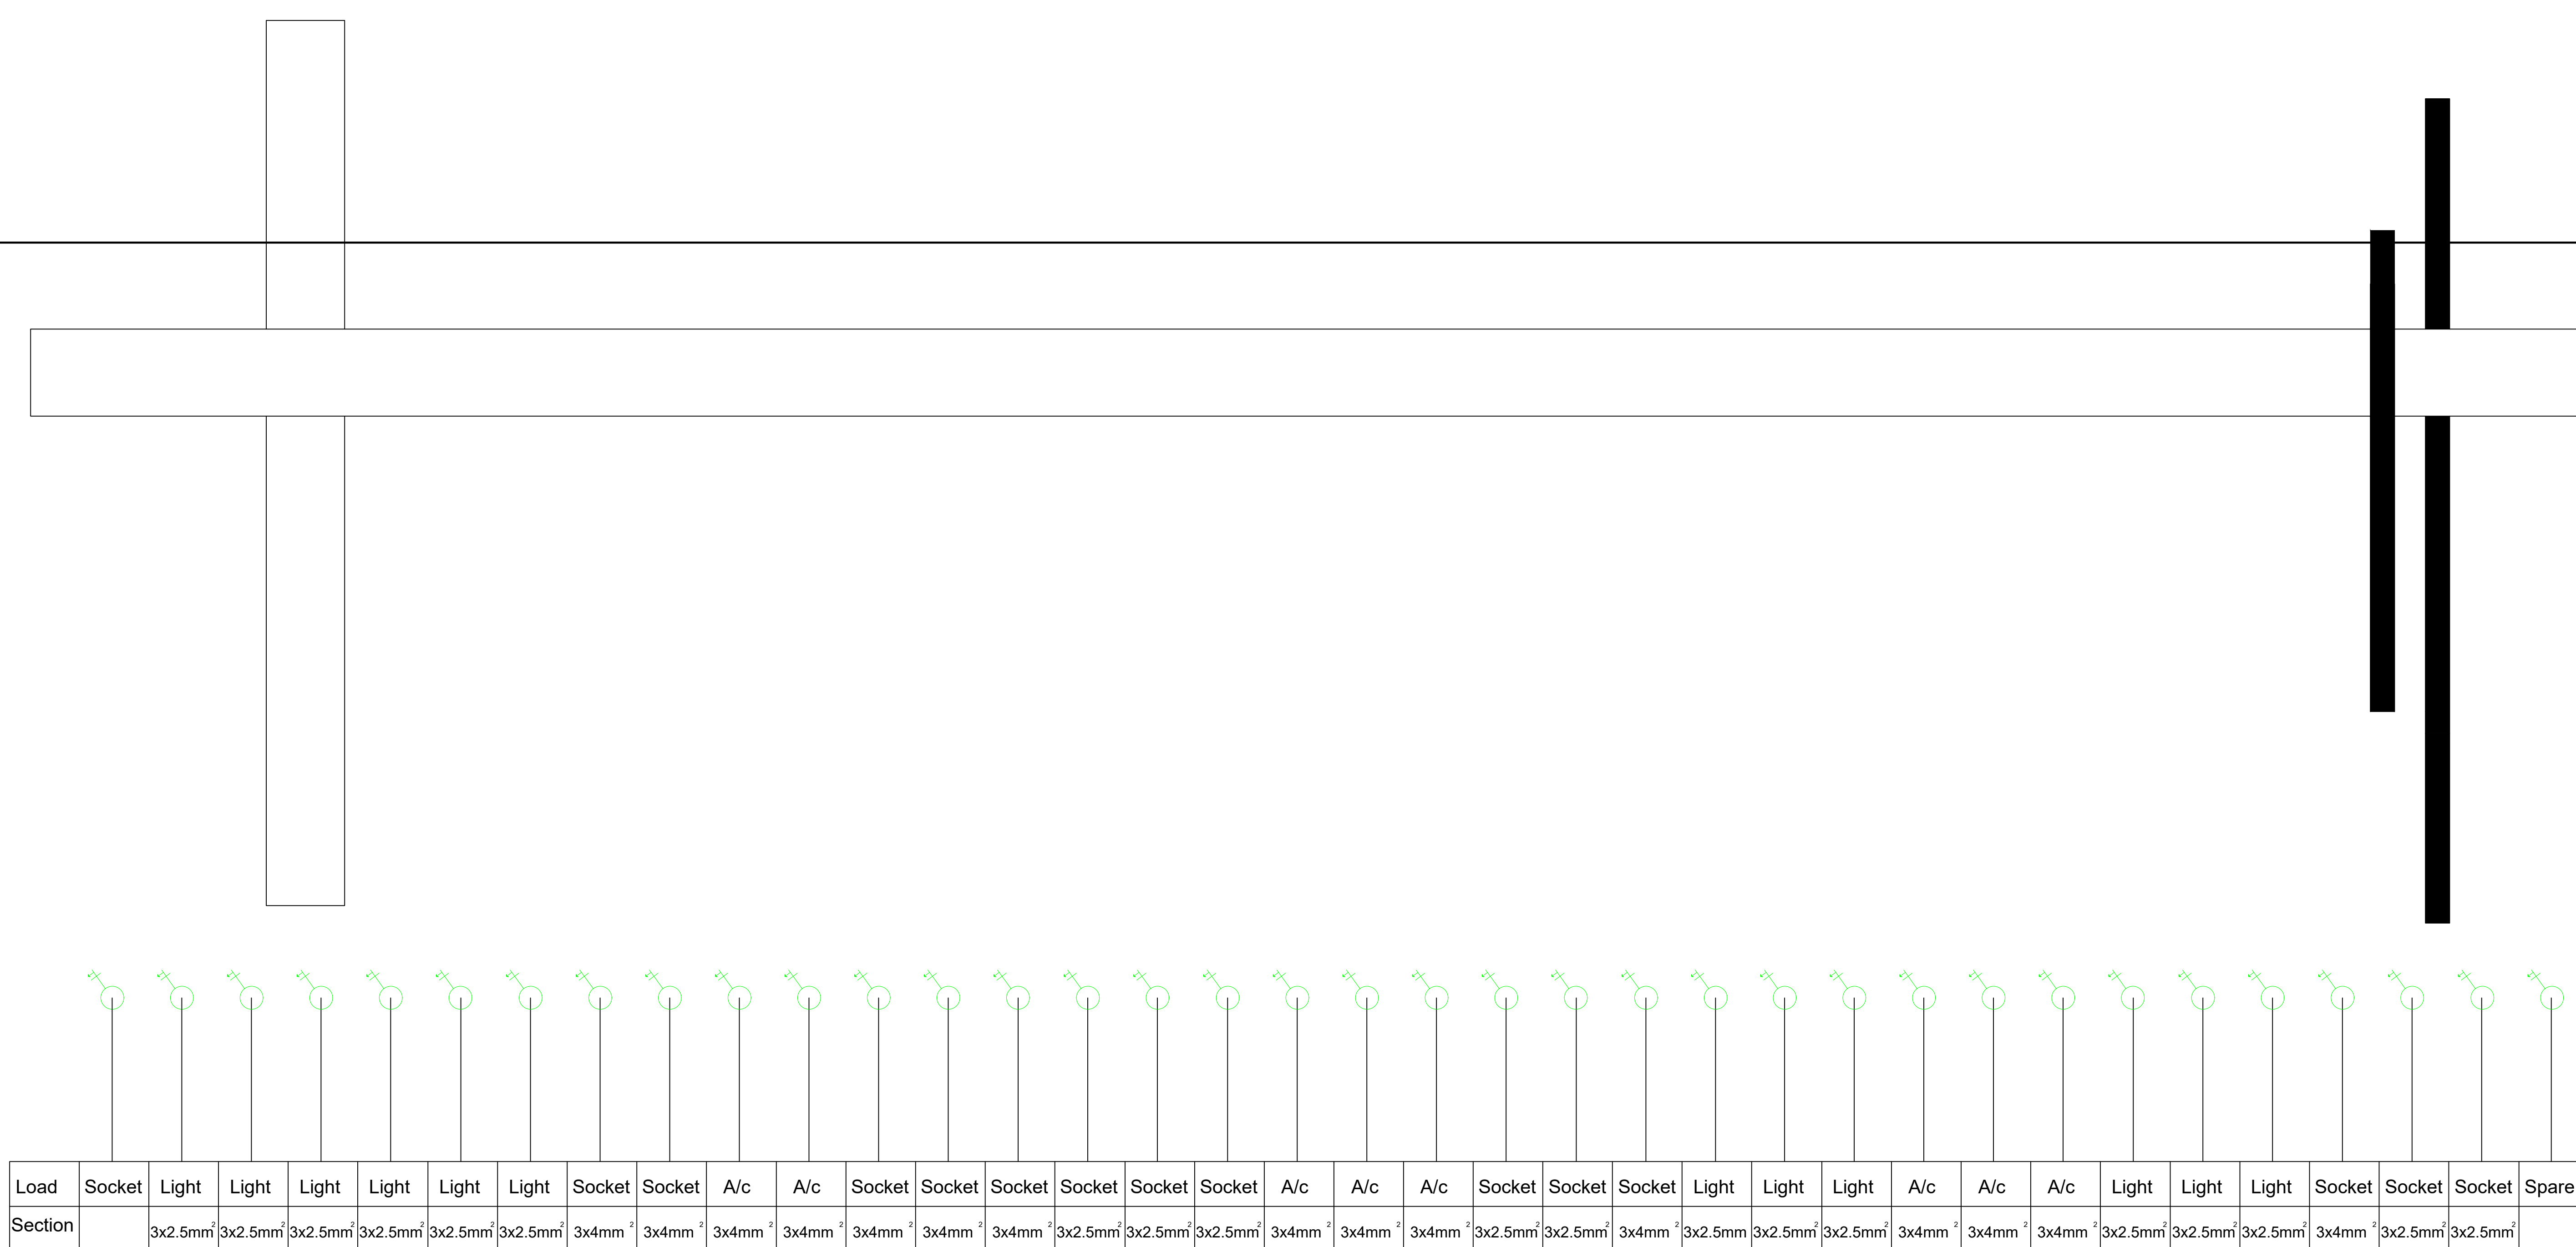


 








Sheet Size
A3

Date : 27/8/2018

Notes:

- Sockets are located at a height of 40 cm from floor level
- Horizontal distance between door opening and electrical boxes is 20 cm.
- Horizontal distance between walls corners and electrical boxes is 60 cm.
- Low current sockets (Data and telephone) must be installed together in separation from electrical boxes.



LED down light 18 w	
LED down light 12 w	
Pole light 3m with LED light	
LED light 120cm with reflector	
LED Mirror light 12 w	
one way one gang switch	
one way two gang switch	
Two way one gang switch	
Push Button	
Single socket	
Double socket	
1 Ton A/c	
1.5 Ton A/c	
Pullet camera	
Dome camera	
Smoke detector	
Heat detector	
Sounder	
Automatic Fire extinguisher	
Fire extinguisher	
Break glass	
TV Outlet	
Telephone Outlet	
Data Outlet	

Electrical Details - phase 2



Eng. Khaled Al Jammal
project manager


E-mail: khjammal@hotmail.com
Damascus , Syria

Proposal : 1st floor plan
scale : to fit

Project Name
UNFPA new floor in Damascus

Sheet Size
A3

Date : 27/8/2018

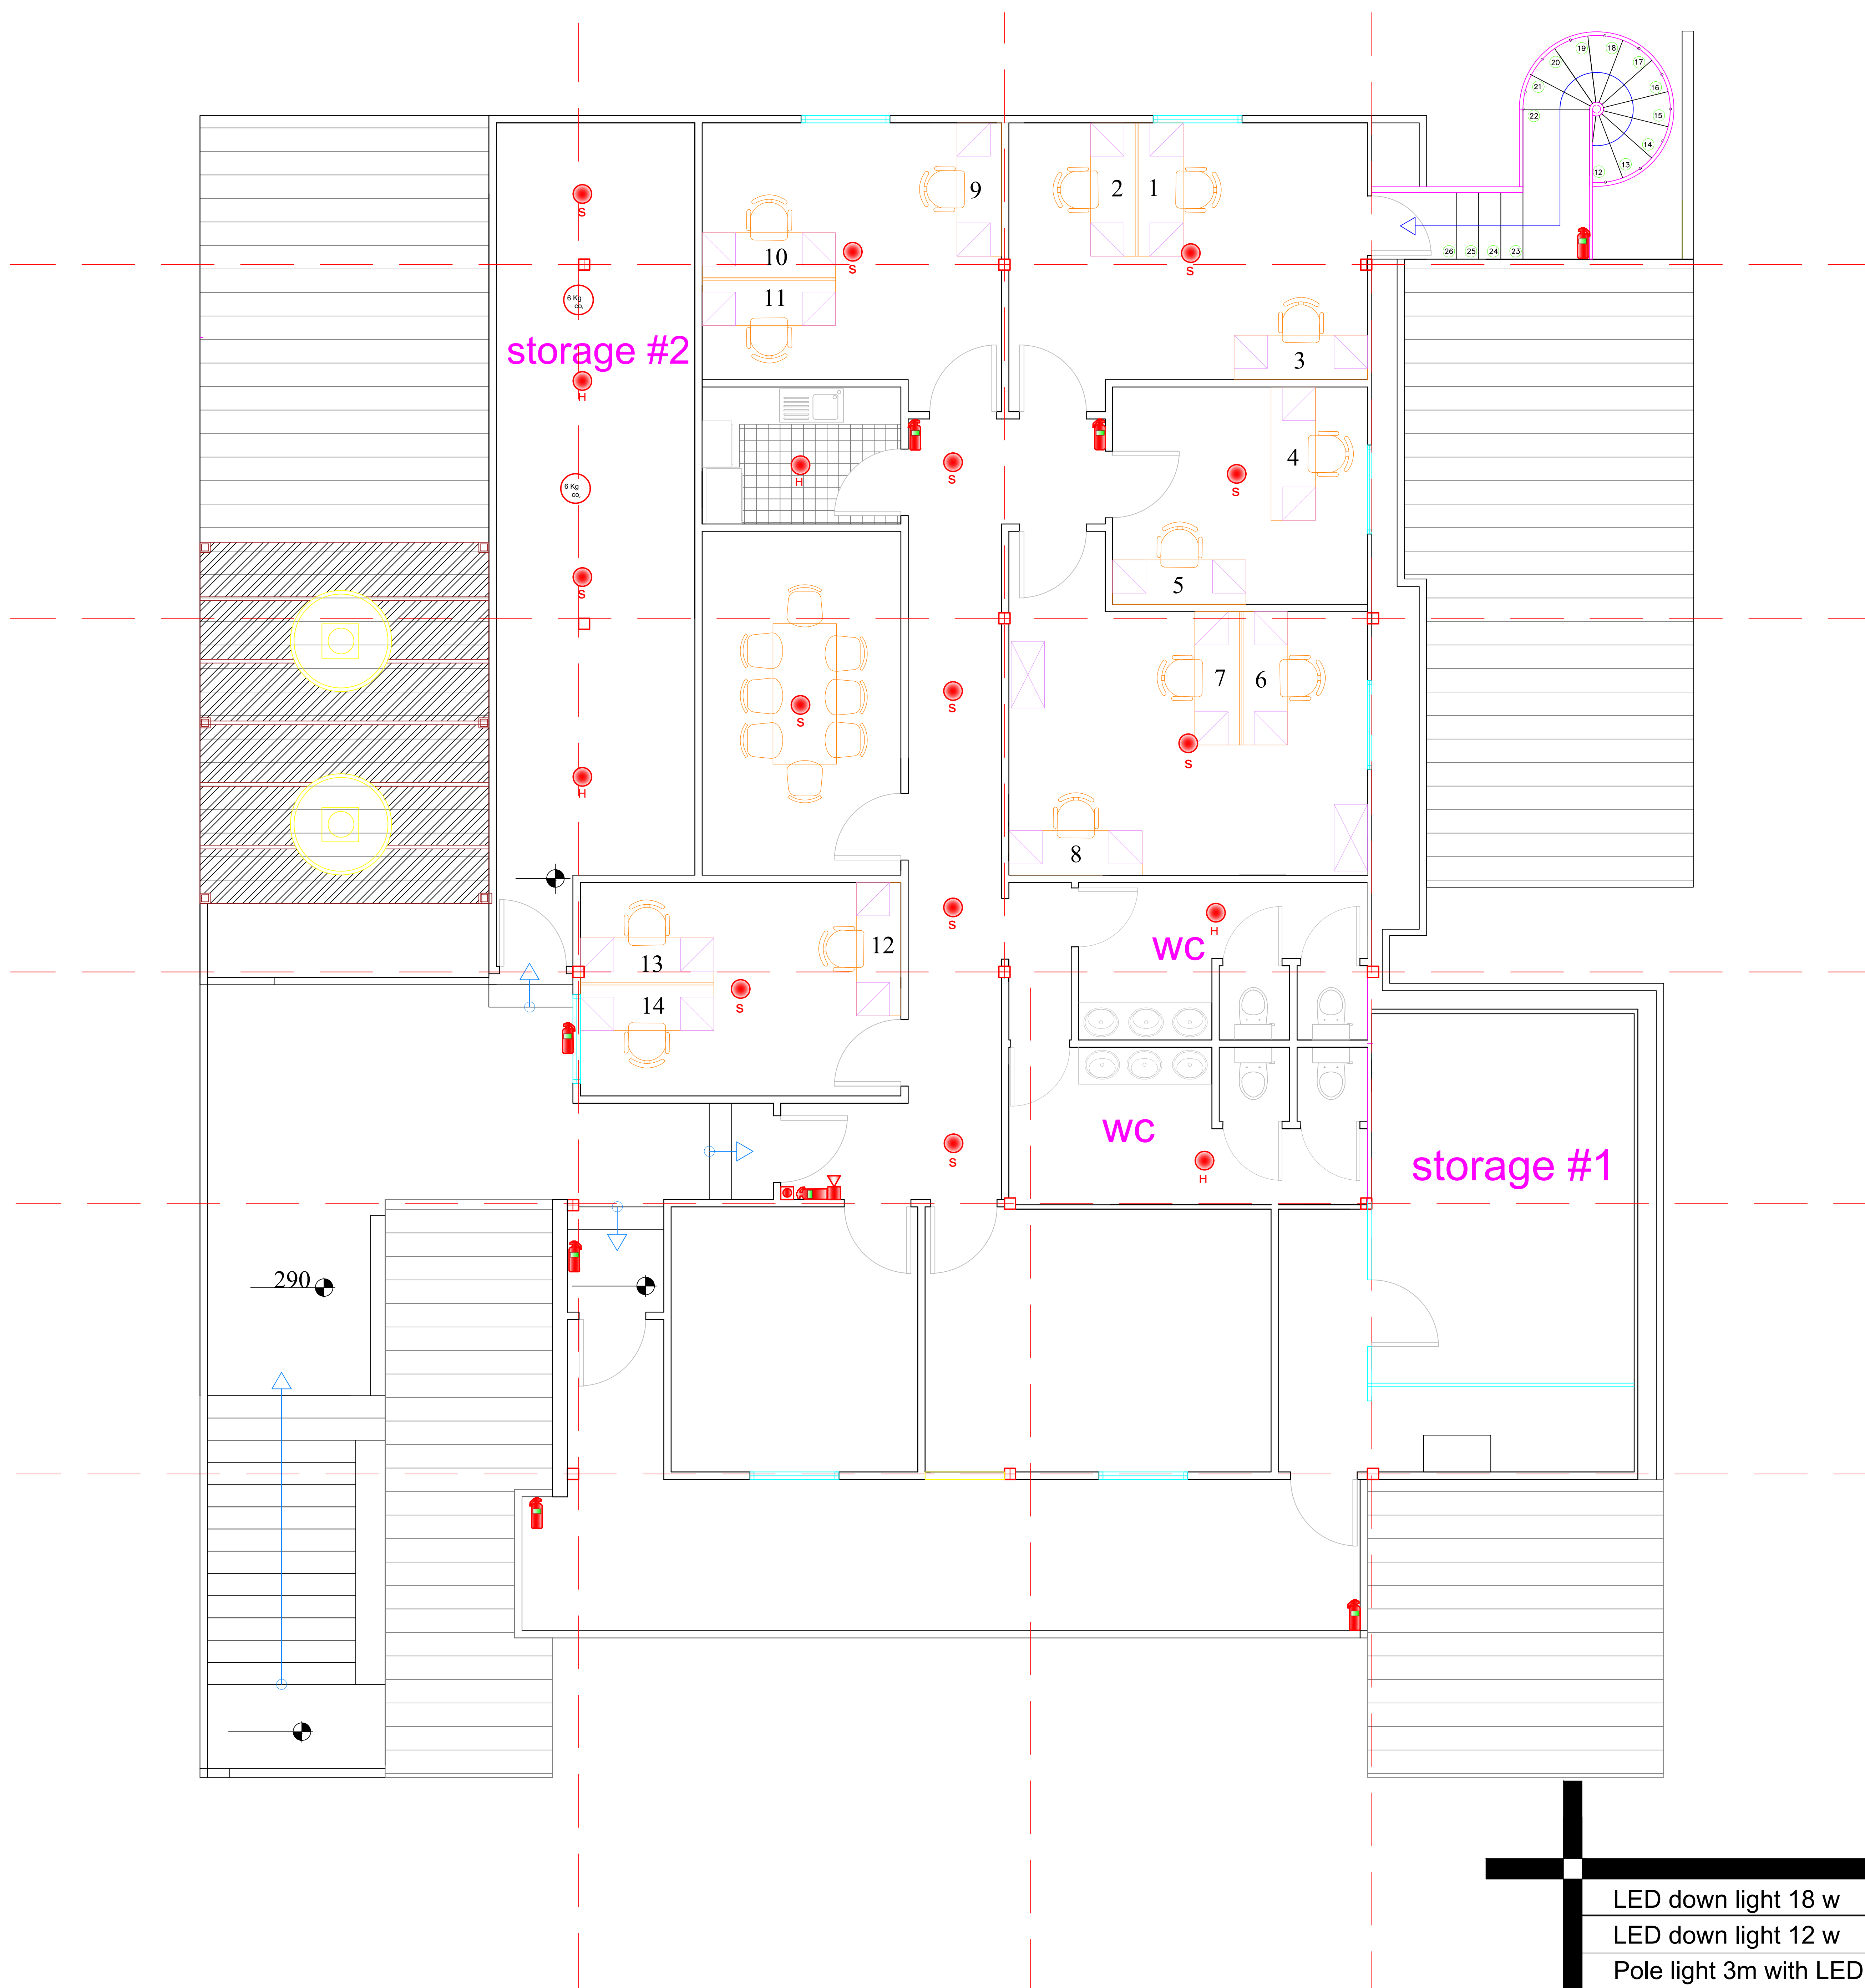

Fire extinguisher and Alarm system- phase 2

LED down light 18 w	
LED down light 12 w	
Pole light 3m with LED light	
LED light 120cm with reflector	
LED Mirror light 12 w	
one way one gang switch	
one way two gang switch	
Two way one gang switch	
Push Button	
Single socket	
Double socket	
1 Ton A/c	
1.5 Ton A/c	
Pullet camera	
Dome camera	
Smoke detector	
Heat detector	
Sounder	
Automatic Fire extinguisher	
Fire extinguisher	
Break glass	
TV Outlet	
Telephone Outlet	
Data Outlet	



Eng. Khaled Al Jammal
project manager


E-mail: khjammal@hotmail.com
Damascus , Syria

Proposal : 1st floor plan
scale : to fit

Project Name
UNFPA new floor in Damascus

Sheet Size
A3

Date : 27/8/2018

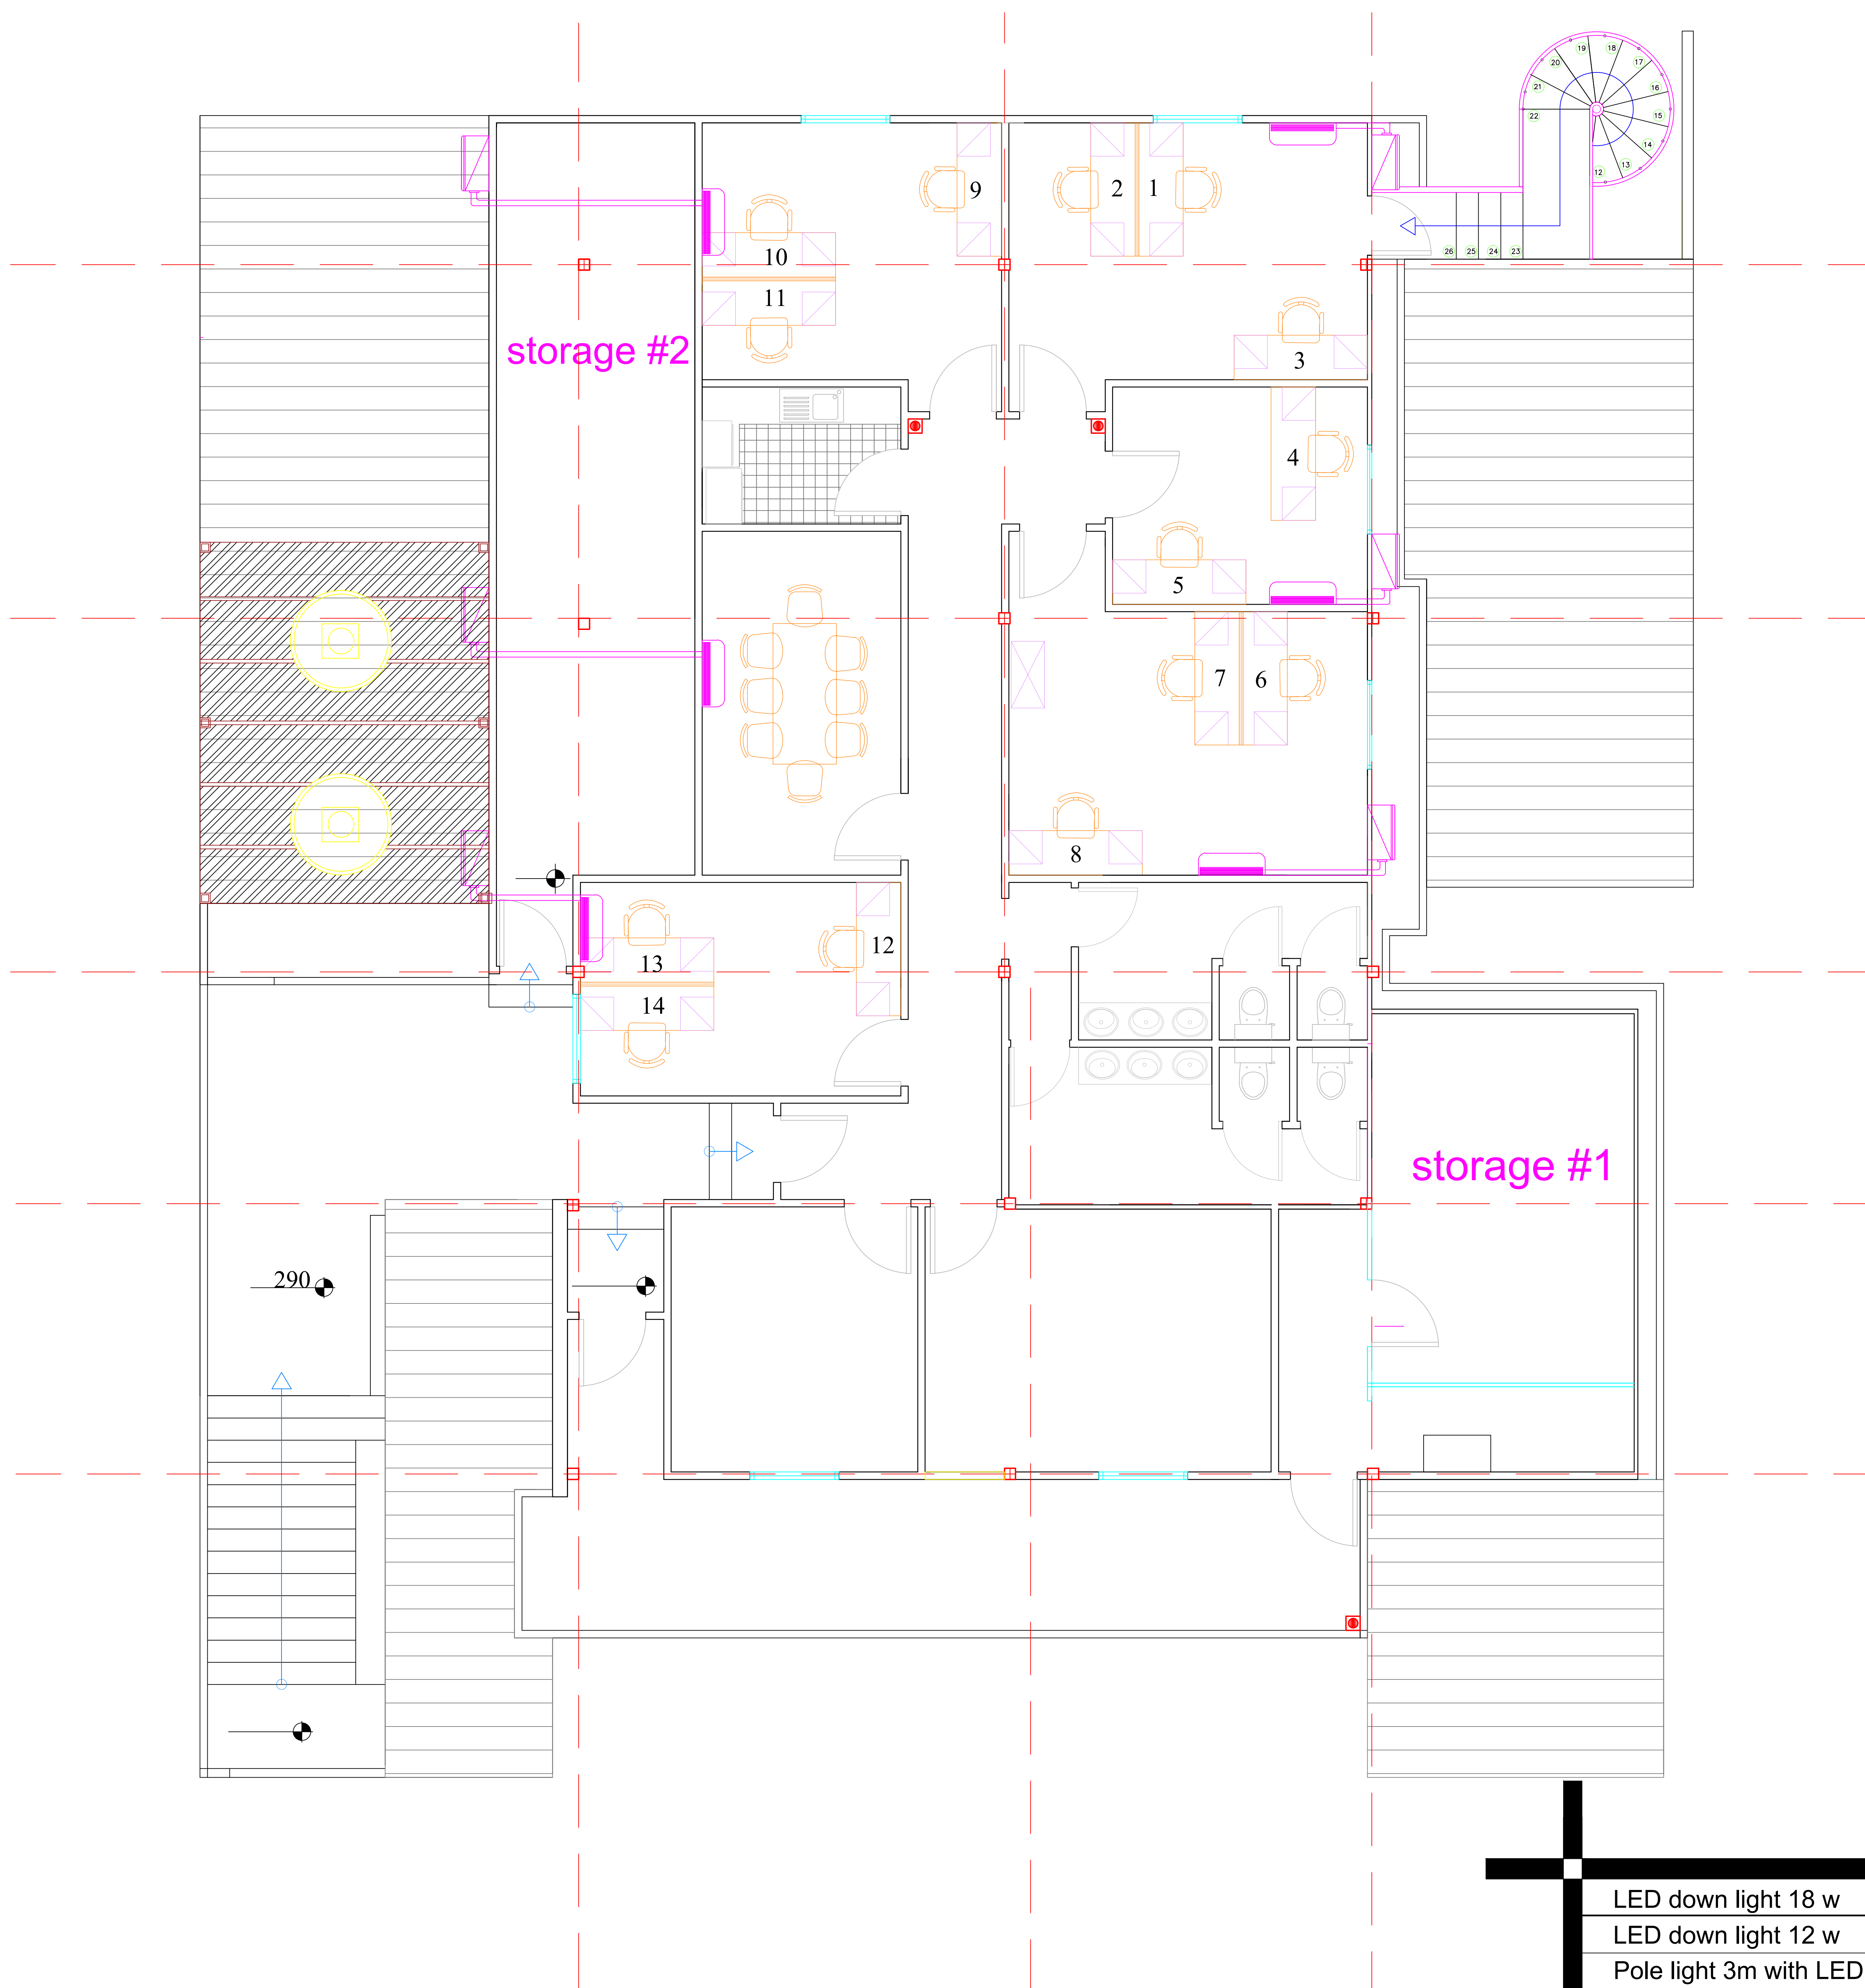

Air Conditioning plan - phase 2

LED down light 18 w	
LED down light 12 w	
Pole light 3m with LED light	
LED light 120cm with reflector	
LED Mirror light 12 w	
one way one gang switch	
one way two gang switch	
Two way one gang switch	
Push Button	
Single socket	
Double socket	
1 Ton A/c	
1.5 Ton A/c	
Pullet camera	
Dome camera	
Smoke detector	
Heat detector	
Sounder	
Automatic Fire extinguisher	
Fire extinguisher	
Break glass	
TV Outlet	
Telephone Outlet	
Data Outlet	



Eng. Khaled Al Jammal
project manager



E-mail: khjammal@hotmail.com
Damascus , Syria

Proposal : 1st floor plan
scale : to fit

Project Name
UNFPA new floor in Damascus

Sheet Size
A3

Date : 27/8/2018

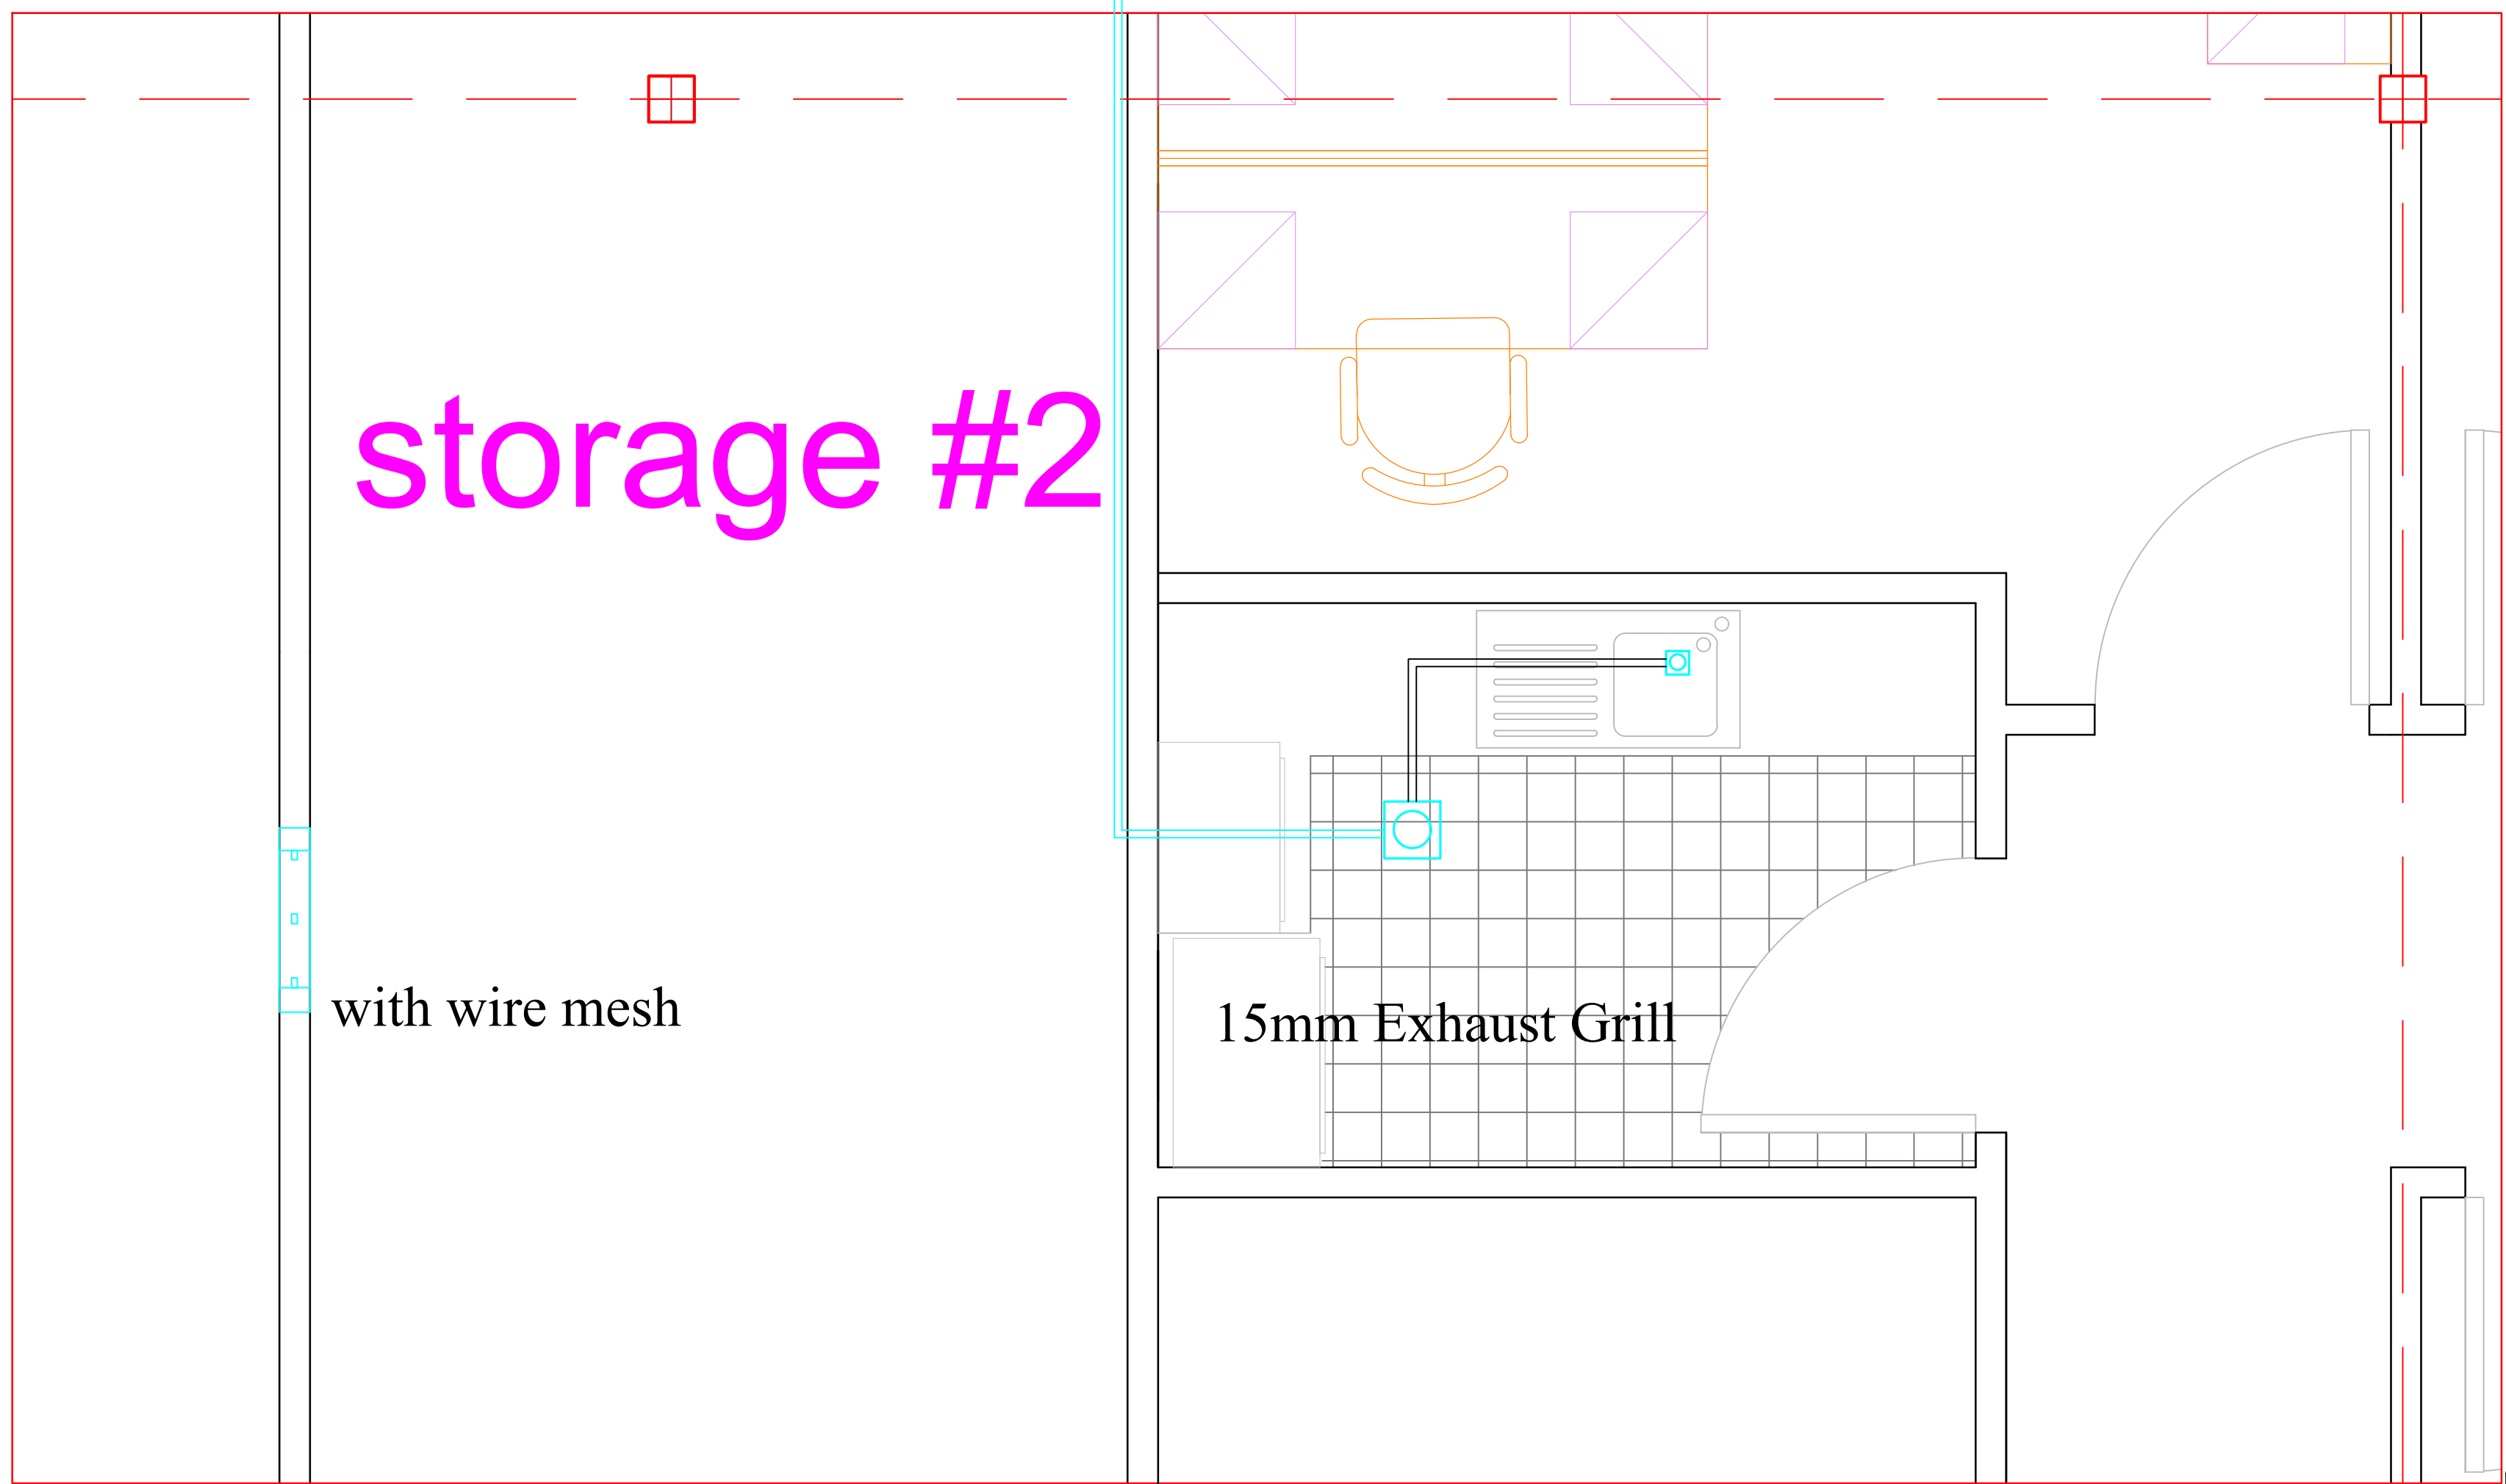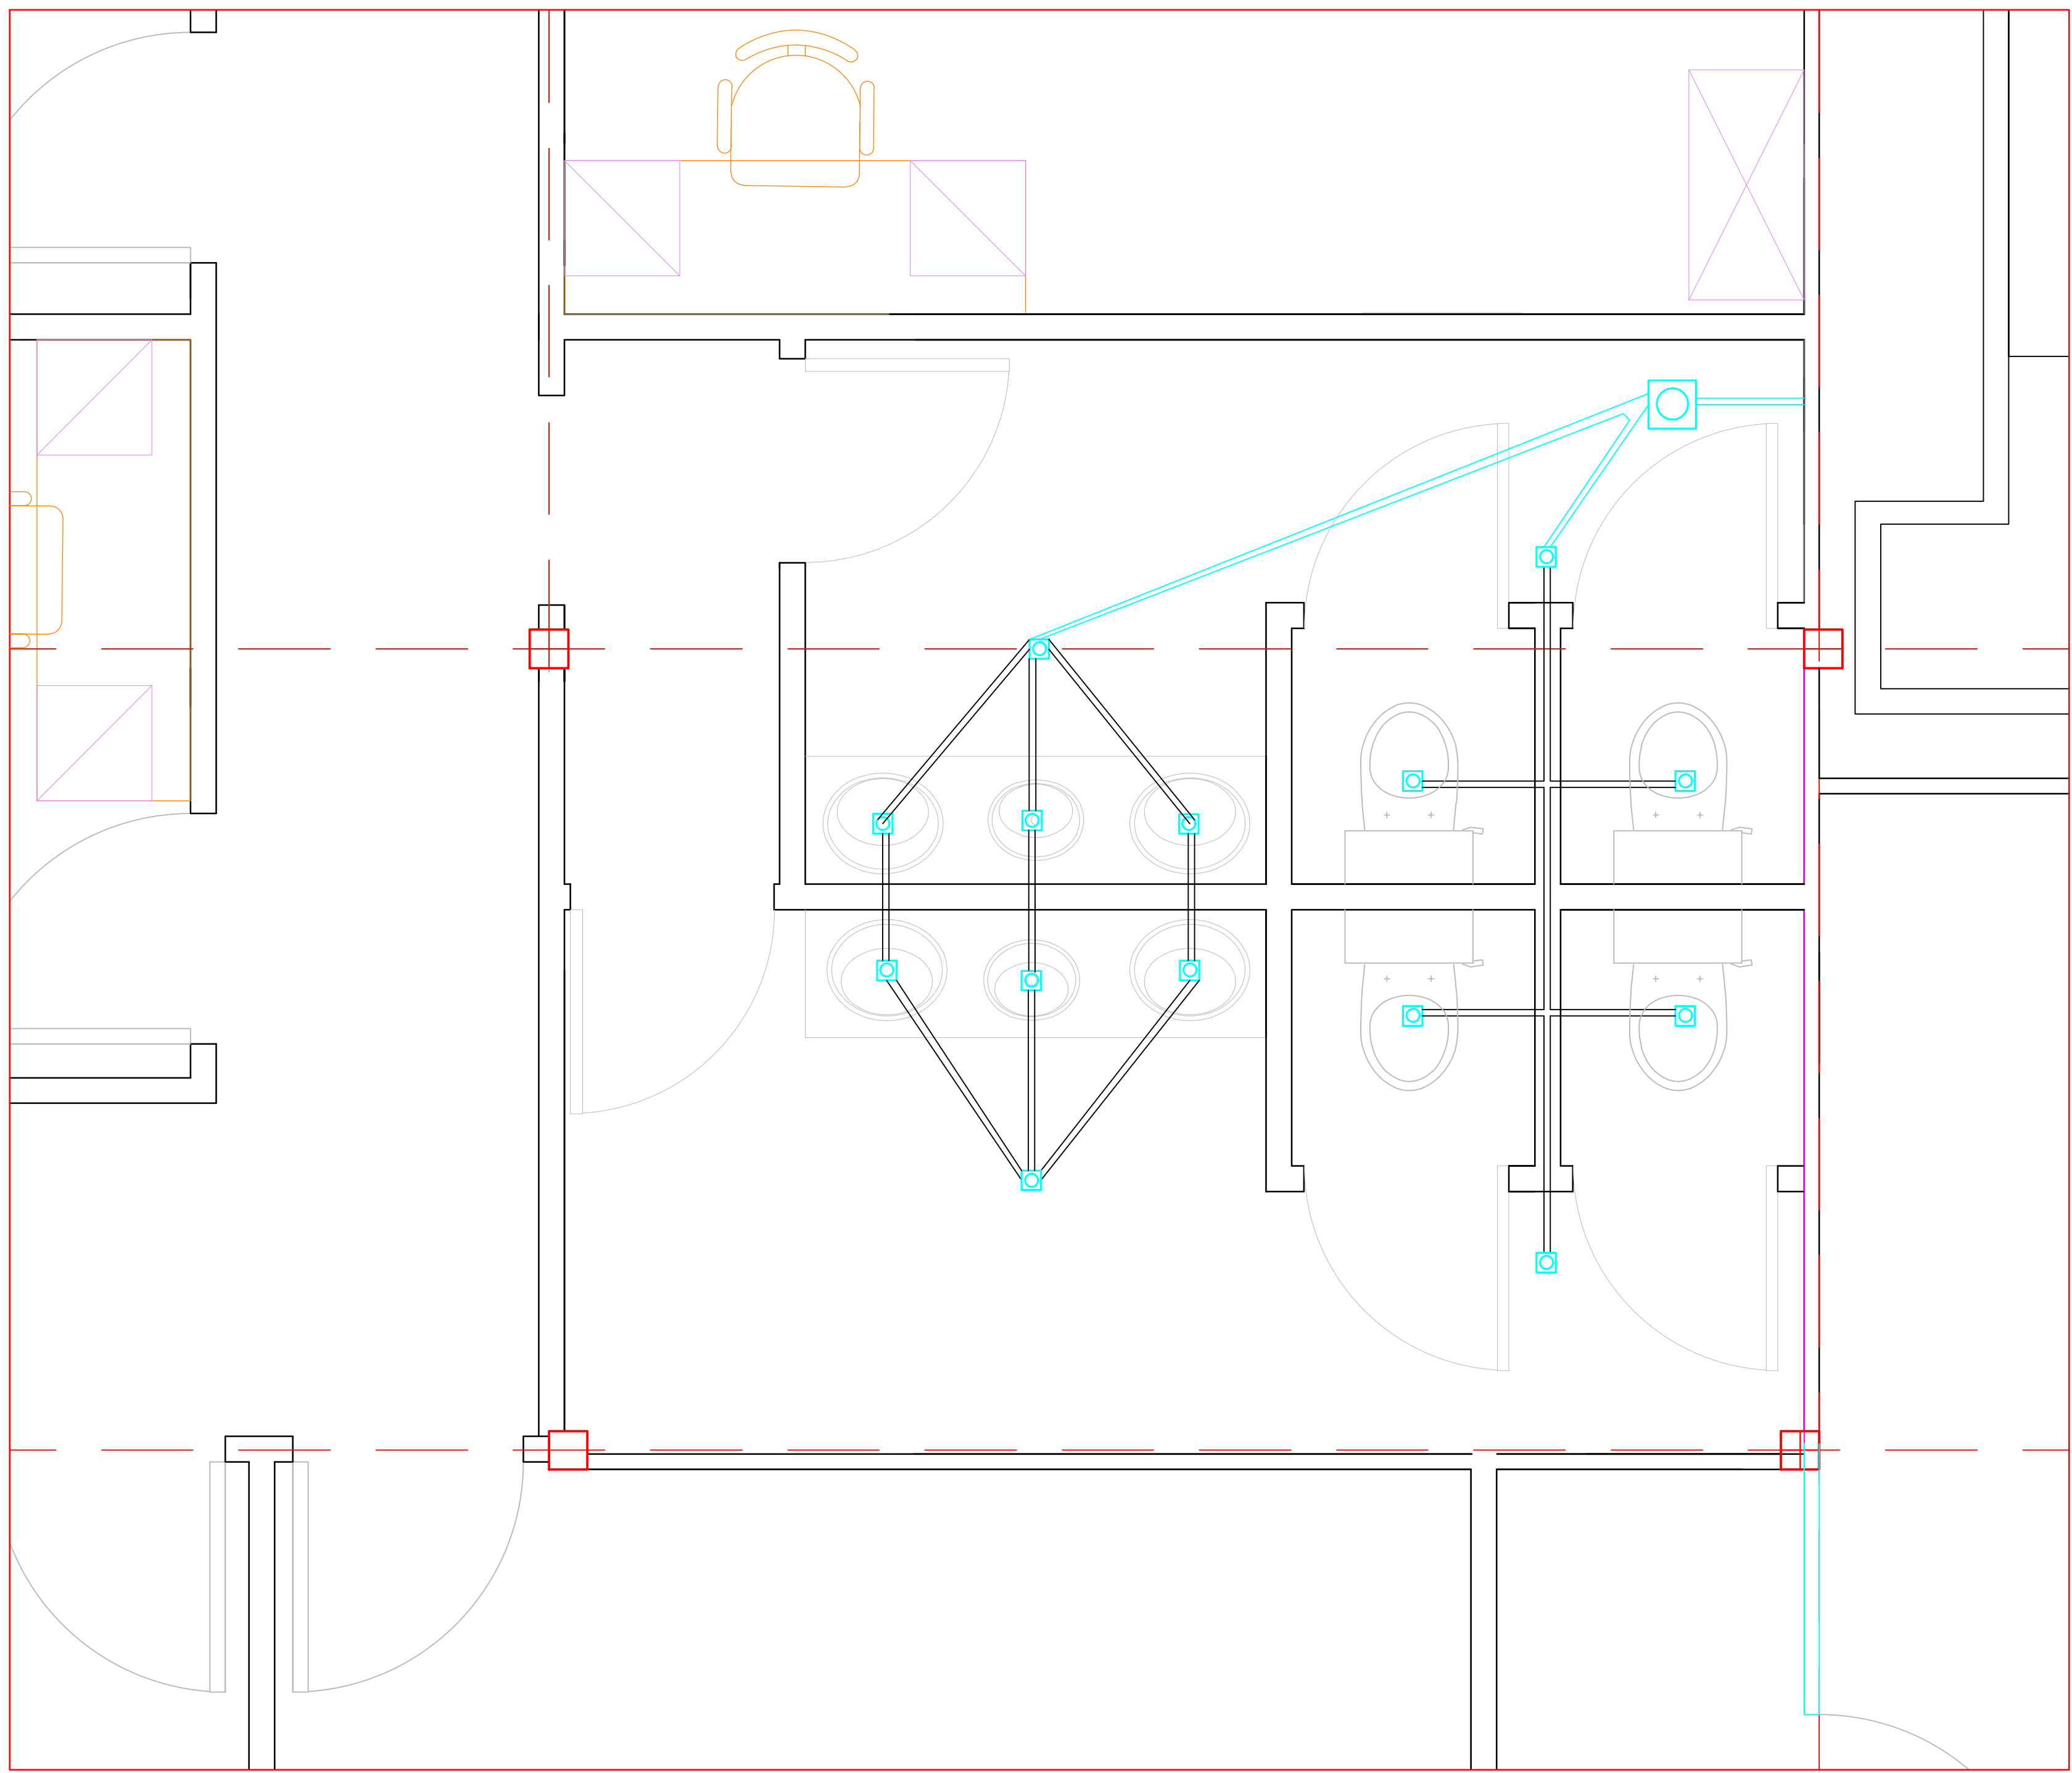

Wast Water System - phase 2

LED down light 18 w	
LED down light 12 w	
Pole light 3m with LED light	
LED light 120cm with reflector	
LED Mirror light 12 w	
one way one gang switch	
one way two gang switch	
Two way one gang switch	
Push Button	
Single socket	
Double socket	
1 Ton A/c	
1.5 Ton A/c	
Pullet camera	
Dome camera	
Smoke detector	
Heat detector	
Sounder	
Automatic Fire extinguisher	
Fire extinguisher	
Break glass	
TV Outlet	
Telephone Outlet	
Data Outlet	



Eng. Khaled Al Jammal
project manager


E-mail: khjammal@hotmail.com
Damascus , Syria

Proposal : 1st floor plan
scale : to fit

Project Name
UNFPA new floor in Damascus

Sheet Size
A3

Date : 27/8/2018

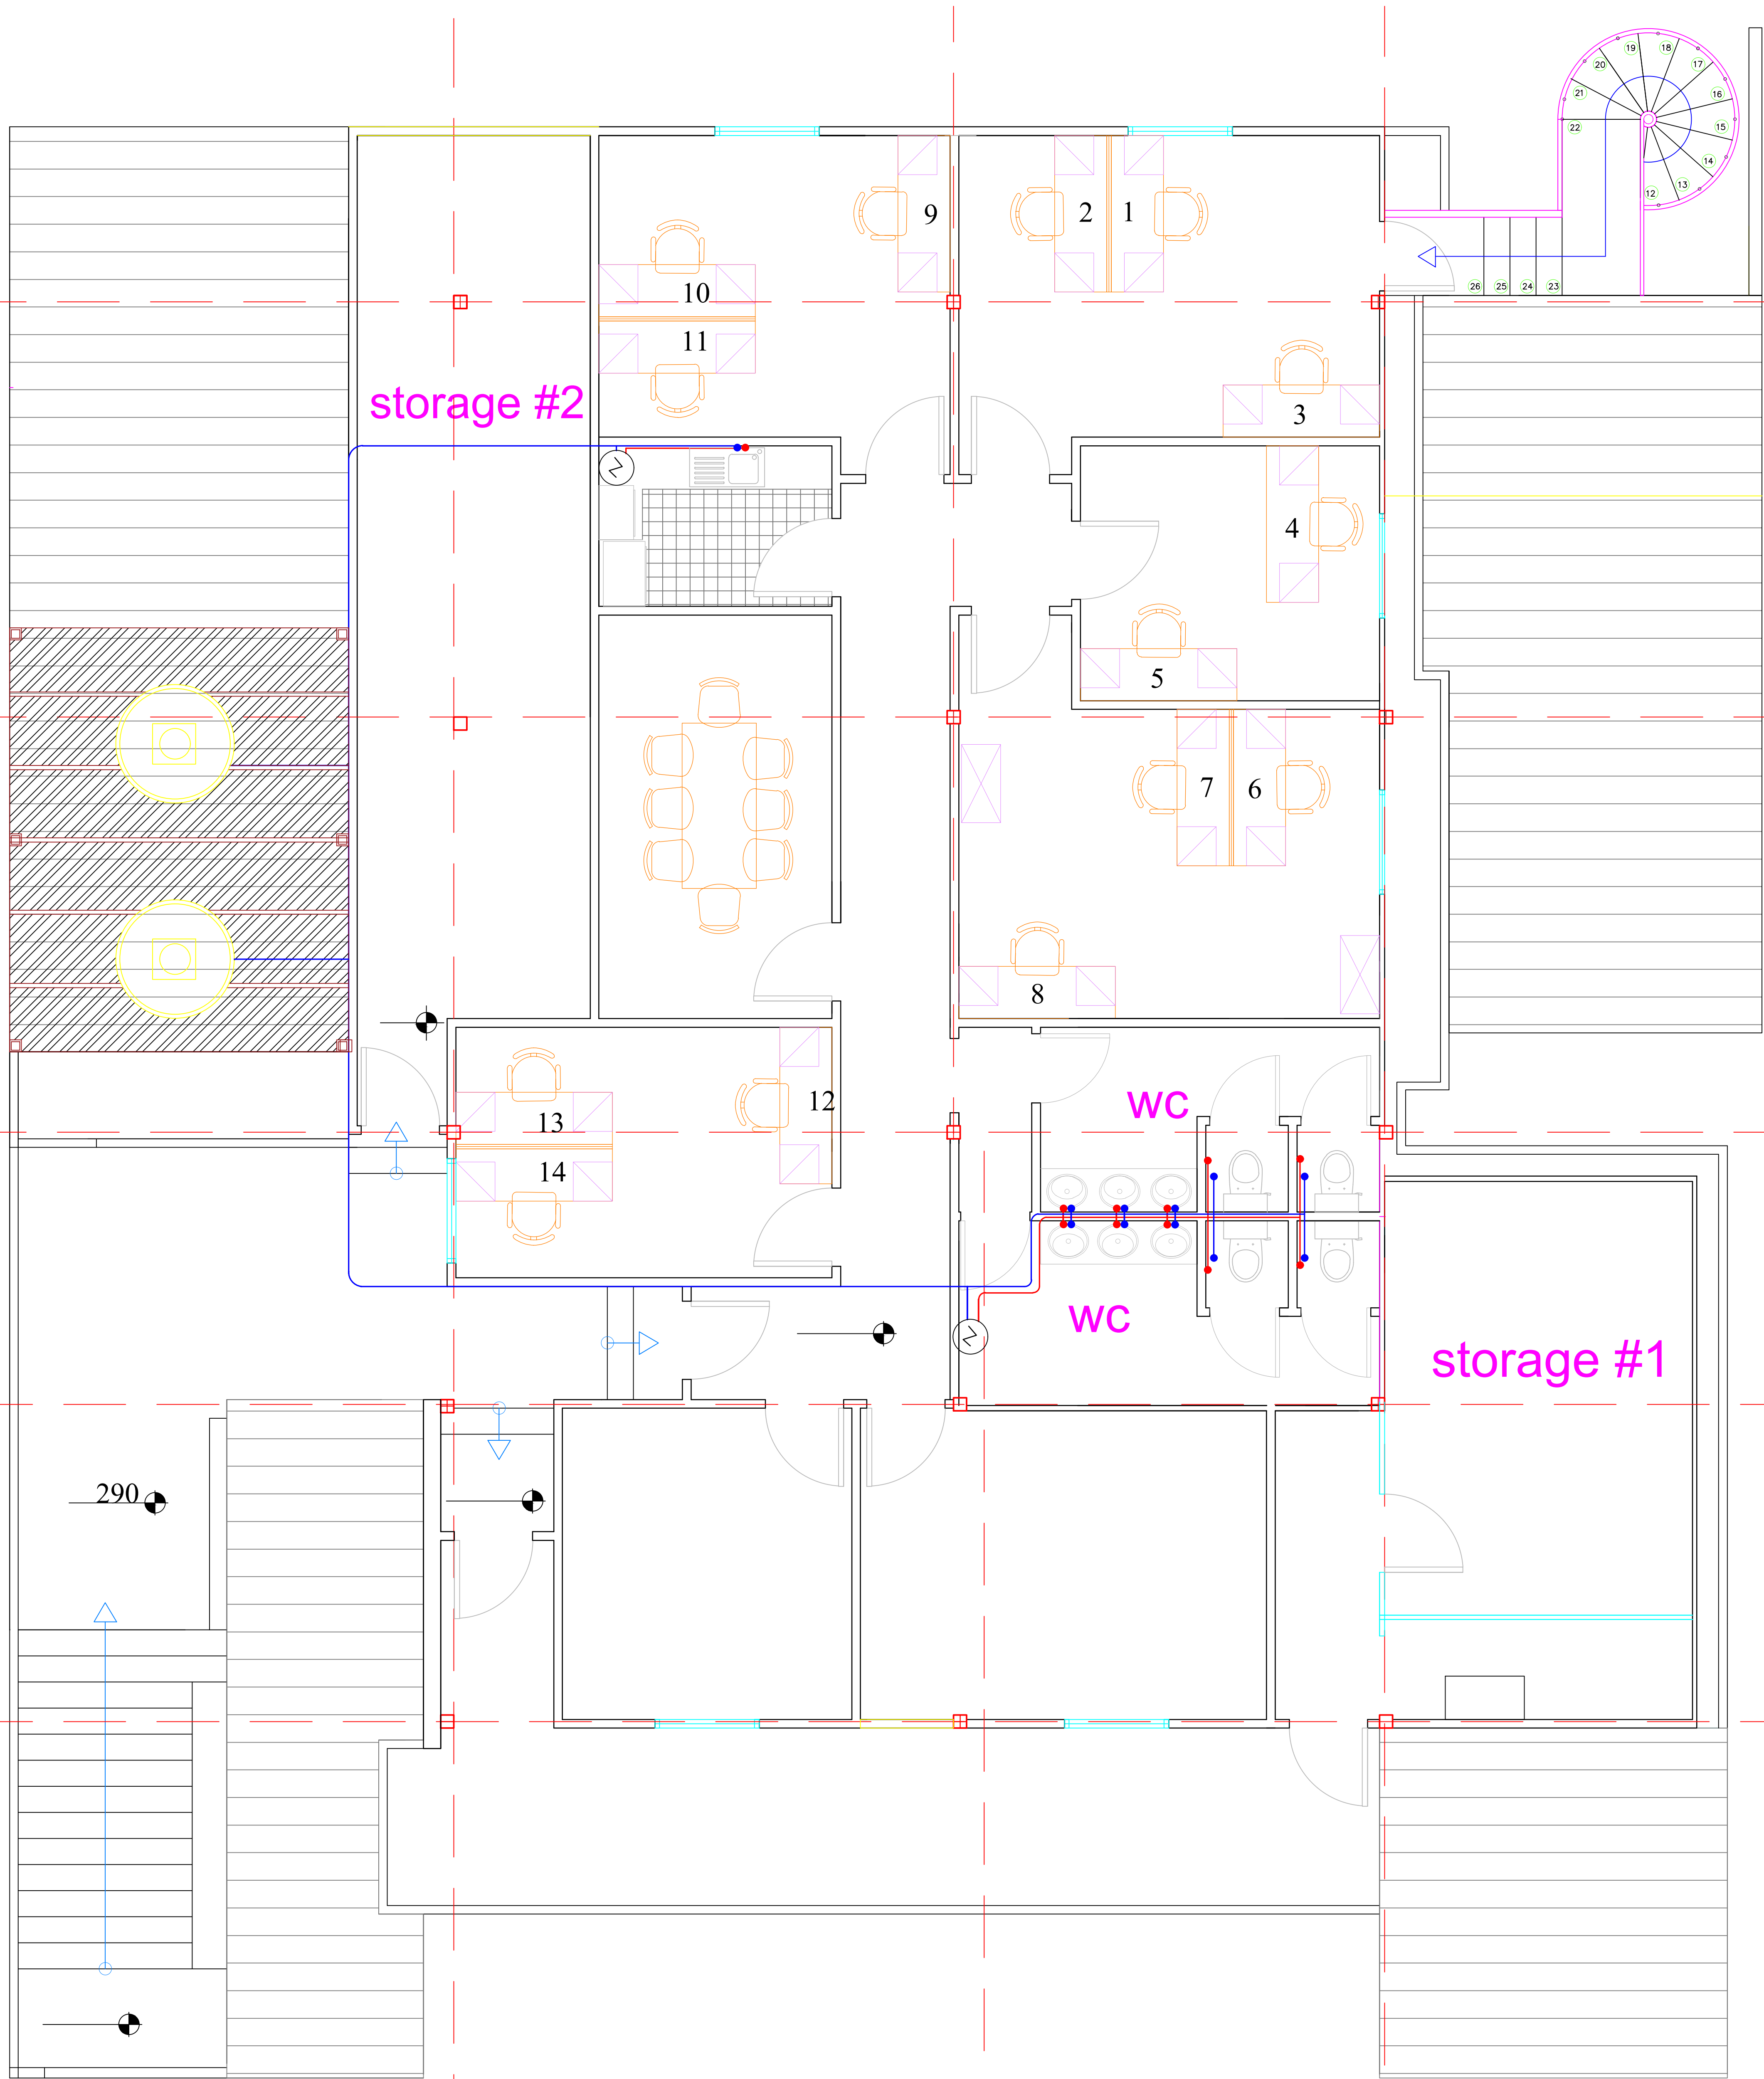

Utility Water System - phase 2

LED down light 18 w	
LED down light 12 w	
Pole light 3m with LED light	
LED light 120cm with reflector	
LED Mirror light 12 w	
one way one gang switch	
one way two gang switch	
Two way one gang switch	
Push Button	
Single socket	
Double socket	
1 Ton A/c	
1.5 Ton A/c	
Pullet camera	
Dome camera	
Smoke detector	
Heat detector	
Sounder	
Automatic Fire extinguisher	
Fire extinguisher	
Break glass	
TV Outlet	
Telephone Outlet	
Data Outlet	



Eng. Khaled Al Jammal
project manager



E-mail: khjammal@hotmail.com
Damascus , Syria

Proposal : 1st floor plan
scale : to fit

Project Name
UNFPA new floor in Damascus

Sheet Size
A3

Date : 27/8/2018

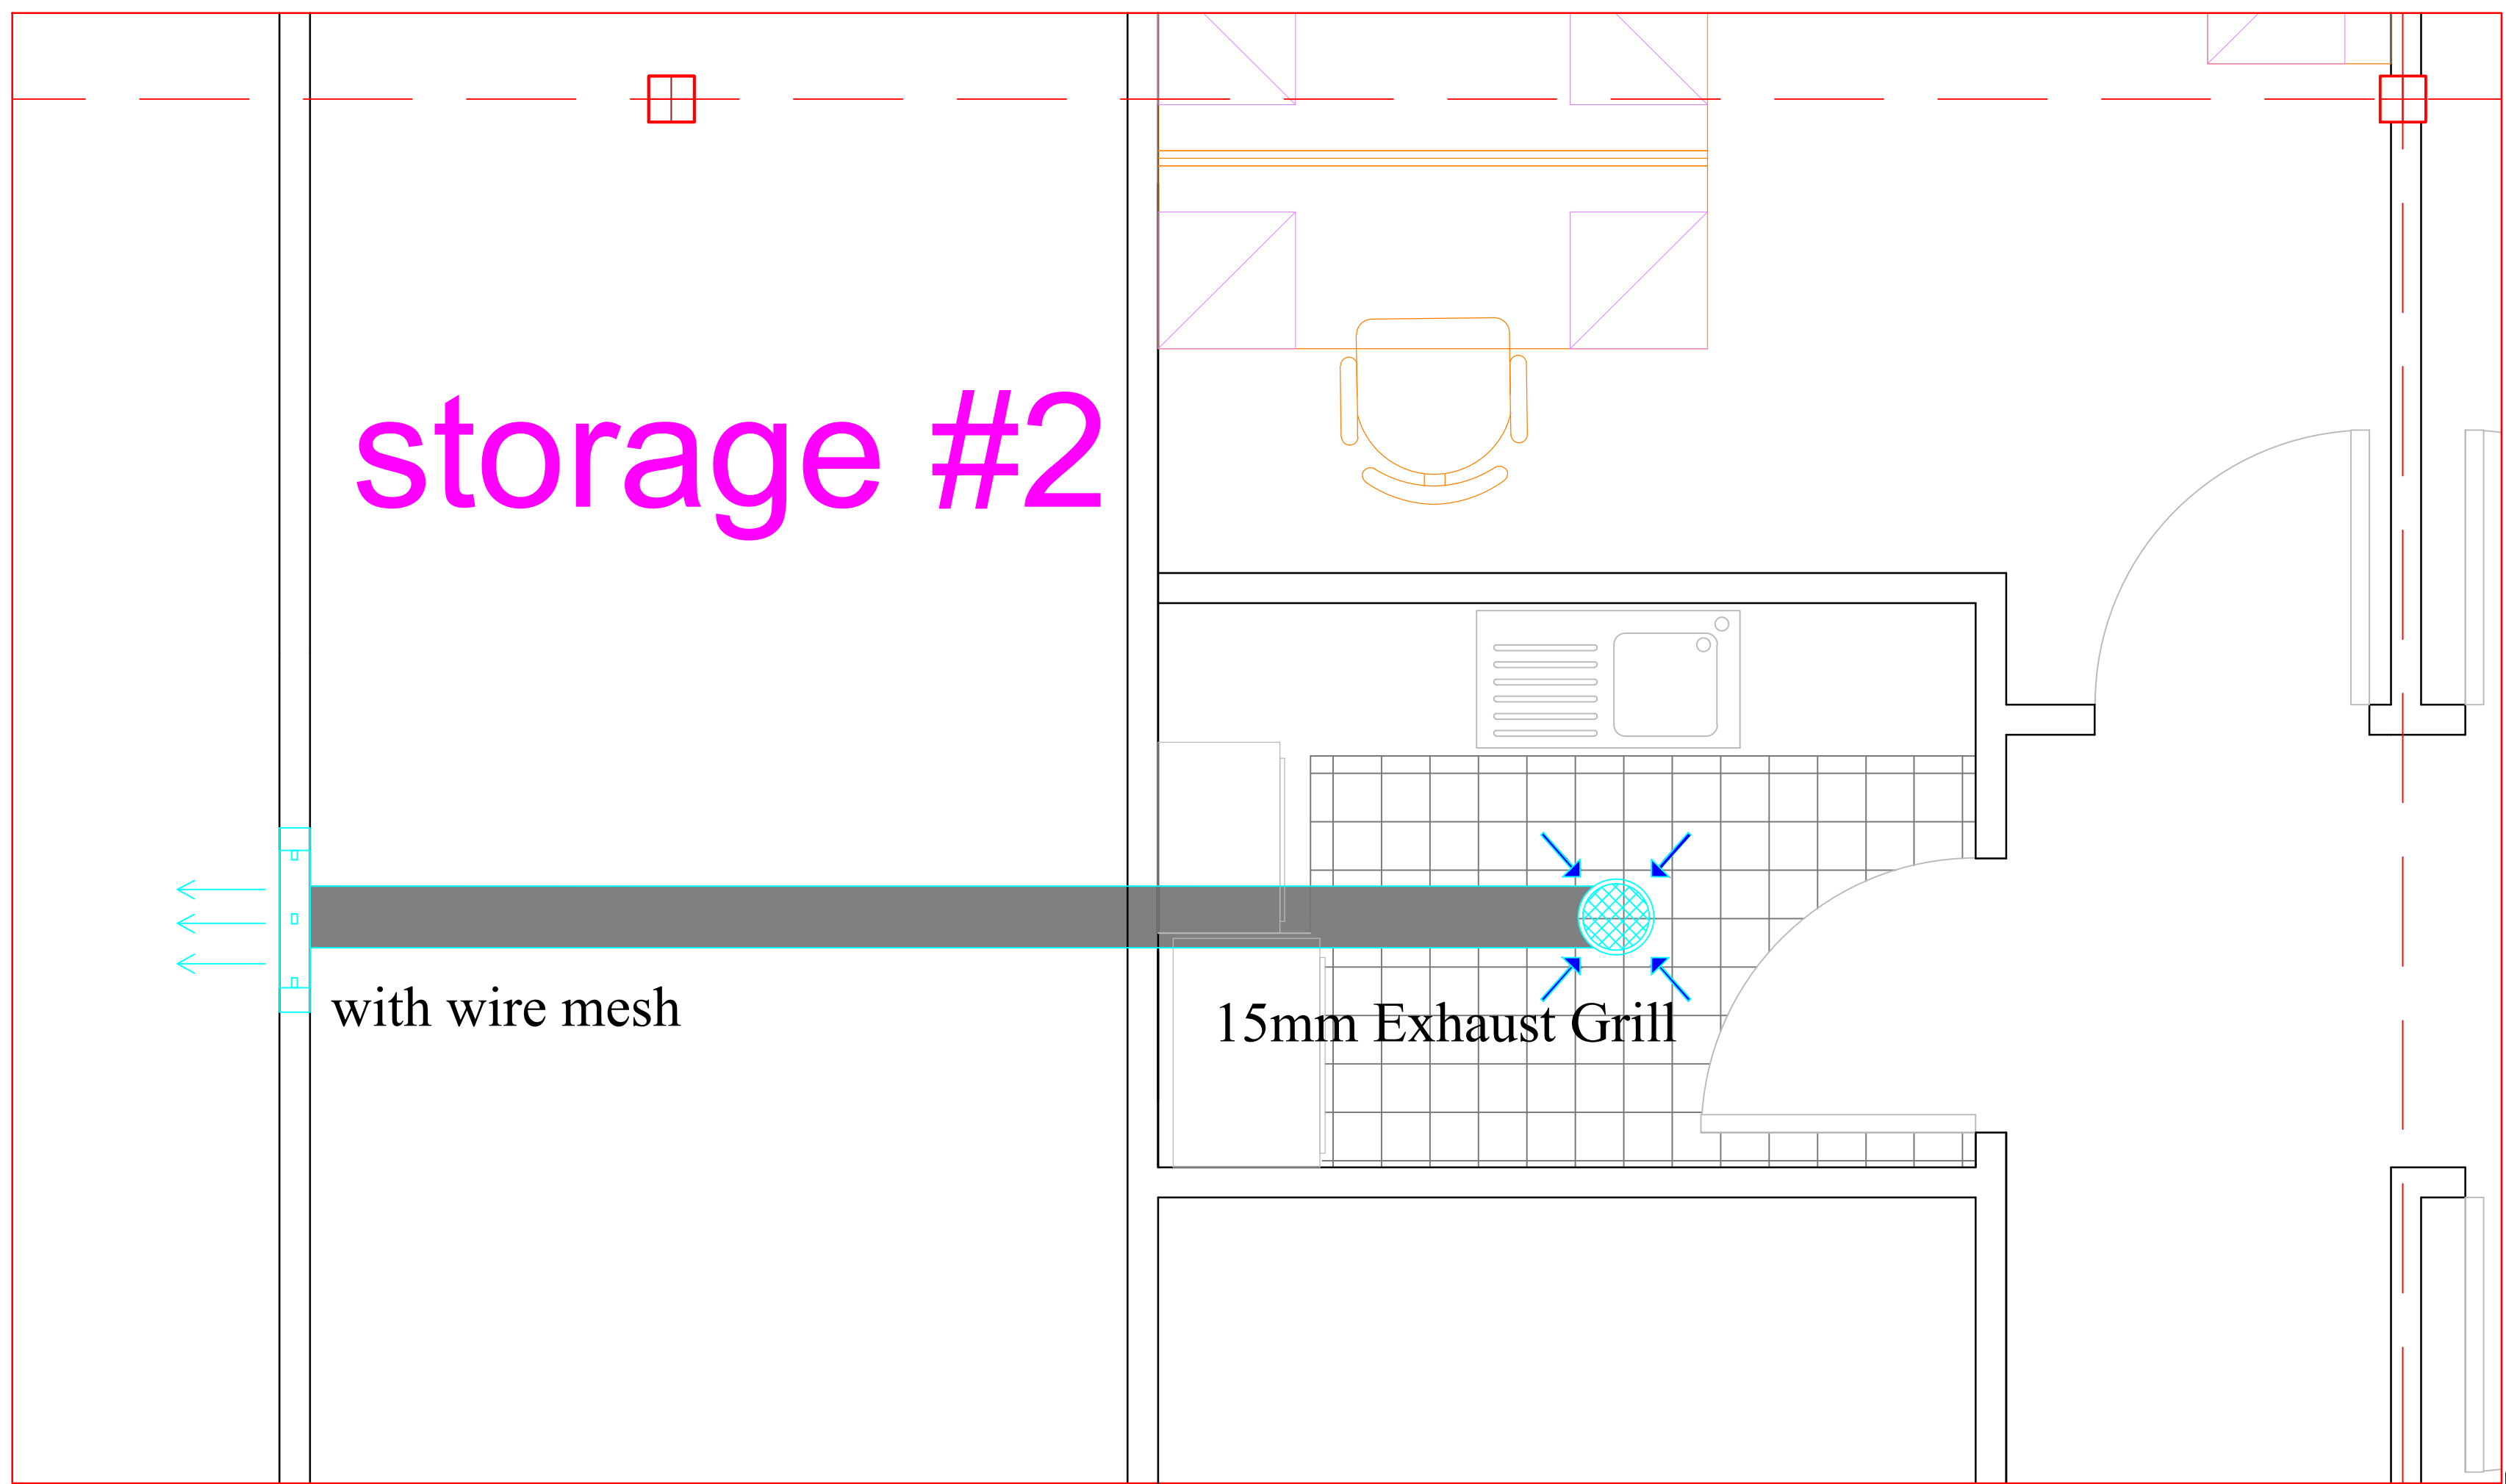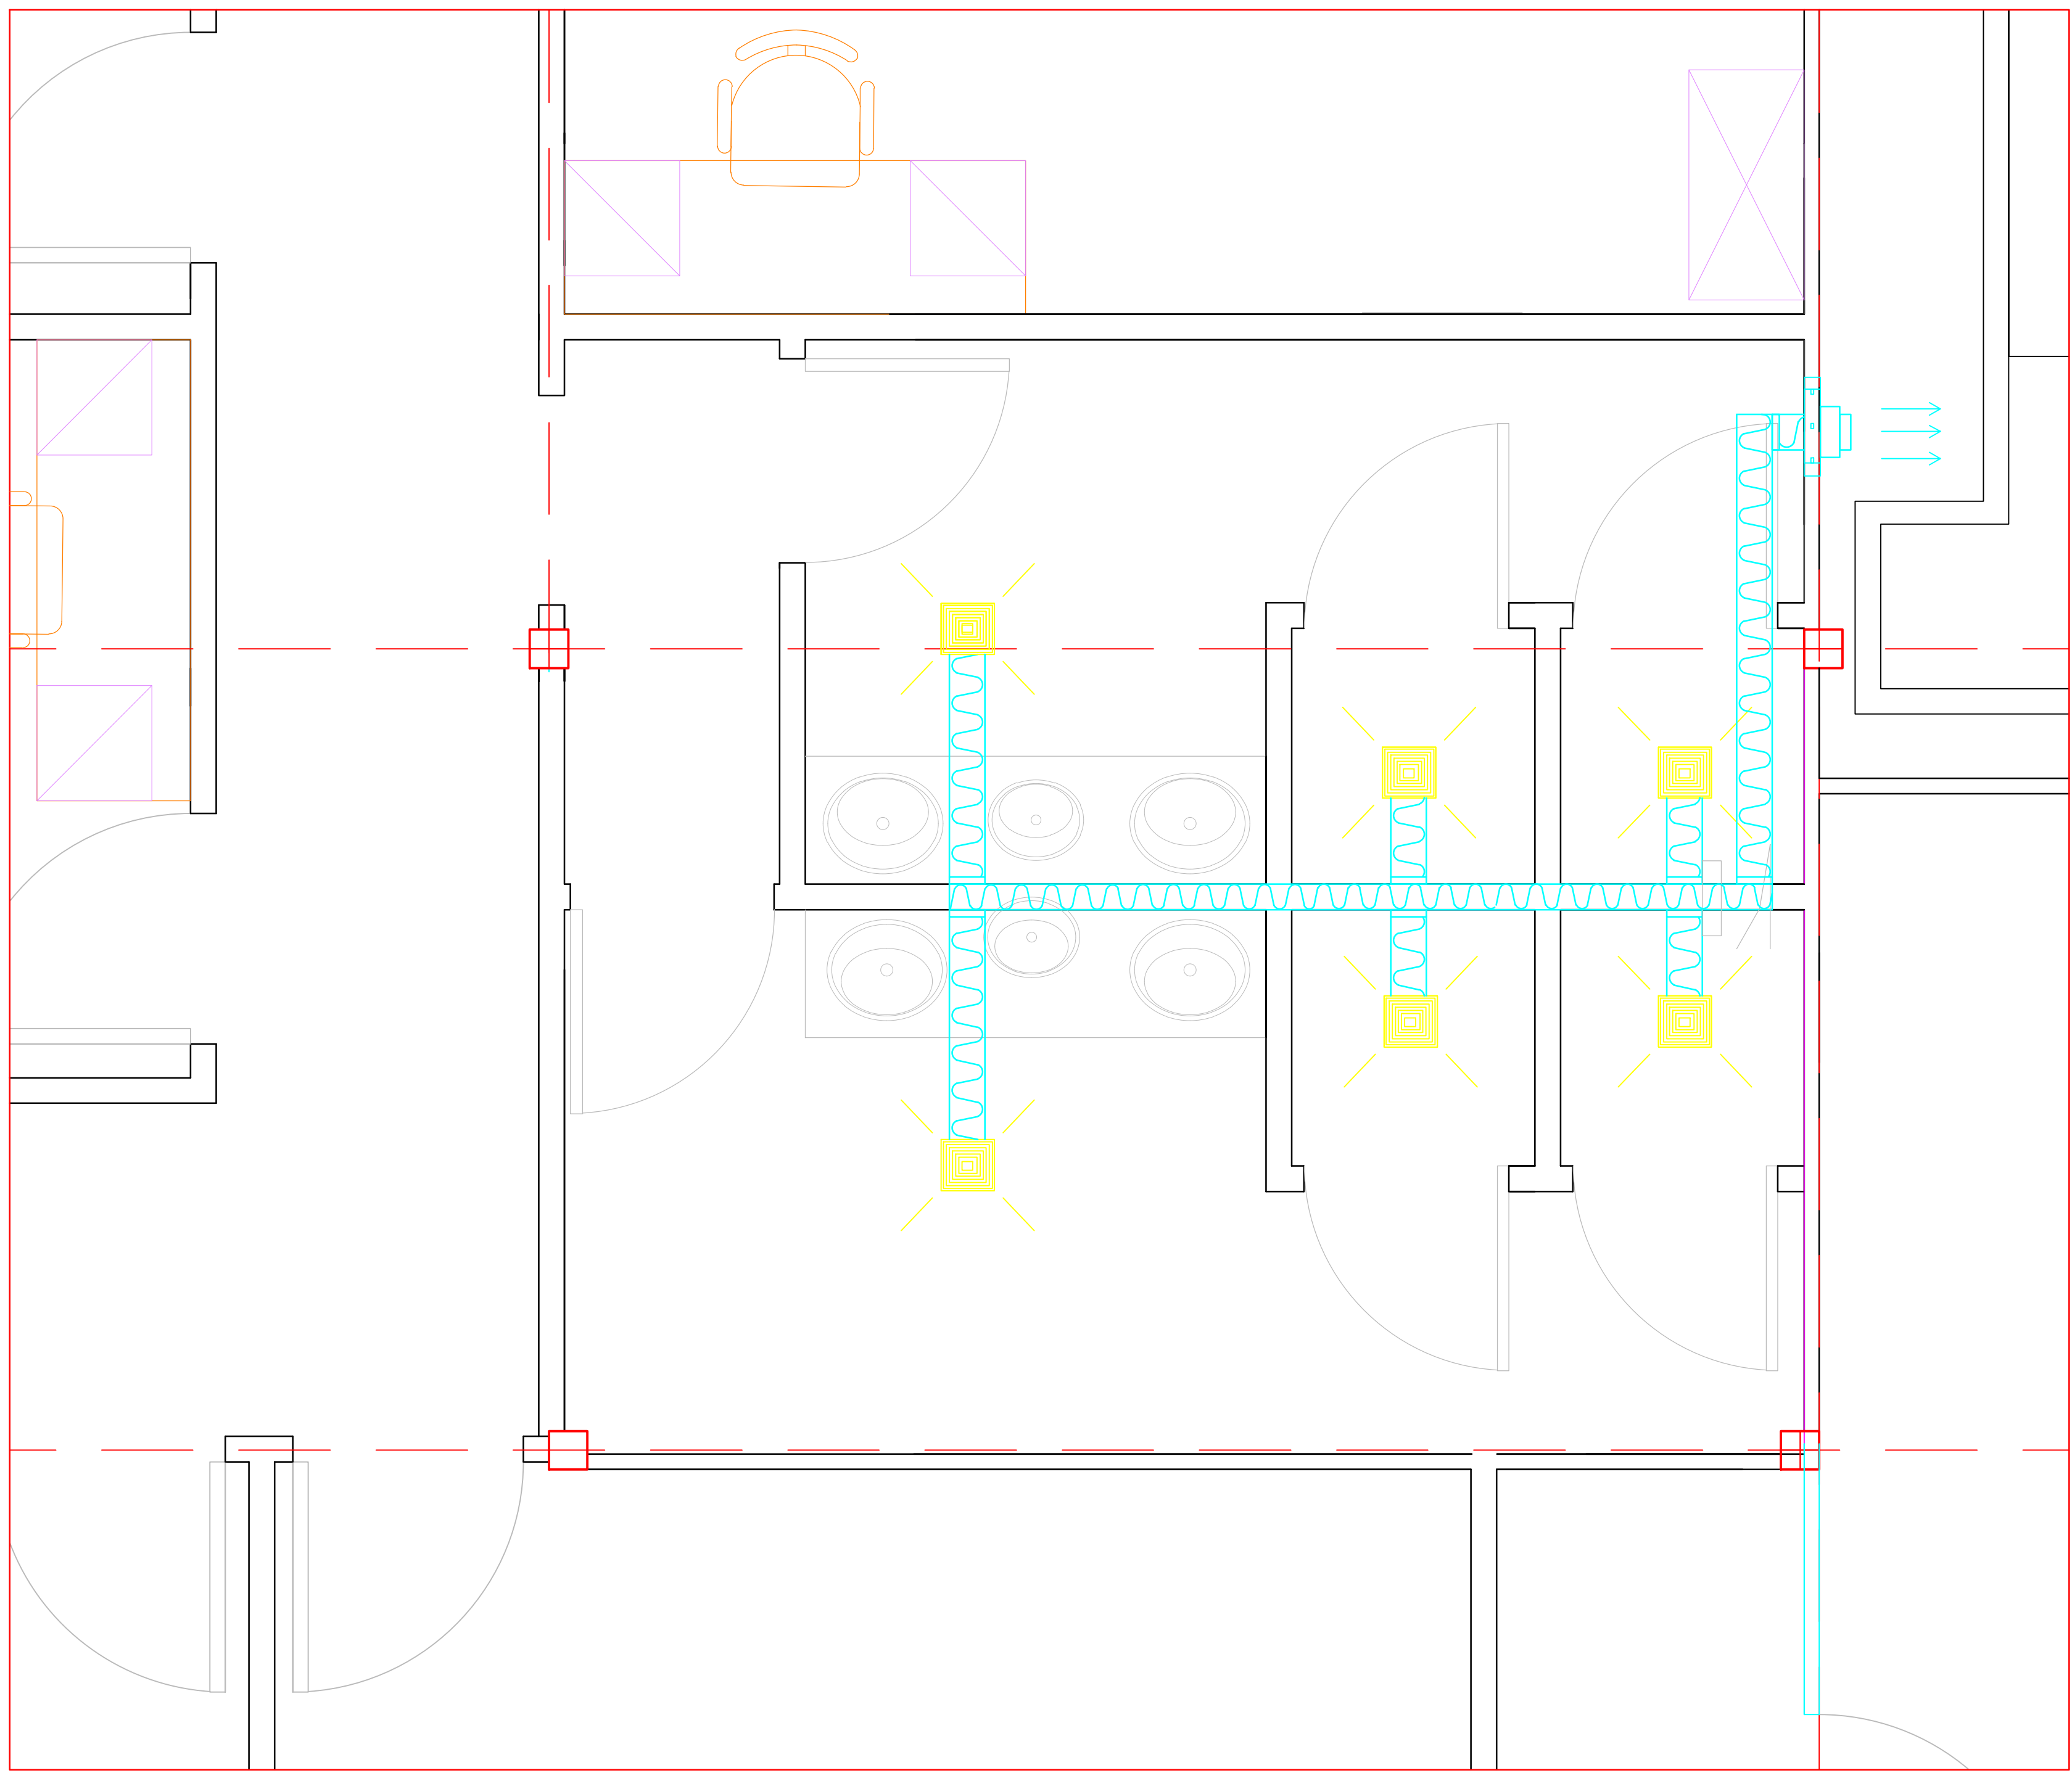

Ventilation for Bathrooms and buffet - phase 2

LED down light 18 w	
LED down light 12 w	
Pole light 3m with LED light	
LED light 120cm with reflector	
LED Mirror light 12 w	
one way one gang switch	
one way two gang switch	
Two way one gang switch	
Push Button	
Single socket	
Double socket	
1 Ton A/c	
1.5 Ton A/c	
Pullet camera	
Dome camera	
Smoke detector	
Heat detector	
Sounder	
Automatic Fire extinguisher	
Fire extinguisher	
Break glass	
TV Outlet	
Telephone Outlet	
Data Outlet	



Eng. Khaled Al Jammal
project manager

E-mail: khjammal@hotmail.com
Damascus , Syria

Proposal : 1st floor plan
scale : to fit

Project Name
UNFPA new floor in Damascus

Sheet Size
A3

Date : 27/8/2018